


SIGN DETAIL
1:75

WB-TR-80
STA. 624+50

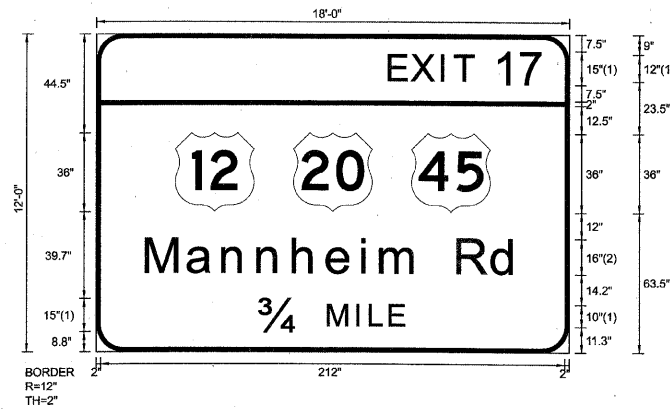

FONT:
(1) ClearviewHwy-5-W
(2) ClearviewHwy-5-W-R

Panel Style: sign_default.ssi
Dimensions are in inches.tenths

Letter locations are panel edge to lower left corner

SIGN NUMBER	name
WIDTH x HGT.	18'-0" x 12'-0"
BORDER WIDTH	2"
CORNER RADIUS	12"
MOUNTING	Overhead
BACKGROUND	TYPE: Reflective COLOR: Green
LEGEND/BORDER	TYPE: Reflective COLOR: White/White

SYMBOL	ROT	X	Y	WID	HT
M1_4	0	36	63.5	36	36
M1_4	0	90	63.5	36	36
M1_4	0	144	63.5	36	36

LETTER POSITIONS (X)

											LENGTH	SERIESSIZE
E	X	I	T	1	7							ClearviewHwy-5-W
134.2	144.4	158.1	164	182.7	193.9						70.3	12,15
M	a	n	n	h	e	i	m	R	d			ClearviewHwy-5-W-R
23.2	42.1	58.1	74.2	90.4	105.9	121.8	130.3	148.3	165.5	181.3	169.7	16/13
3/4	M	I	L	E								ClearviewHwy-5-W
75.2	106.4	119.5	125.4	134.5							65.7	15,10

FILE NAME =	DESIGNED - SEW	REVISED -
FILEL	DRAWN - SEW	REVISED -
USER NAME = *USER*	CHECKED - FML	REVISED -
PLOT DATE = *DATE*	DATE - 1/25/10	REVISED -



STATE OF ILLINOIS
DEPARTMENT OF TRANSPORTATION

SIGNING DETAILS

SCALE: N.T.S. SHEET NO. 37 OF 43 SHEETS STA. TO STA.

F.A.I. RTE.	SECTION	COUNTY	TOTAL SHEETS	SHEET NO.
290	(3435, ETC., 3838)RS-5	COOK	264	192
FED. ROAD DIST. NO. ILLINOIS FED. AID PROJECT			CONTRACT NO. 60G52	