



FILE PATH = p:\388035-p\m\l\ecomm\l\l\local\p\AECDWG\Documents\01_Americas\Transportation\60269938_Circle\Phase_1\1000_CAD\016_Electrical\Sheets\60W29_sht-Light-13

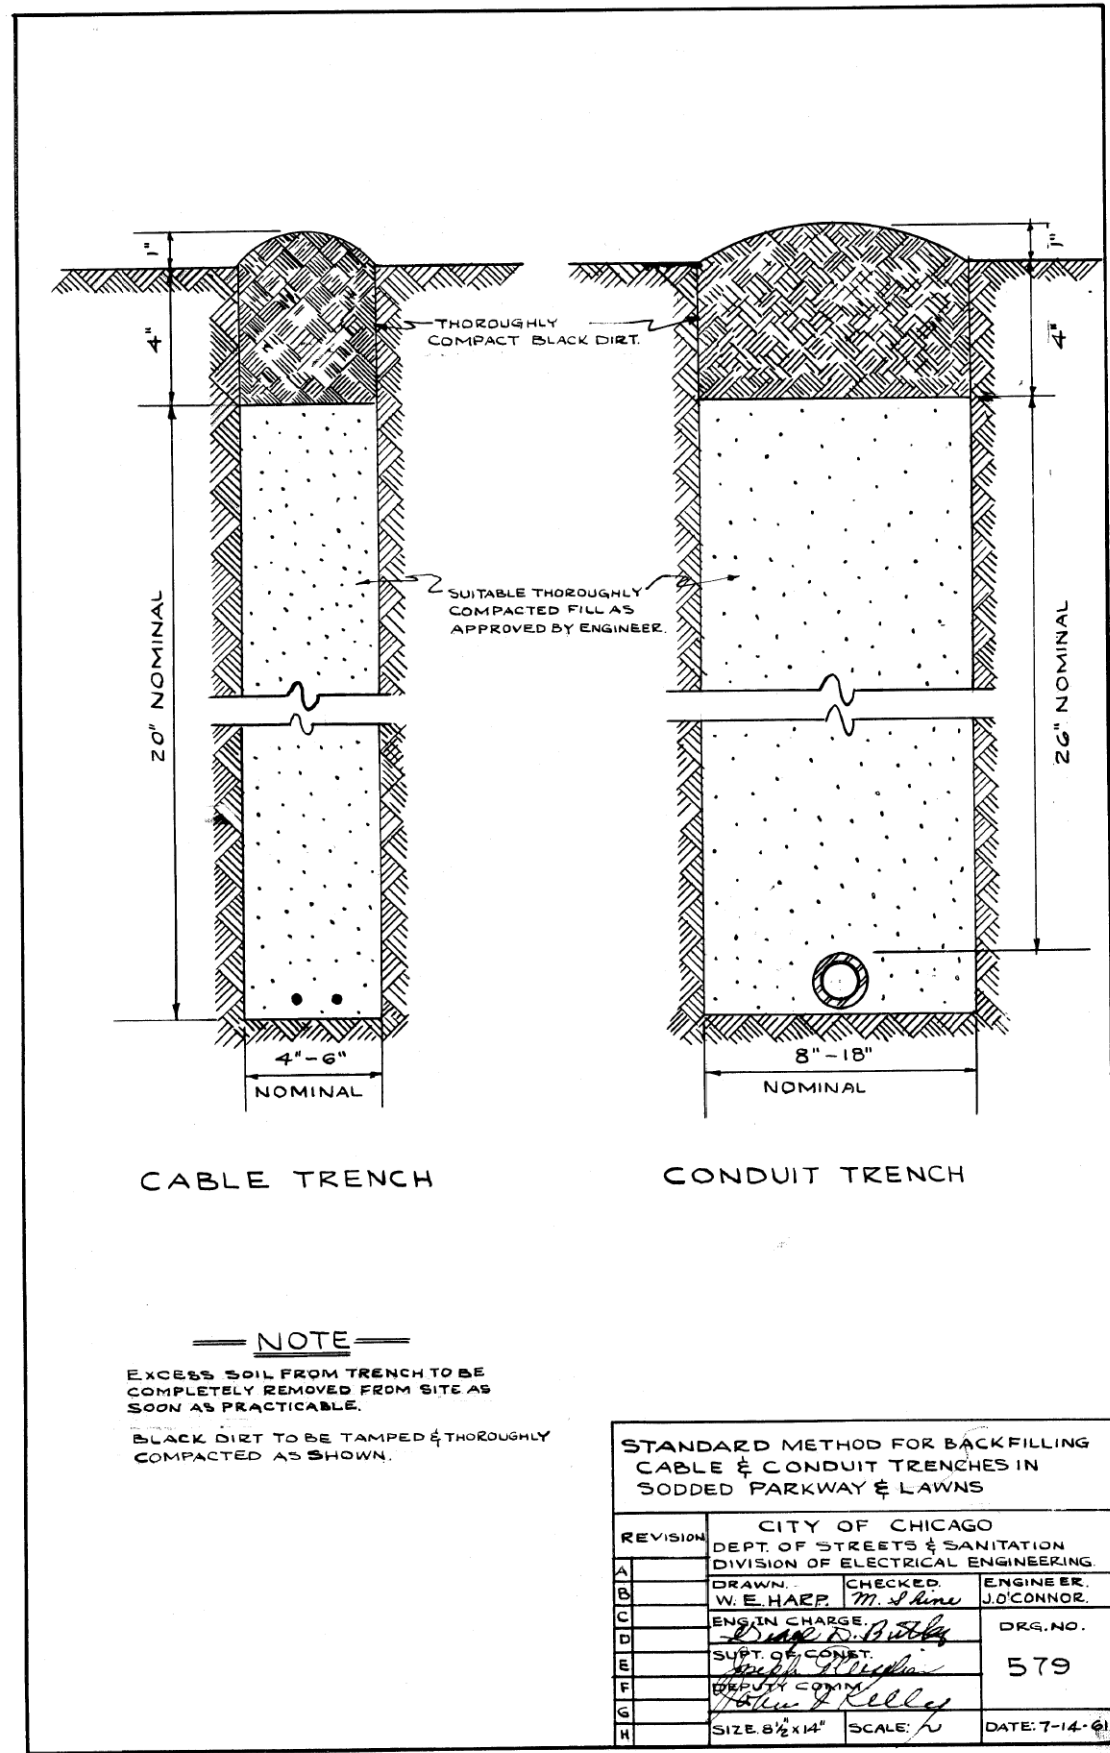

J:\ALL 2\STANDARD\565.DGN 12/11/2006 10:56:45 AM

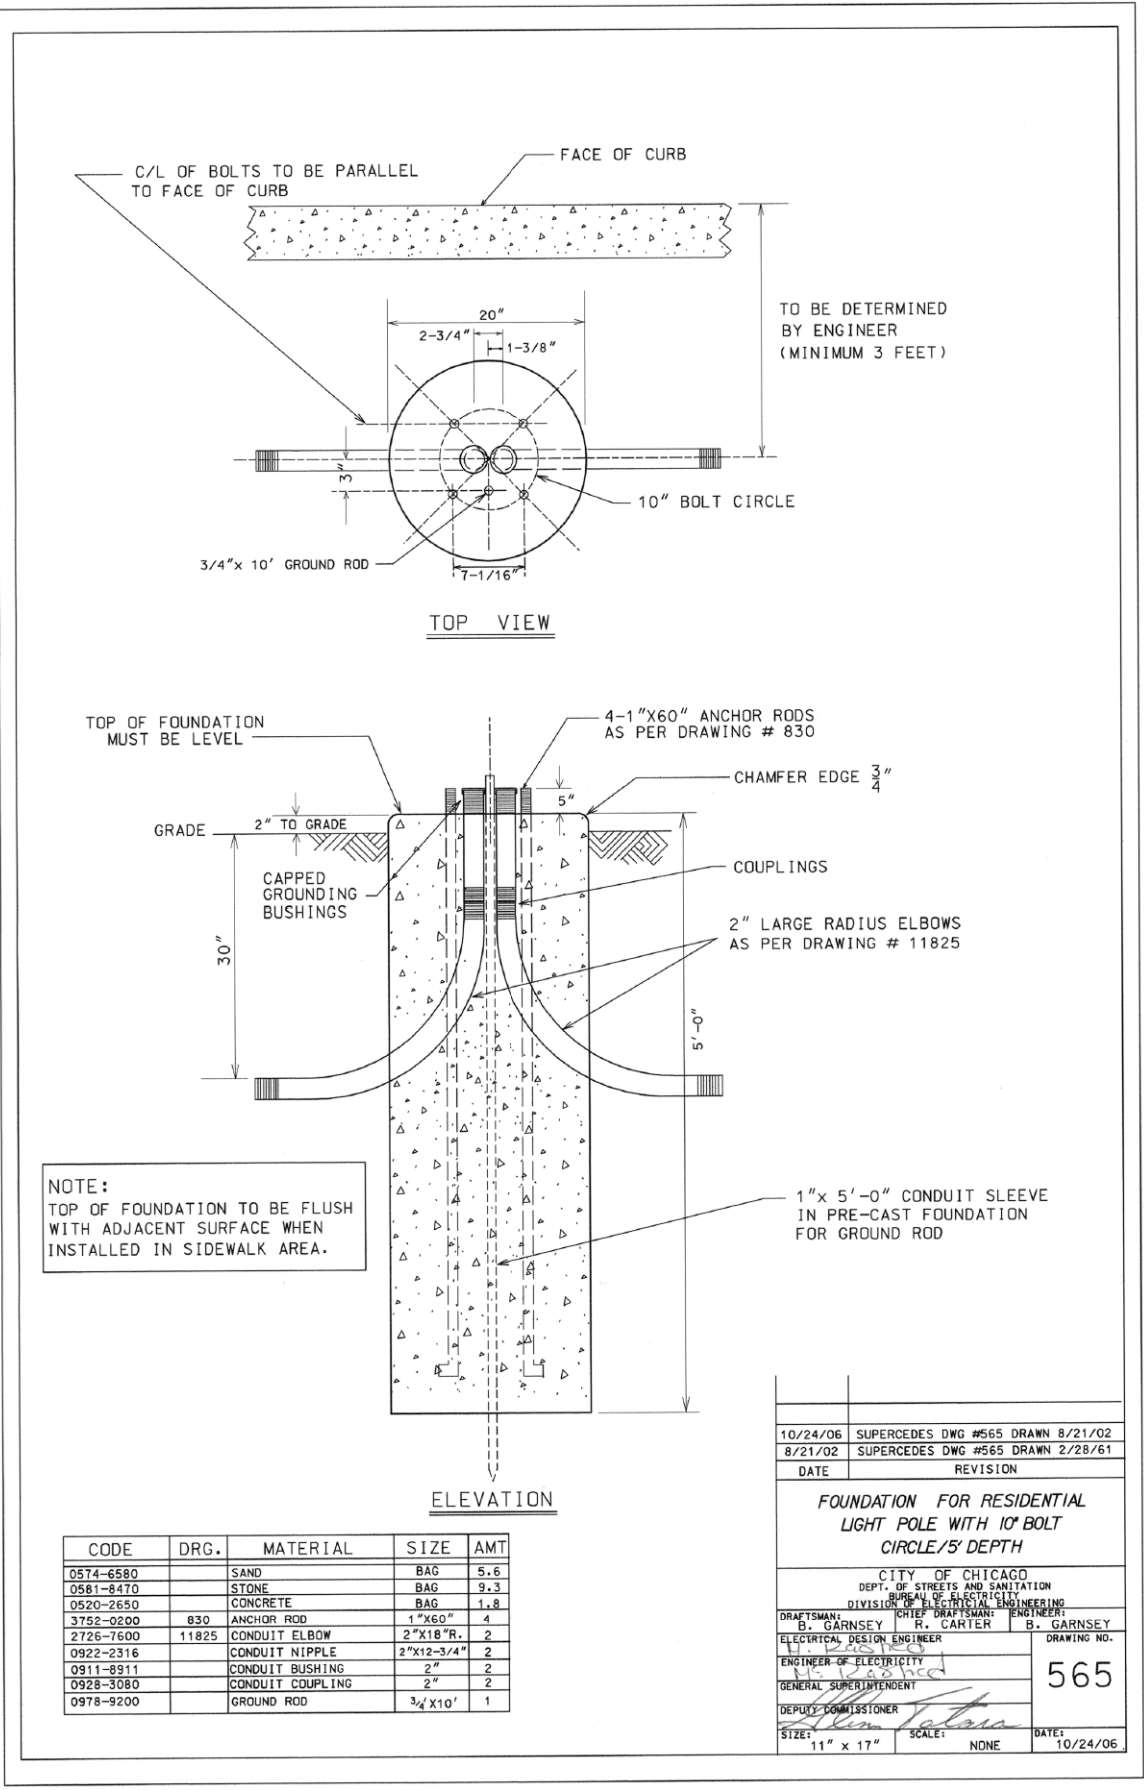

D160W29-sht-Light-13
USER NAME = BAW:tor t
PLOT SCALE = 2.0000' / in.
PLOT DATE = 10/28/2013

DESIGNED - WDS
DRAWN - CAM
CHECKED - WDS
DATE - 10/30/2013

REVISED -
REVISED -
REVISED -
REVISED -

STATE OF ILLINOIS
DEPARTMENT OF TRANSPORTATION

MISCELLANEOUS ELECTRICAL DETAILS

SCALE: N.T.S. SHEET 13 OF 19 SHEETS STA. TO STA.

F.A.I. R.E.	SECTION	COUNTY	TOTAL SHEETS	SHEET NO.
90/94/290	2013-011R	COOK	356	123
CONTRACT NO. 60W29				
ILLINOIS FED. AID PROJECT				