



D160W29-sht-Light-18
 USER NAME = BAW1ort
 PLOT SCALE = 2.0000' / in.
 PLOT DATE = 10/28/2013


DESIGNED - WDS
 DRAWN - CAM
 CHECKED - WDS
 DATE - 10/30/2013

STATE OF ILLINOIS
 DEPARTMENT OF TRANSPORTATION

MISCELLANEOUS ELECTRICAL DETAILS

SCALE: N.T.S. SHEET 18 OF 19 SHEETS STA. TO STA.

F.A.I. R.T.E.	SECTION	COUNTY	TOTAL SHEETS	SHEET NO.
90/94/290	2013-011R	COOK	356	128
CONTRACT NO. 60W29			ILLINOIS FED. AID PROJECT	

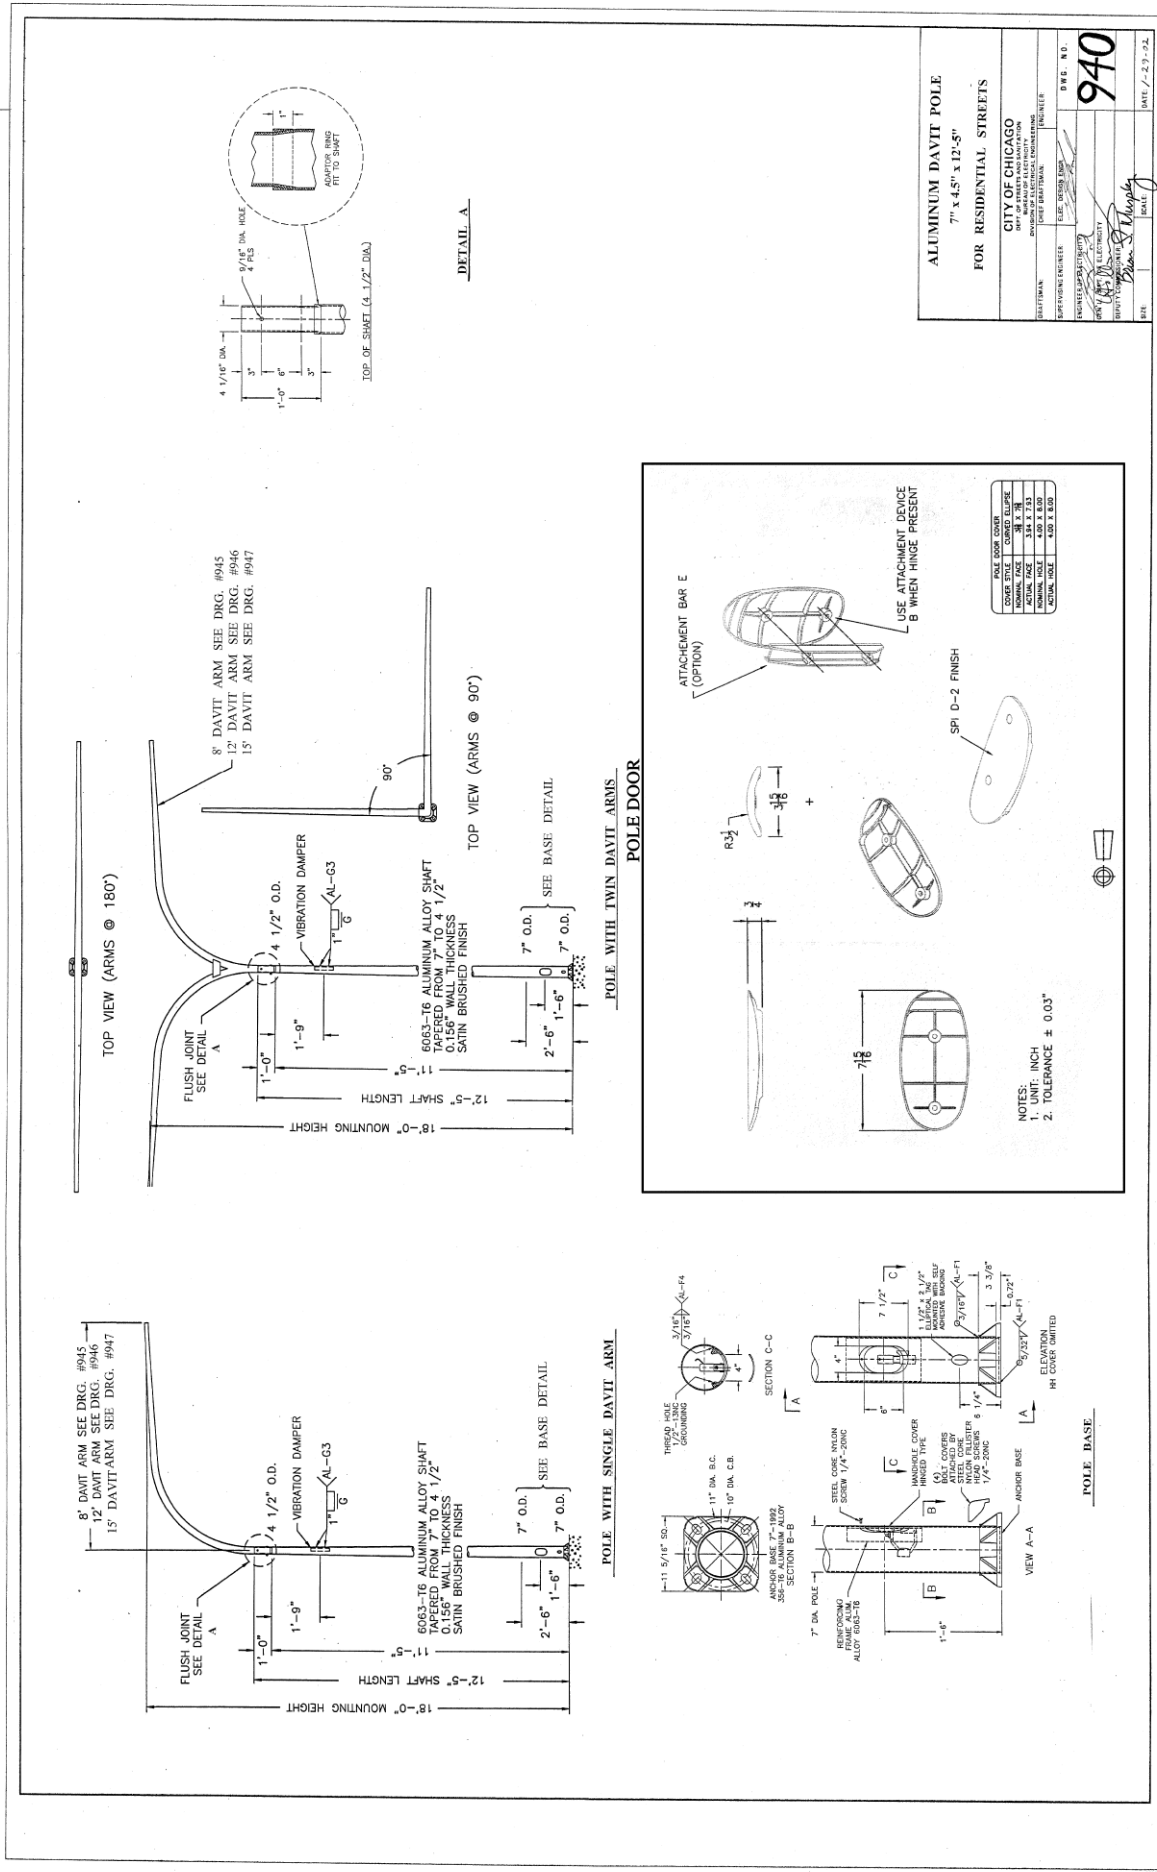

ALUMINUM DAVIT POLE
 7" x 4.5" x 12.5"
 FOR RESIDENTIAL STREETS
 CITY OF CHICAGO
 945
 DATE: 7-27-12

ALUMINUM DAVIT ARM
 4.5" x 8'-0"
 CITY OF CHICAGO
 945
 DATE: 7-27-12