
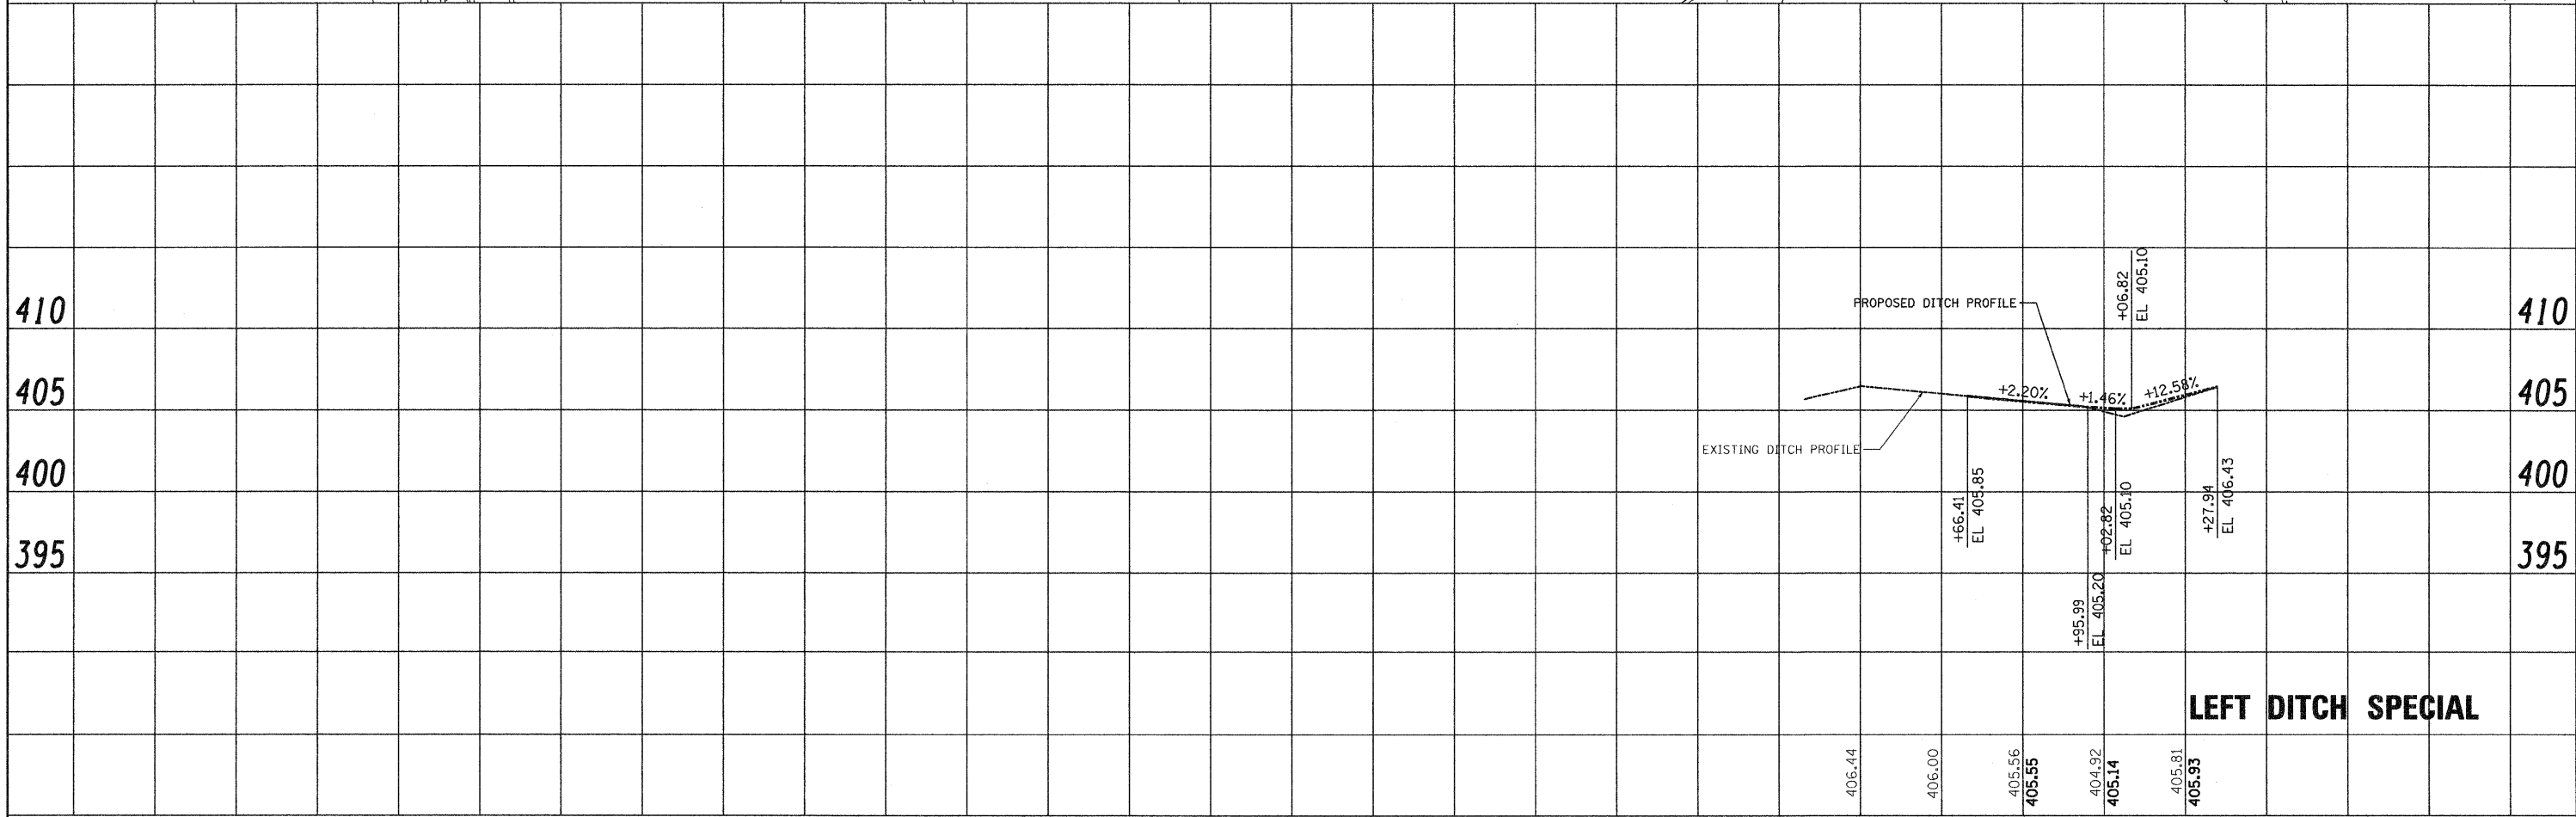


PLAN	SURVEYED	DATE
	PLOTTED	BY
	NOTED	
	FILED	
	CADD FILE NAME	

PROFILE	SURVEYED	DATE
	PLOTTED	BY
	NOTED	
	FILED	
	CADD FILE NAME	

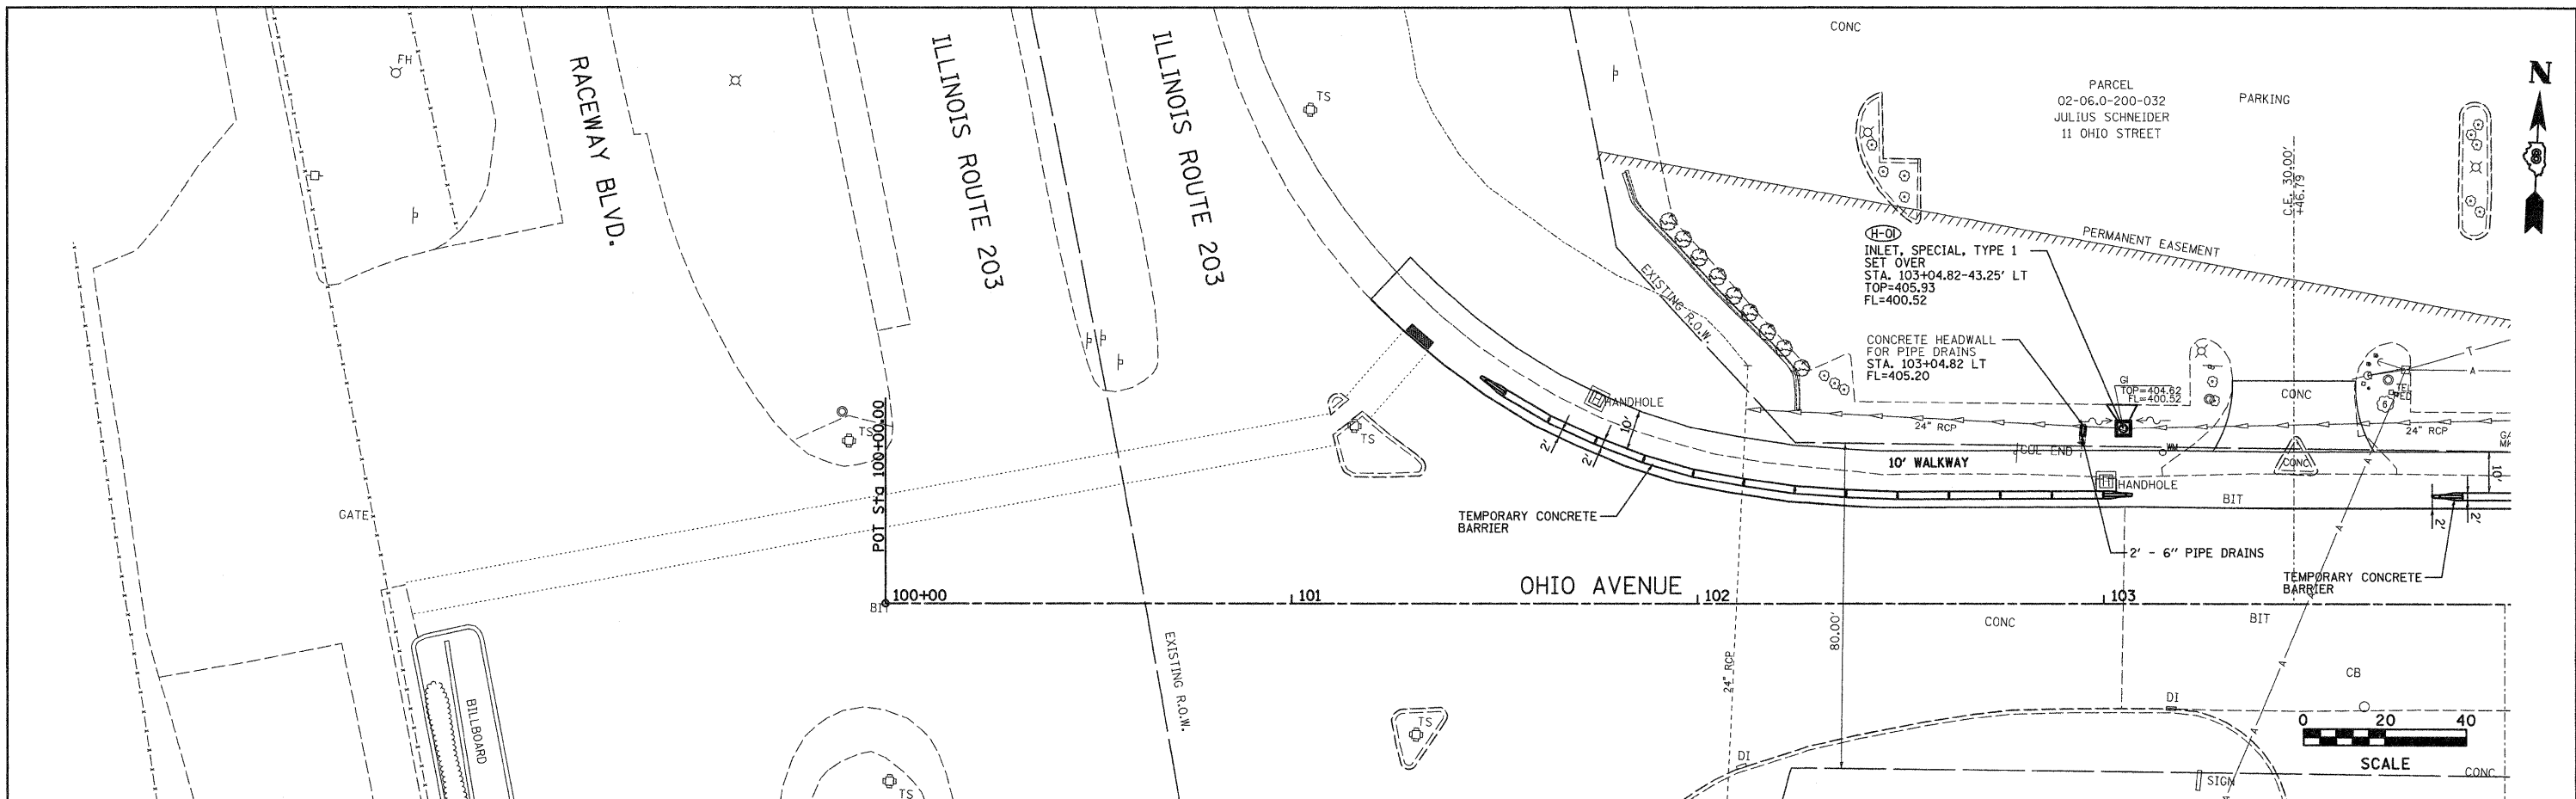

FILE NAME = drain_01	USER NAME = Jeremy	DESIGNED - BFK	REVISED -	OHIO AVENUE PEDESTRIAN WALKWAY MADISON, ILLINOIS	DRAINAGE PLAN				F.A. RTE.	SECTION	COUNTY	TOTAL SHEETS	SHEET NO.	
	PLOT SCALE = #SCALE#	DRAWN - JJB	REVISED -		SCALE:	SHEET NO.	OF	SHEETS	STA.	TO STA.	09-00049-01-SW	ST. CLAIR	26	16
	PLOT DATE = 12/18/2009	CHECKED - BFK	REVISED -		CONTRACT NO. 97420									
		DATE -	REVISED -		ILLINOIS FED. AID PROJECT									