

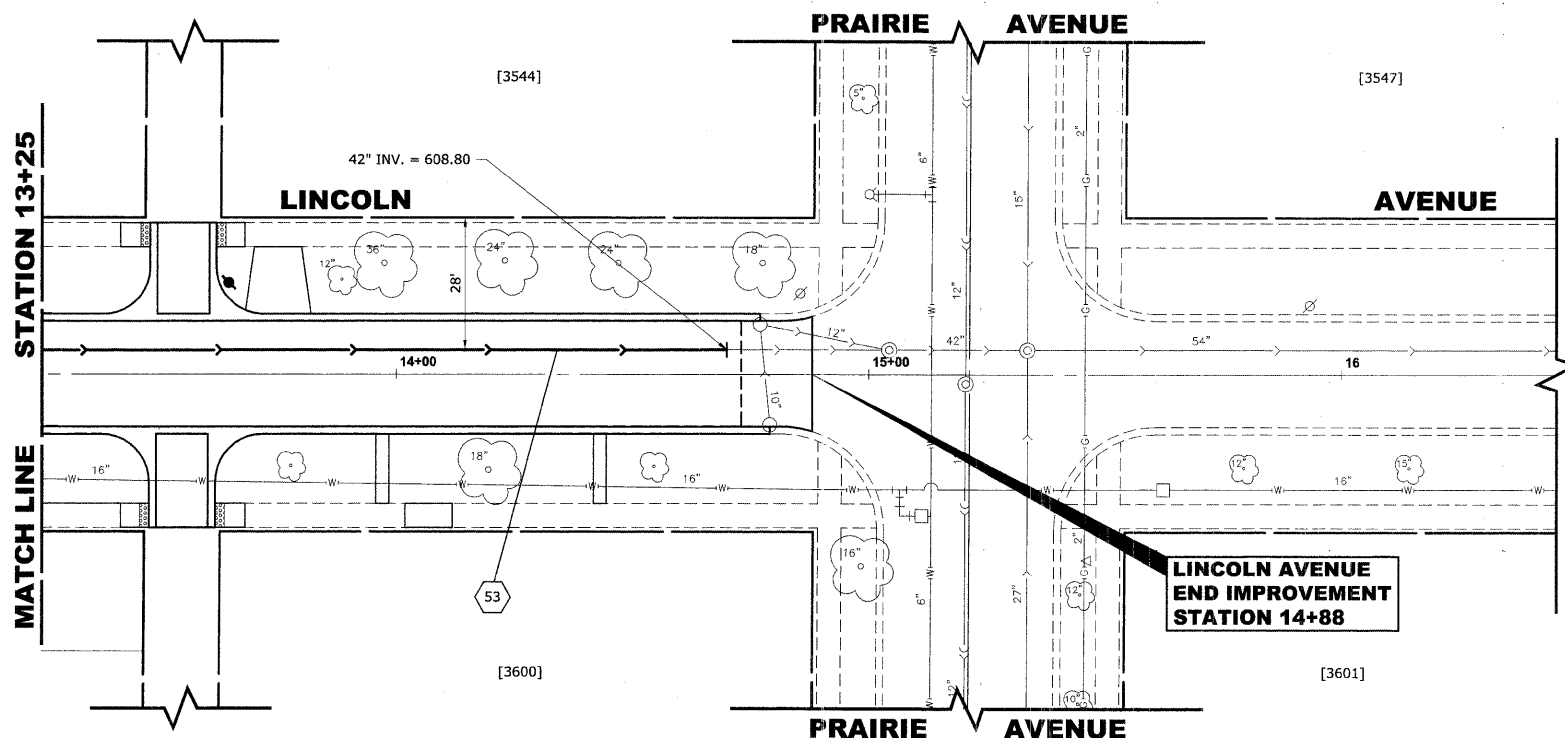


ROUTE NO.	SECTION	COUNTY	TOTAL SHEETS	SHEET NO.
FAU 1694	07-00122-00-PV	COOK	55	31
ILLINOIS PROJECT M-9003 (125)				
VILLAGE SECTION				
CONTRACT NO. 63101				

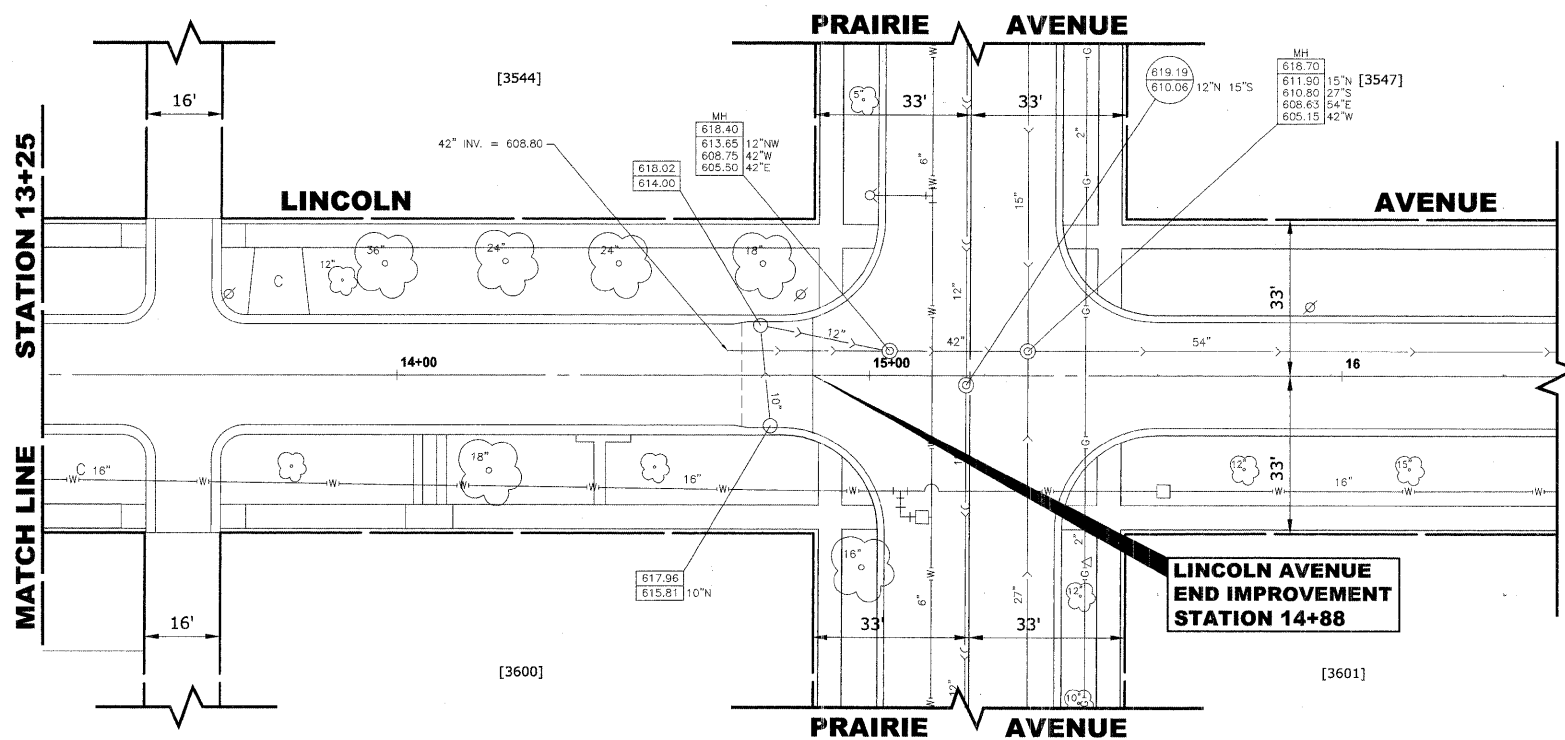

PIPE NO	LENGTH	DIA.	TYPE	SLOPE	C.Y.T.B.
53	275'	42"	SS, TY-2, RCCP, CL-III	0.09%	478.2

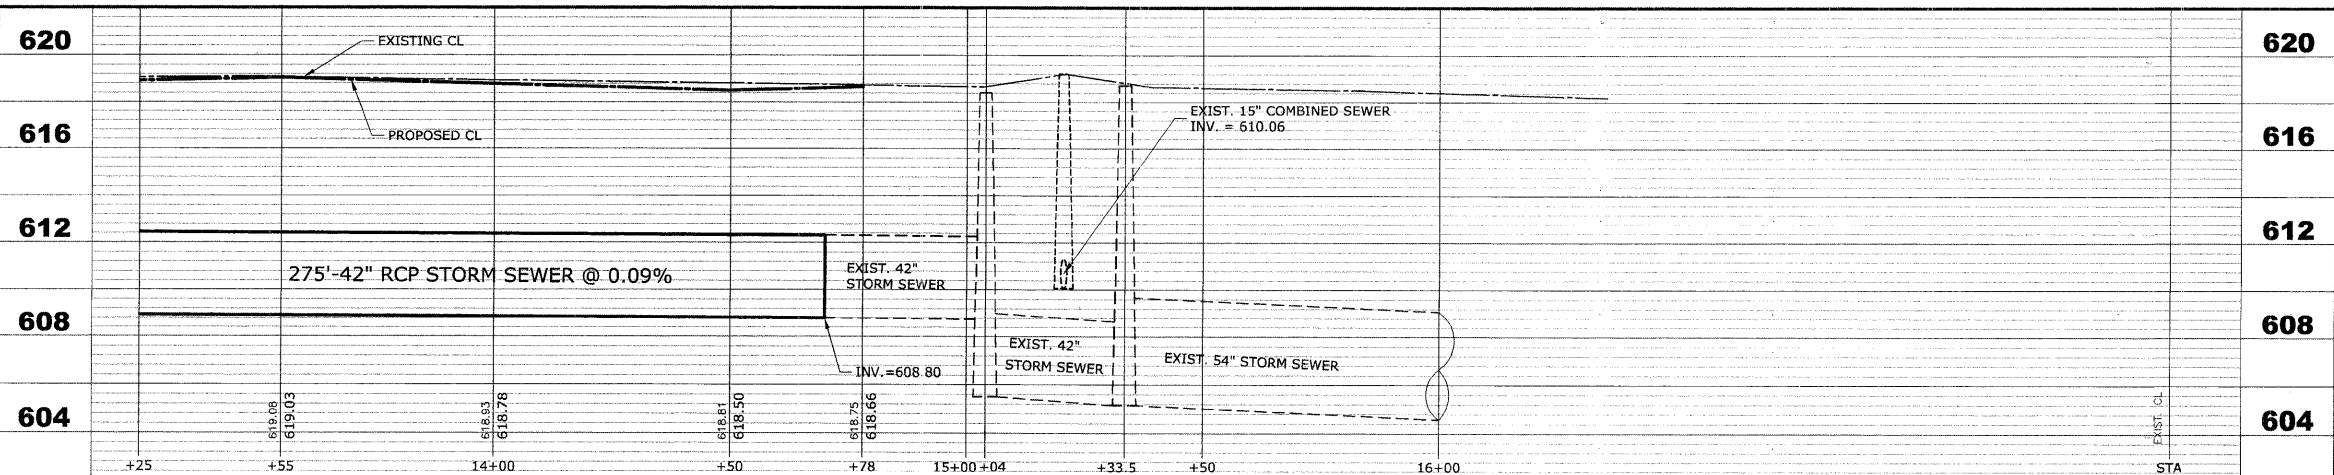

HANCOCK ENGINEERING

- Civil Engineers
- Municipal Consultants
- Established 1911

9033 Rosemead Road
Woodstock, Illinois 60094-2786
Phone: 708.665-0100
Fax: 708.665-1212

BROOKFIELD
GRAND BOULEVARD IMPROVEMENTS
LINCOLN AVENUE
UTILITIES PLAN AND PROFILE

REVISION:

DRAWN BY: LEVEC/WMK
CHECKED BY: JCG
DATE: 01-09-09

SCALE: 1"=20'H. & 1"=4'V.

E.H.E. PROJECT NO. : 125-08-13501

Drawing file: W:\Projects\12508135 - Grand Blvd Grant to Veterans' Grand Blvd\Grand Blvd.dwg Jun 09, 2009 - 10:53am