


PLAN	SUBMITTED	DATE
NOTE BOOK	PLOTTED	BY
NO.	ALIGNMENT CHECKED	
	CONTRACT NO.	
	CADD FILE NAME	

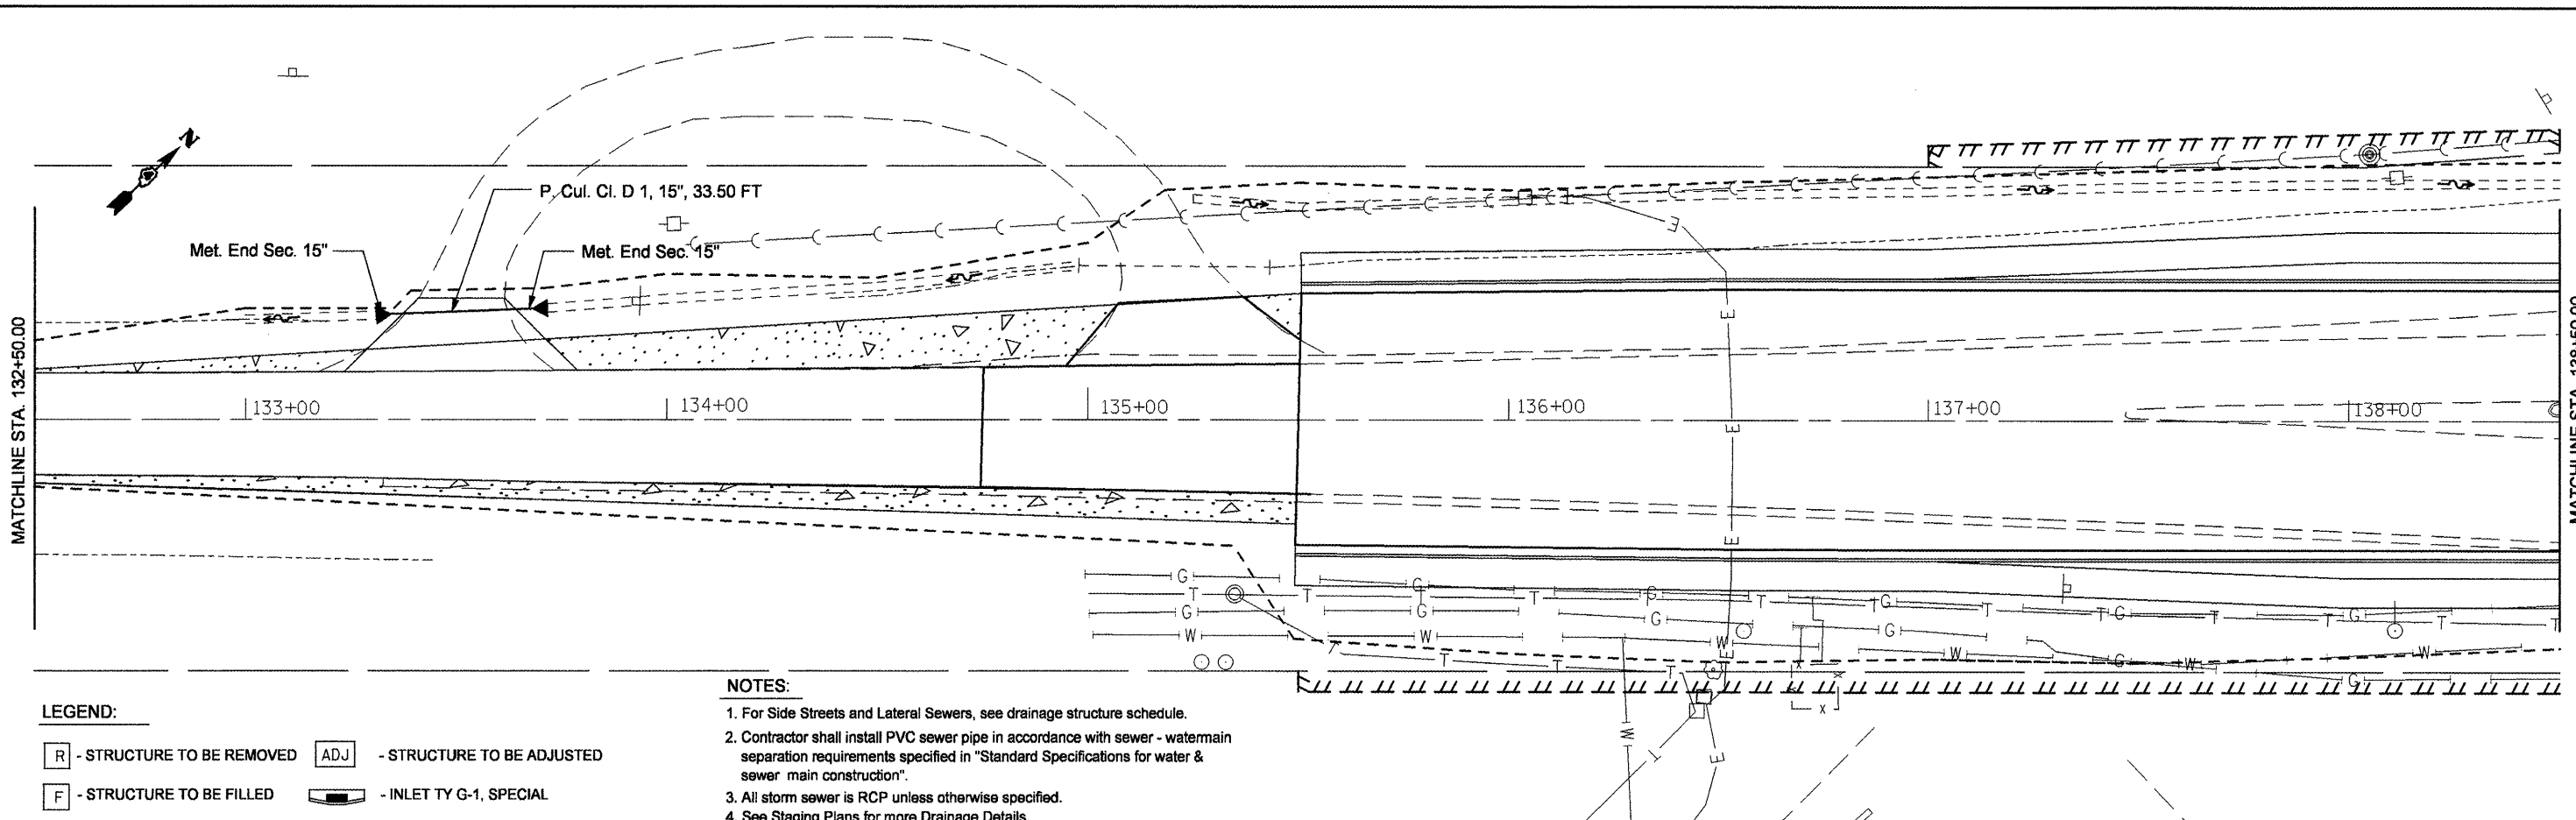


LEGEND:

- [R] - STRUCTURE TO BE REMOVED
- [ADJ] - STRUCTURE TO BE ADJUSTED
- [F] - STRUCTURE TO BE FILLED
- [Symbol] - INLET TY G-1, SPECIAL

NOTES:

1. For Side Streets and Lateral Sewers, see drainage structure schedule.
2. Contractor shall install PVC sewer pipe in accordance with sewer - watermain separation requirements specified in "Standard Specifications for water & sewer main construction".
3. All storm sewer is RCP unless otherwise specified.
4. See Staging Plans for more Drainage Details.

PROFILE	SUBMITTED	DATE
NOTE BOOK	PLOTTED	BY
NO.	GRADES CHECKED	
	STRUCTURE NOTATION CHKD	

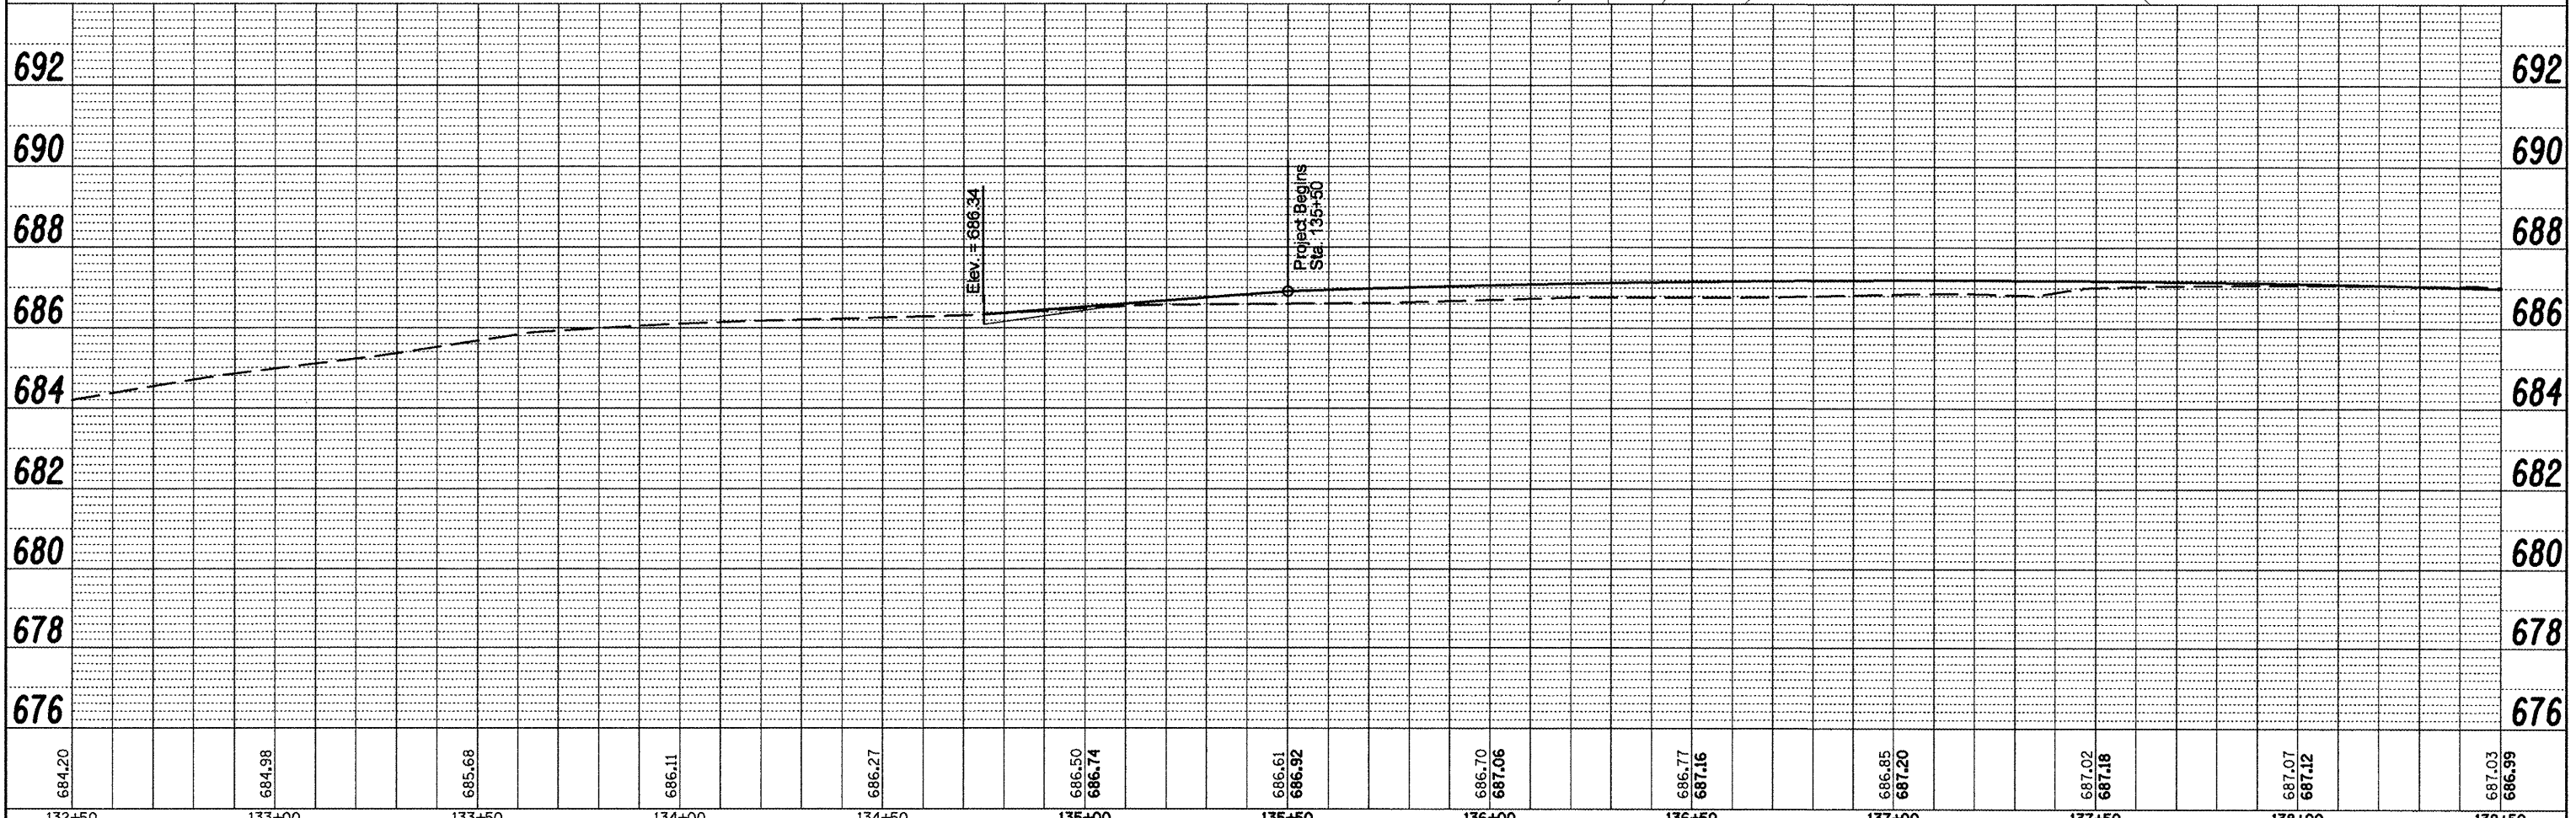

684.20	684.98	685.68	686.11	686.27	686.50 686.74	686.61 686.92	686.70 687.06	686.77 687.16	686.85 687.20	687.02 687.48	687.07 687.42	687.03 686.99
132+50	133+00	133+50	134+00	134+50	135+00	135+50	136+00	136+50	137+00	137+50	138+00	138+50

FILE NAME =
copy of drainage plan r.t.dgn

USER NAME = ewisherdh	DESIGNED -	REVISED -
	DRAWN -	REVISED -
PLOT SCALE = 40.0000' / IN.	CHECKED -	REVISED -
PLOT DATE = 12/11/2008	DATE -	REVISED -

**STATE OF ILLINOIS
DEPARTMENT OF TRANSPORTATION**

IL RTE 8 - DRAINAGE PLANS RT SIDE

SCALE: SHEET NO. OF SHEETS STA. TO STA.

F.A.P. RTE.	SECTION	COUNTY	TOTAL SHEETS	SHEET NO.
399	36 R-8	TAZEWELL	429	112
CONTRACT NO. 68258				

FED. ROAD DIST. NO. 4 ILLINOIS FED. AID PROJECT