


PLAN	DATE
DESIGNED	BY
DRAWN	BY
CHECKED	BY
DATE	
NO.	
FILE NAME	

PROFILE	DATE
DESIGNED	BY
DRAWN	BY
CHECKED	BY
DATE	
NO.	
FILE NAME	

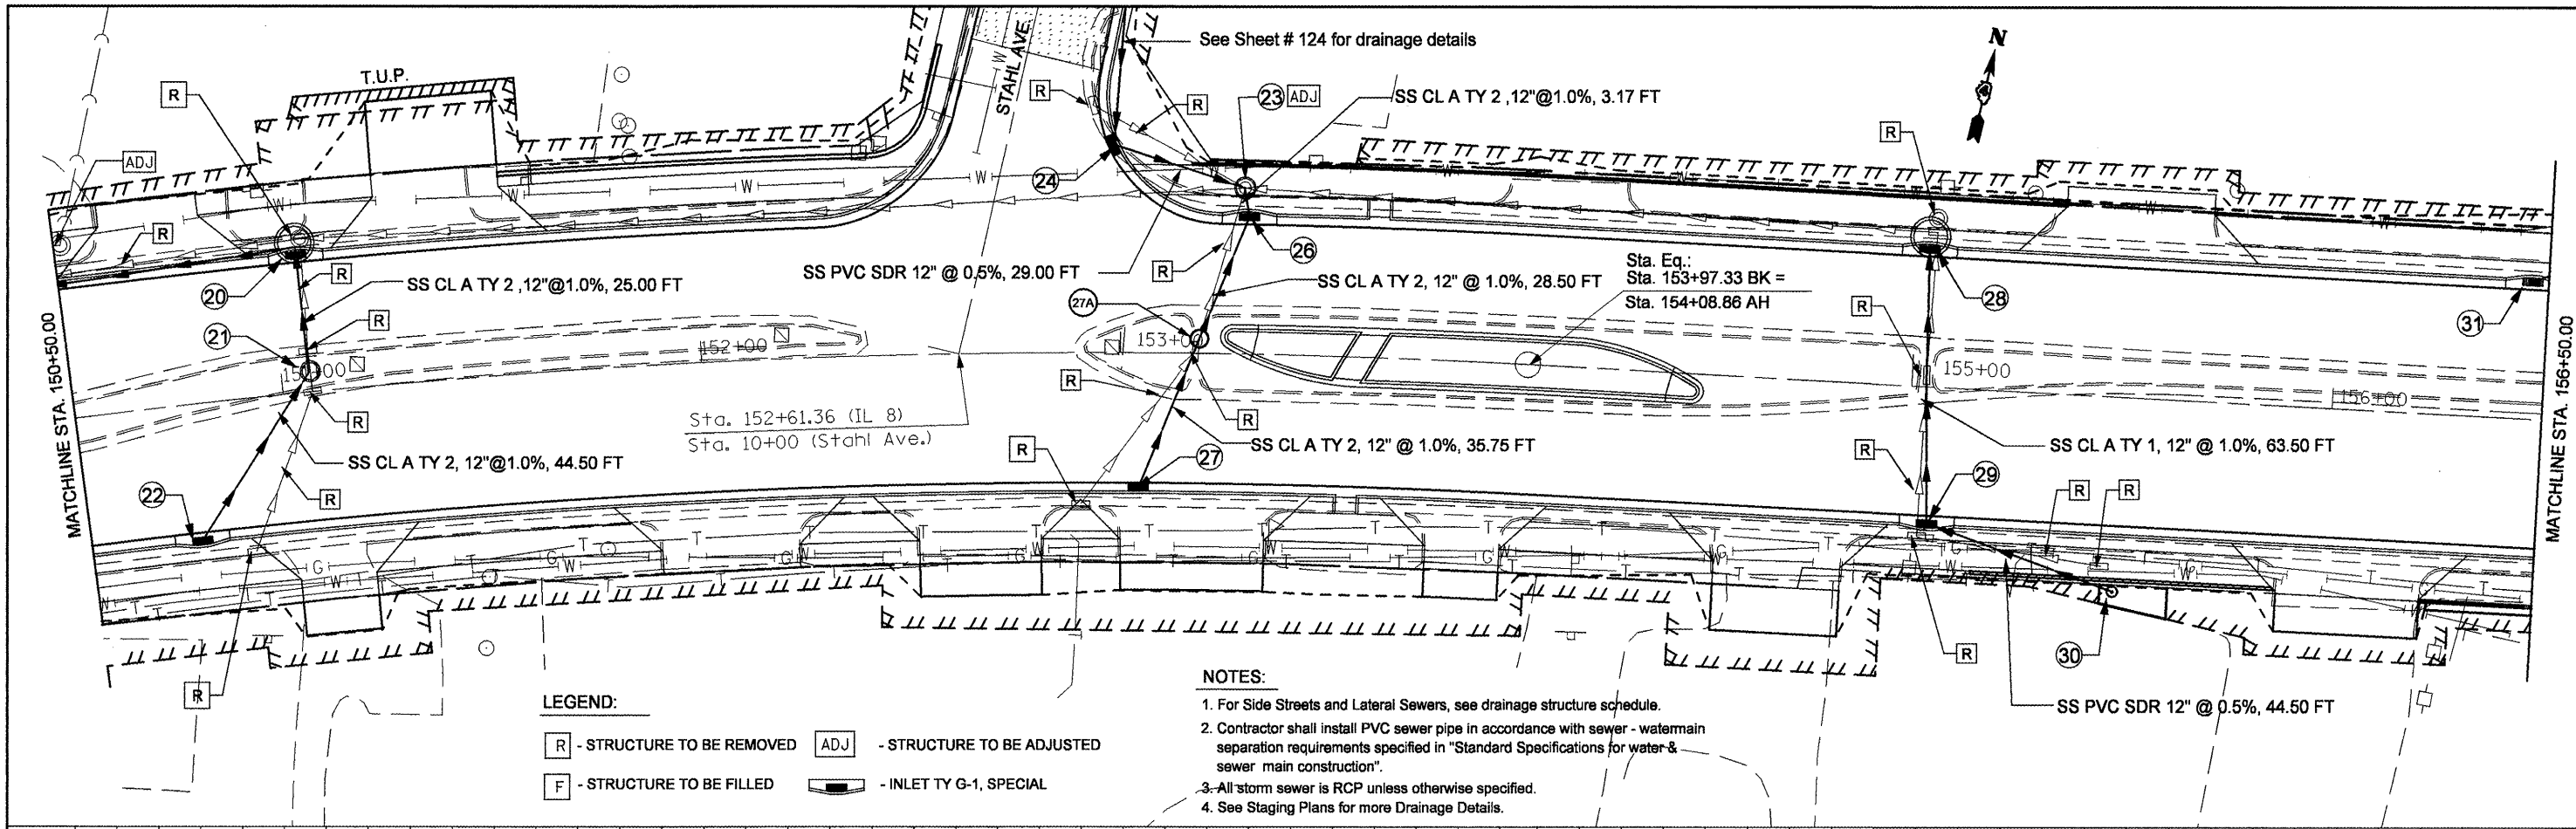


LEGEND:

[R] - STRUCTURE TO BE REMOVED [ADJ] - STRUCTURE TO BE ADJUSTED

[F] - STRUCTURE TO BE FILLED [INLET TY G-1, SPECIAL]

NOTES:

1. For Side Streets and Lateral Sewers, see drainage structure schedule.
2. Contractor shall install PVC sewer pipe in accordance with sewer - watermain separation requirements specified in "Standard Specifications for water & sewer main construction".
3. All storm sewer is RCP unless otherwise specified.
4. See Staging Plans for more Drainage Details.

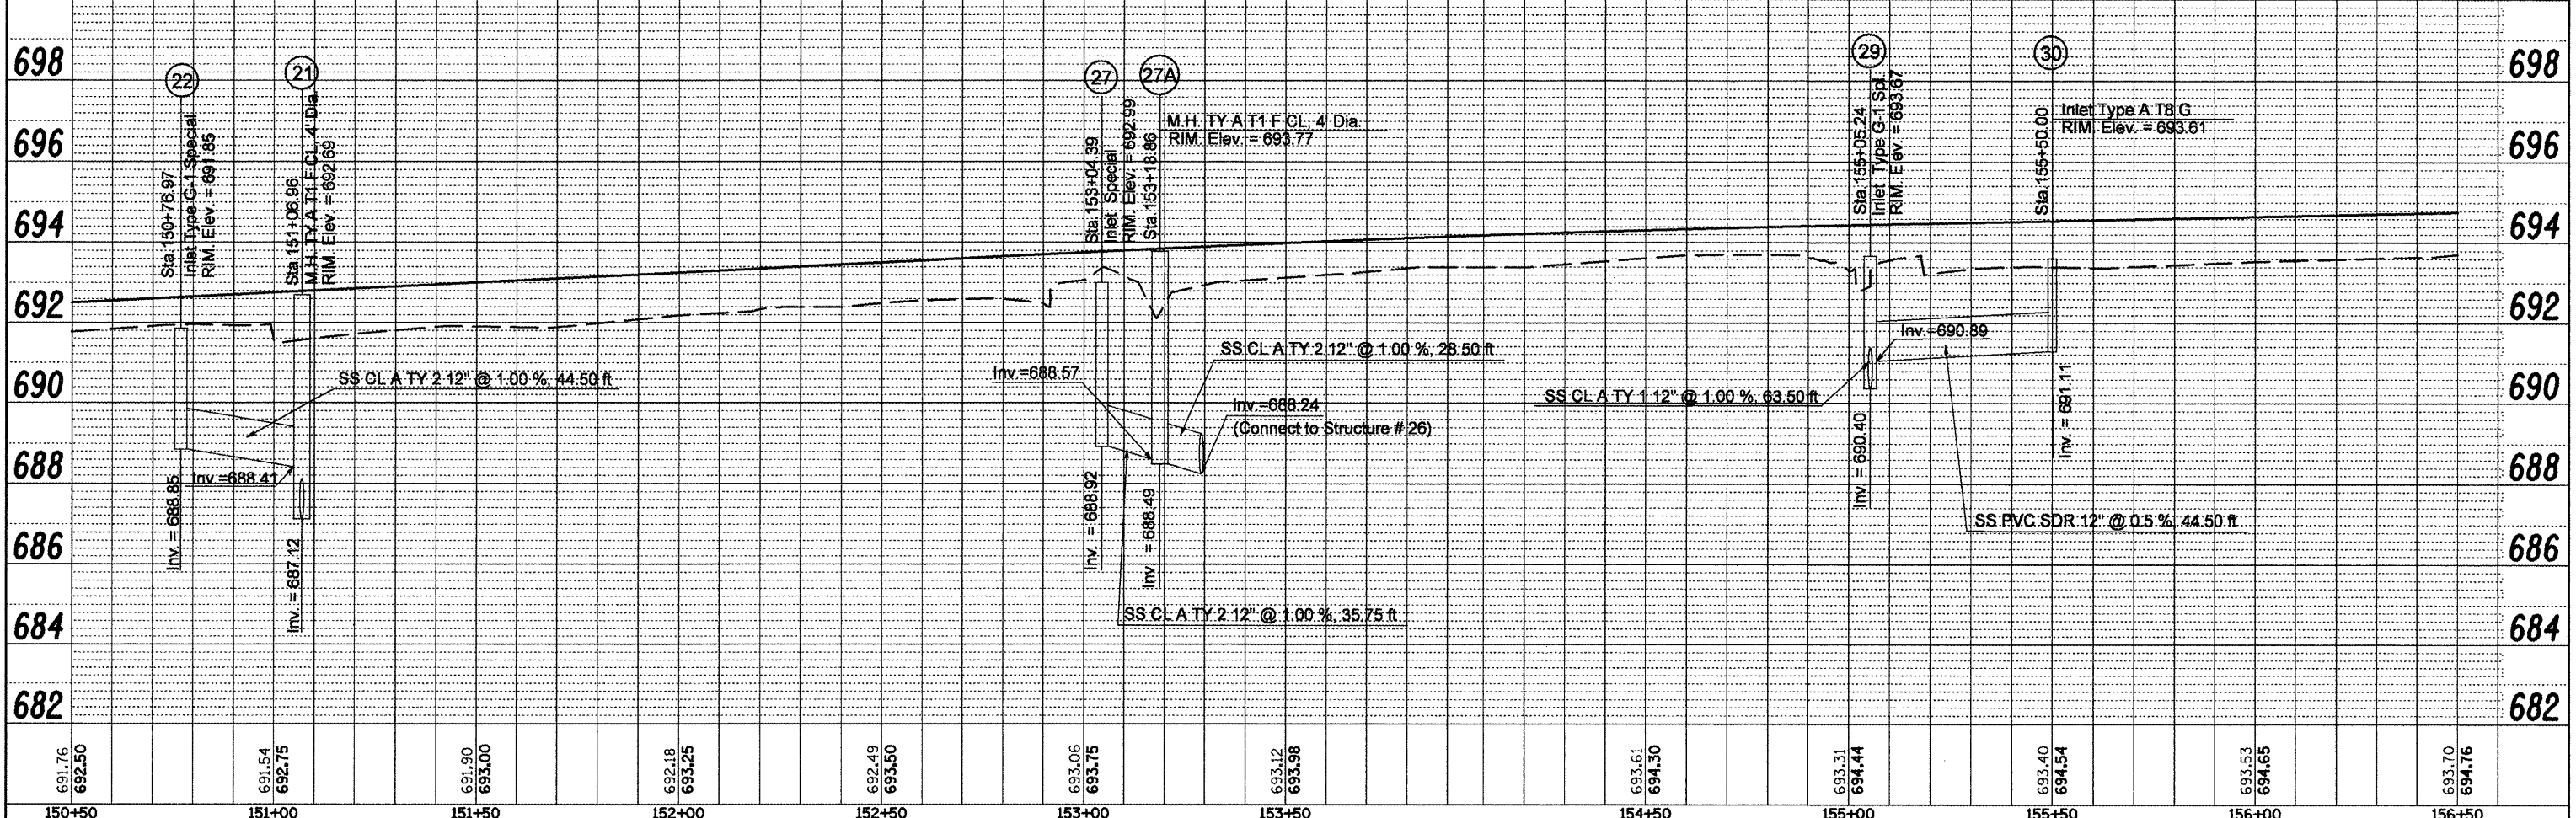

FILE NAME =	USER NAME = crespole	DESIGNED -	REVISED -	STATE OF ILLINOIS DEPARTMENT OF TRANSPORTATION	IL RTE 8 - DRAINAGE PLANS RT SIDE	F.A.P. RTE.	SECTION	COUNTY	TOTAL SHEETS	SHEET NO.	
copy of drainage plan r.t.dgn		DRAWN -	REVISED -			399	36 R-8	TAZEWELL	429	115	
		CHECKED -	REVISED -			CONTRACT NO. 68258					
		DATE -	REVISED -			SCALE:	SHEET NO.	OF	SHEETS	STA.	TO STA.