 


LEGEND

- NEW PAVEMENT
- BITUMINOUS PAVEMENT REMOVAL
- NEW MANHOLE/INLET
- NEW STORM SEWER
- NEW UNDERDRAIN
- NEW SANITARY SEWER
- NEW WATERMAIN
- NEW VALVE AND VAULT
- NEW FIRE HYDRANT
- EXISTING MANHOLE/INLET
- EXISTING STORM SEWER
- EXISTING SANITARY SEWER
- EXISTING END SECTION
- EXISTING UNDERDRAIN CLEANOUT
- EXISTING UNDERDRAIN
- EXISTING WATERMAIN




PA050


K:\Palwaukee\062907 Extend Txy L\Draw\Sheets\FILE: txy-geo-1.dwg
 LAYOUT: Layout1
 UPDATE BY: mkatz
 SURVEY BOOK #
 DATE: Fri 11/14/08 1:24pm
 XREF DWG: hbcint.dwg
 tb.dwg
 taxiway-base.dwg

REVISIONS

NUMBER	BY	DATE

 

SEE PLAN AND PROFILE TAXIWAY L SHEET 11 FOR NOTES

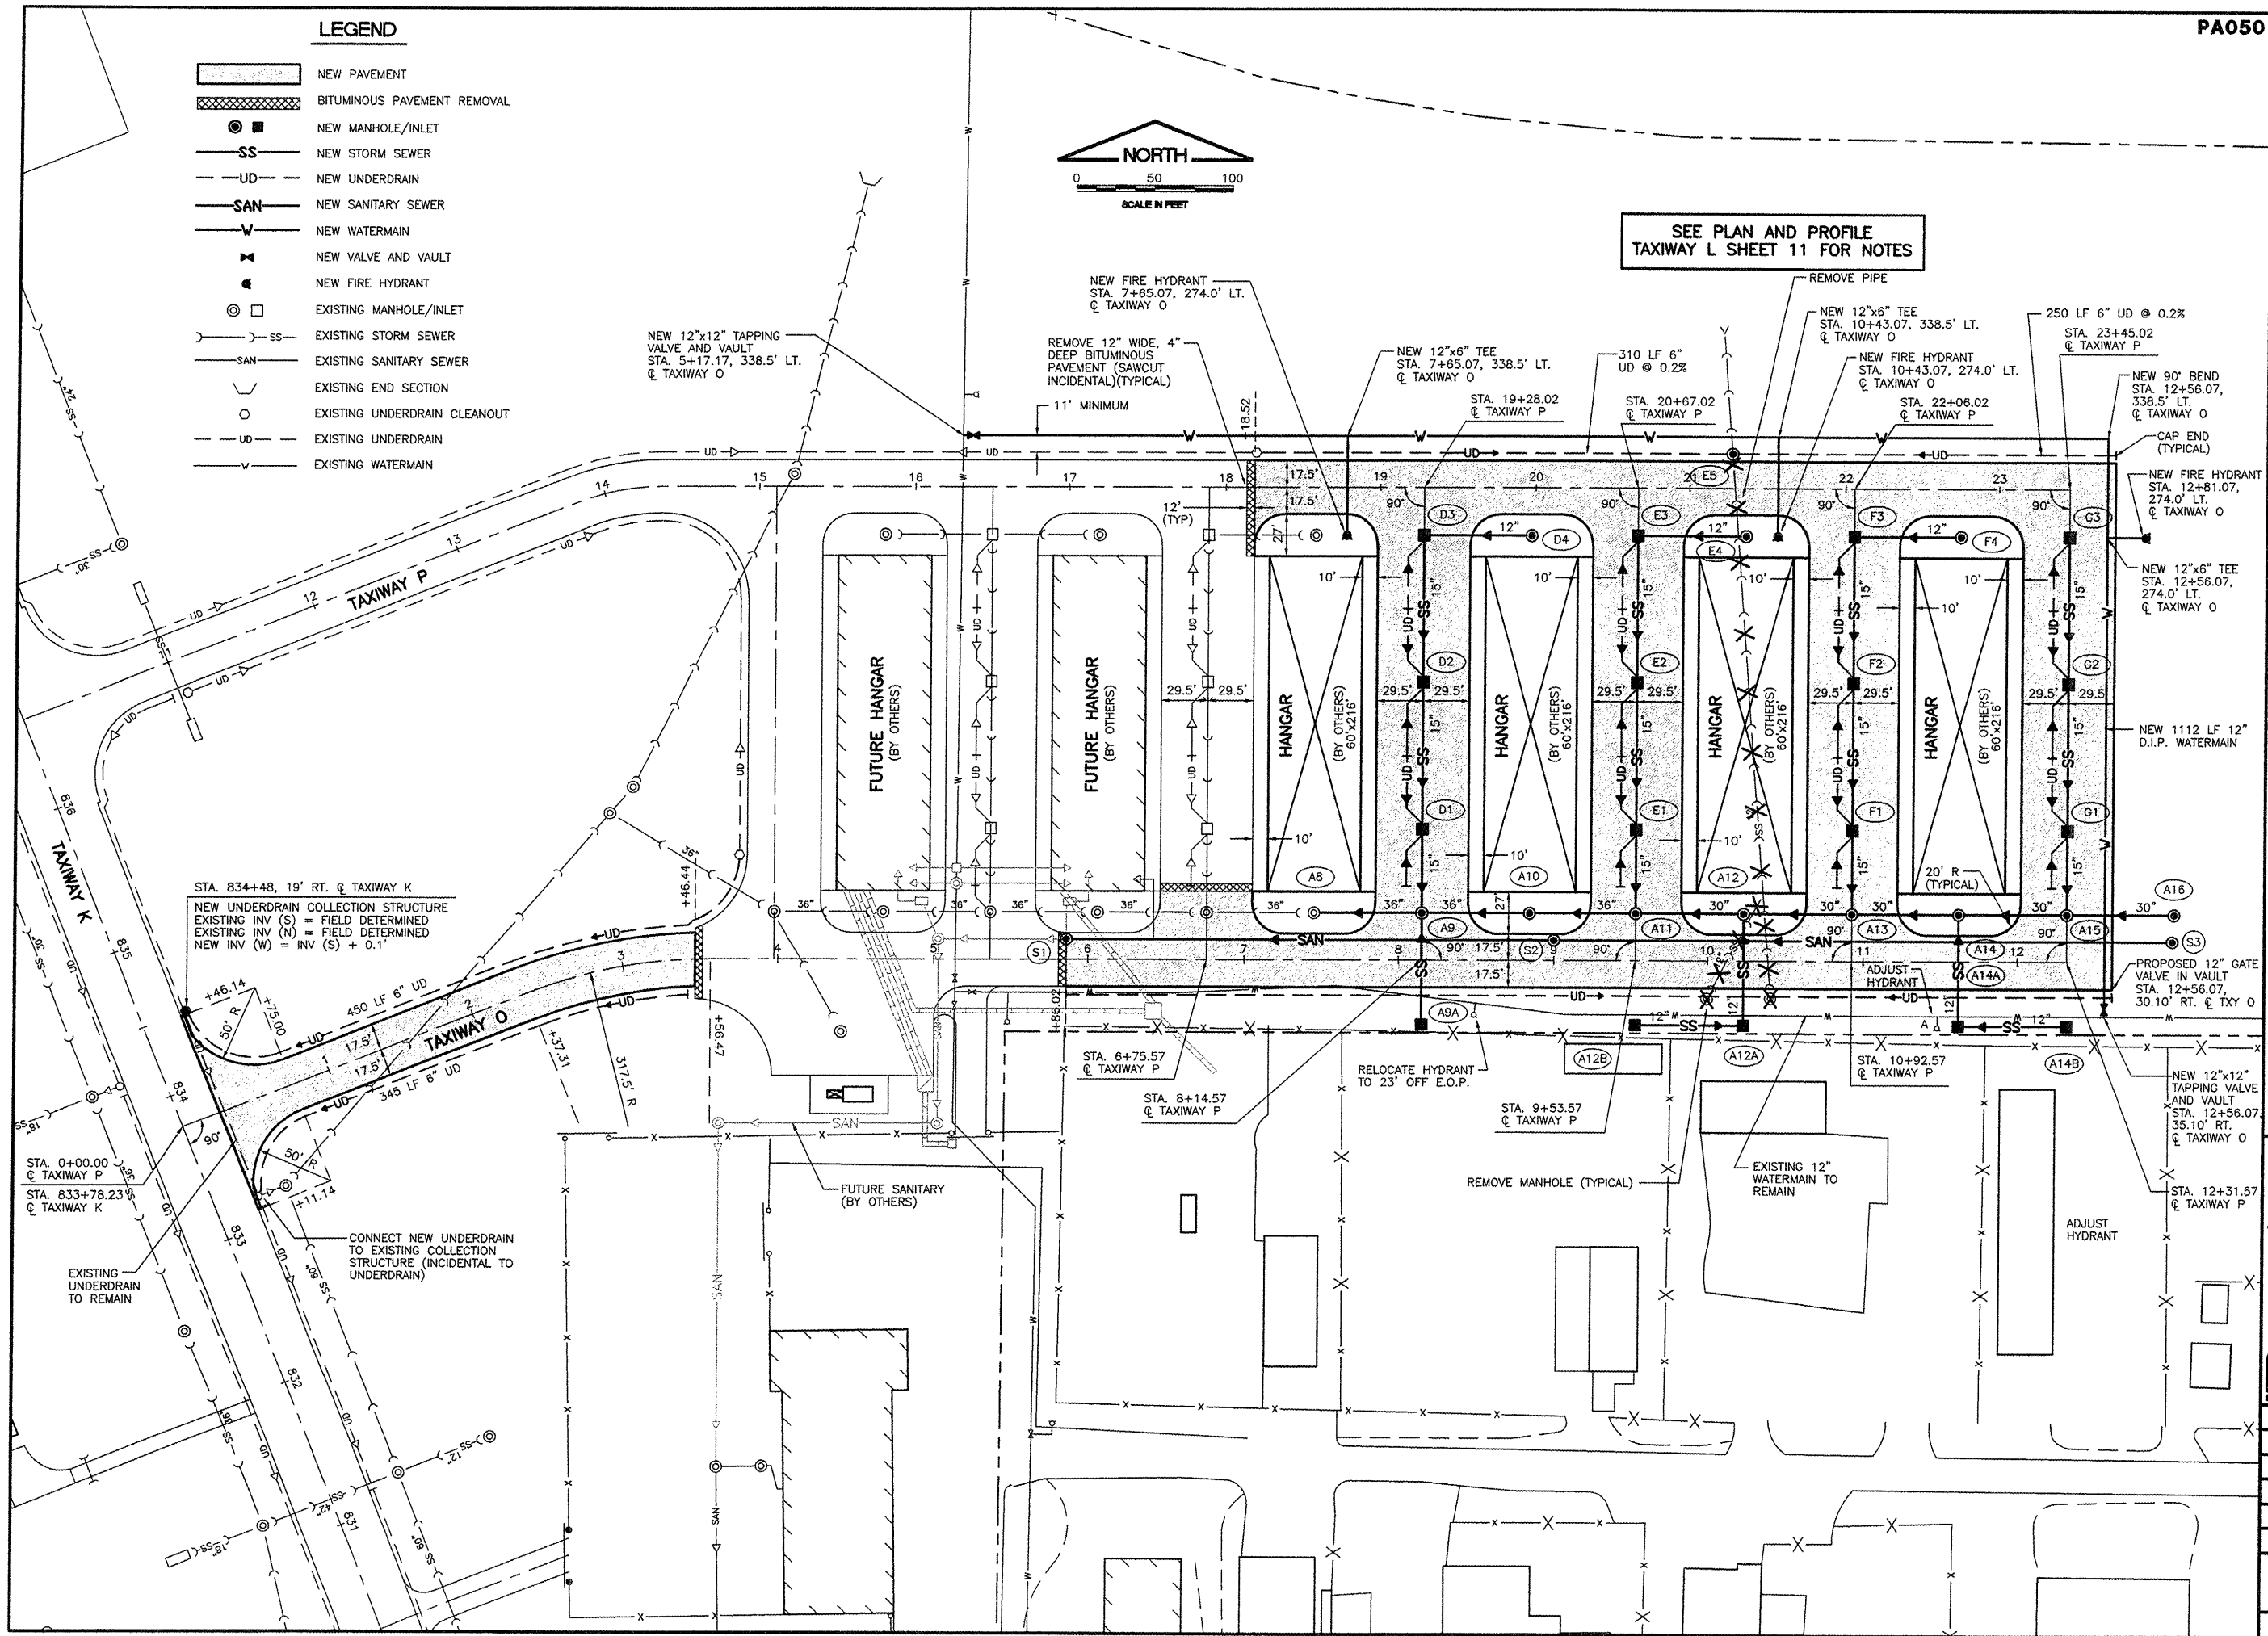

CHICAGO EXECUTIVE AIRPORT
WHEELING/PROSPECT HEIGHTS, ILLINOIS

GEOMETRIC, SEWER AND WATERMAIN PLAN
NORTHEAST QUADRANT

CMT
 CRAWFORD, MURPHY & TILLY, INC.
 CONSULTING ENGINEERS
 License No. 084-000613

CHICAGO EXECUTIVE AIRPORT

DESIGN BY: MJS
 DRAWN BY: JRO
 CHECKED BY:
 APPROVED BY:
 DATE: 11/21/08
 JOB No: 06290-07
 ILLINOIS PROJECT: PWK-3613
 A.I.P. PROJECT: 3-17-0018-B39
 SHEET 14 OF 40 SHEETS