



| | | | | |
|---------------------|---------|---------------------------|--------------|-----------|
| F.A. RTE. | SECTION | COUNTY | TOTAL SHEETS | SHEET NO. |
| 308 | | ROCK ISLAND | 210 | 205 |
| STA. | | TO STA. | | |
| FED. ROAD DIST. NO. | | ILLINOIS FED. AID PROJECT | | |

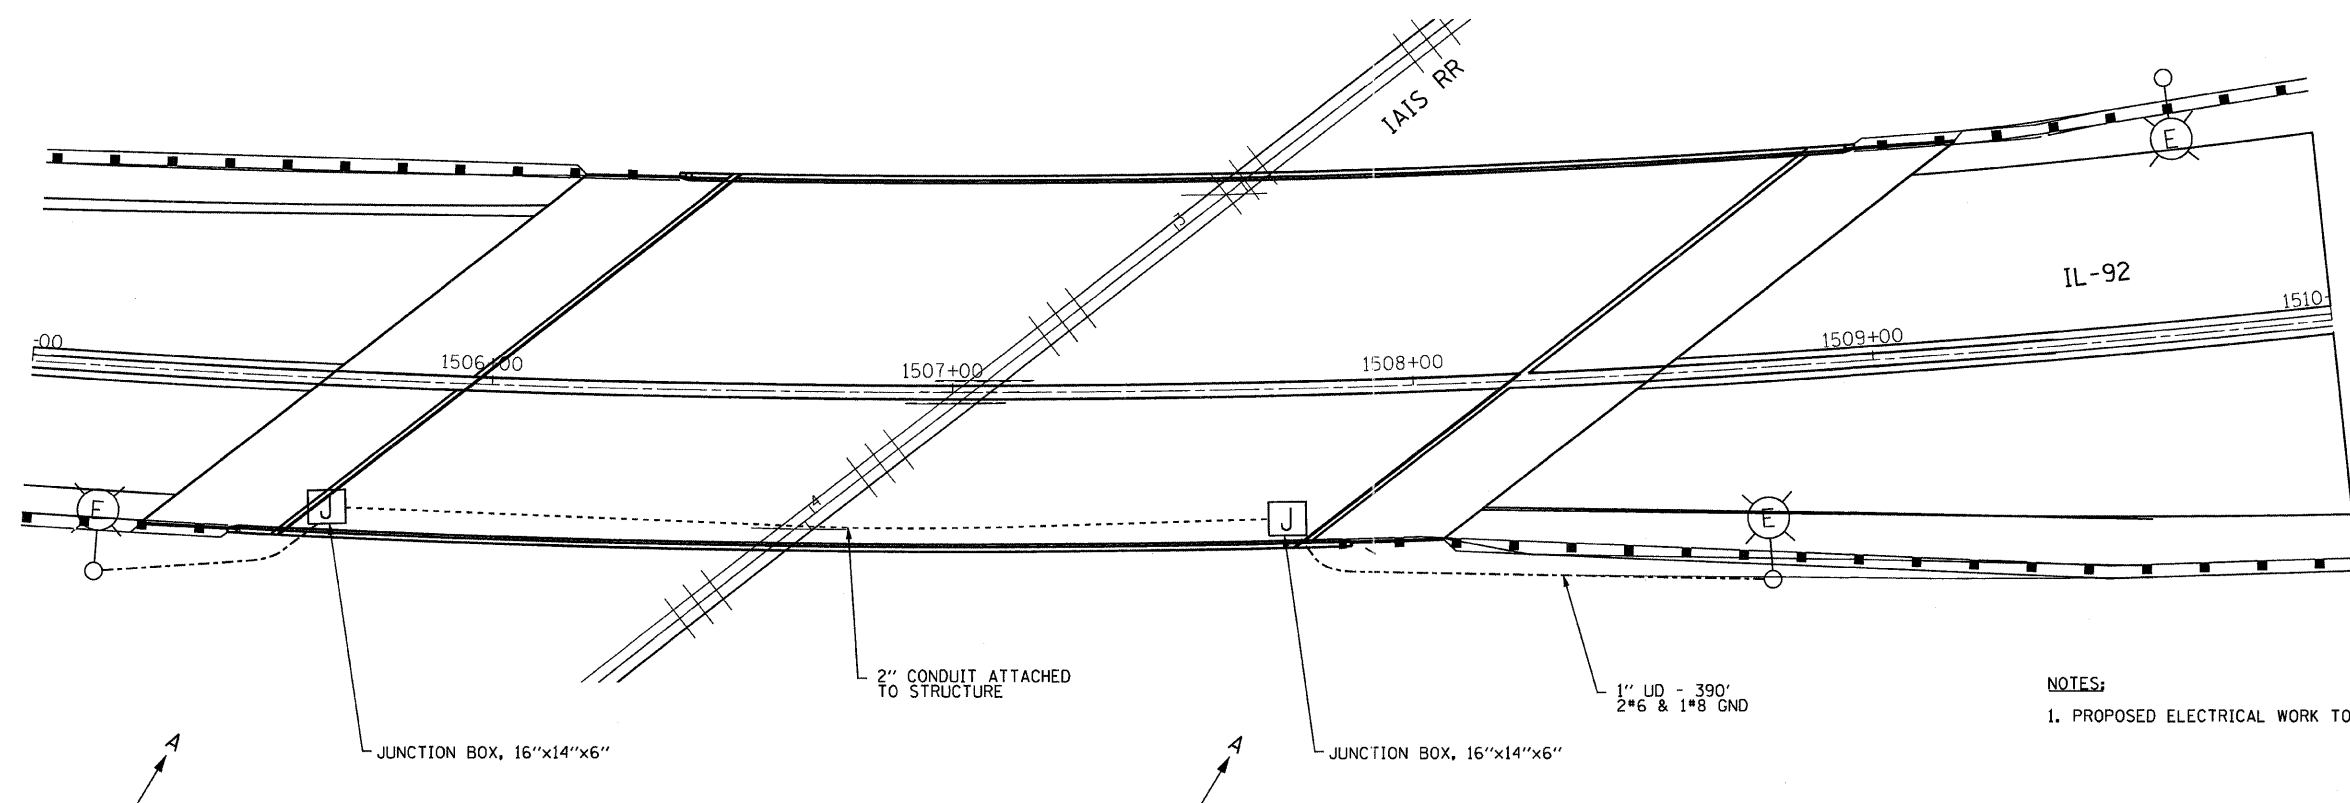


NOTES:
1. PROPOSED ELECTRICAL WORK TO BE DONE DURING STAGE 3.

PLAN
1" = 20'

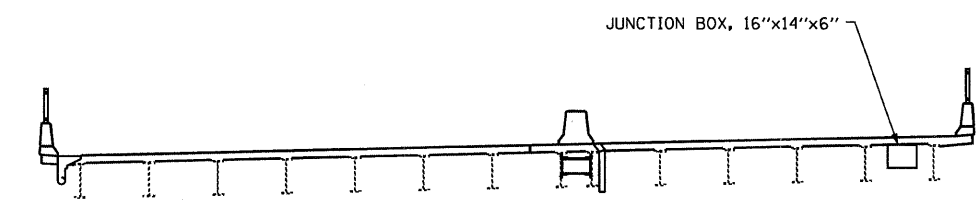

SECTION THROUGH BRIDGE
LOOKING NORTH
NOT TO SCALE

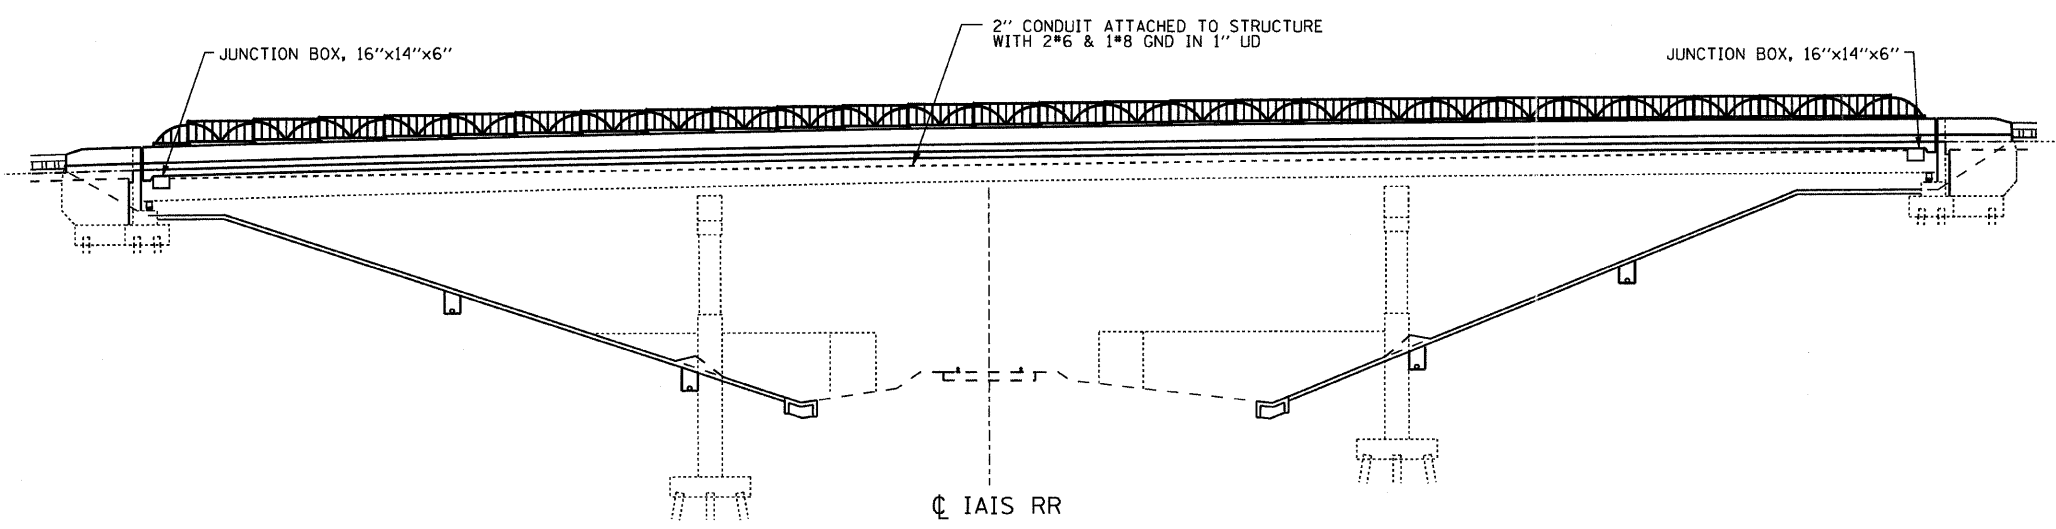

SECTION A-A
LOOKING WEST
NOT TO SCALE

EJM EJM ENGINEERING, INC.
411 South Wells Street Suite 800
Chicago, Illinois 60607

| REVISIONS | |
|-----------|------|
| NAME | DATE |
| | |
| | |
ILLINOIS DEPARTMENT OF TRANSPORTATION
ILLINOIS ROUTE 92

PROPOSED ELECTRICAL PLAN
IAIS RAILROAD

SCALE: 1"=20'
DATE: 11/26/07

DRAWN BY: JDM
CHECKED BY: JH

PLOT DATE * DATES
FILE NAME * FILEL
USER NAME * USERB