


F.A.I. RTE.	SECTION	COUNTY	TOTAL SHEETS	SHEET NO.
270	60-(1,2)L-1	MADISON	31	8
STA.		TO STA.		
FED. ROAD DIST. NO.		ILLINOIS FED. AID PROJECT		

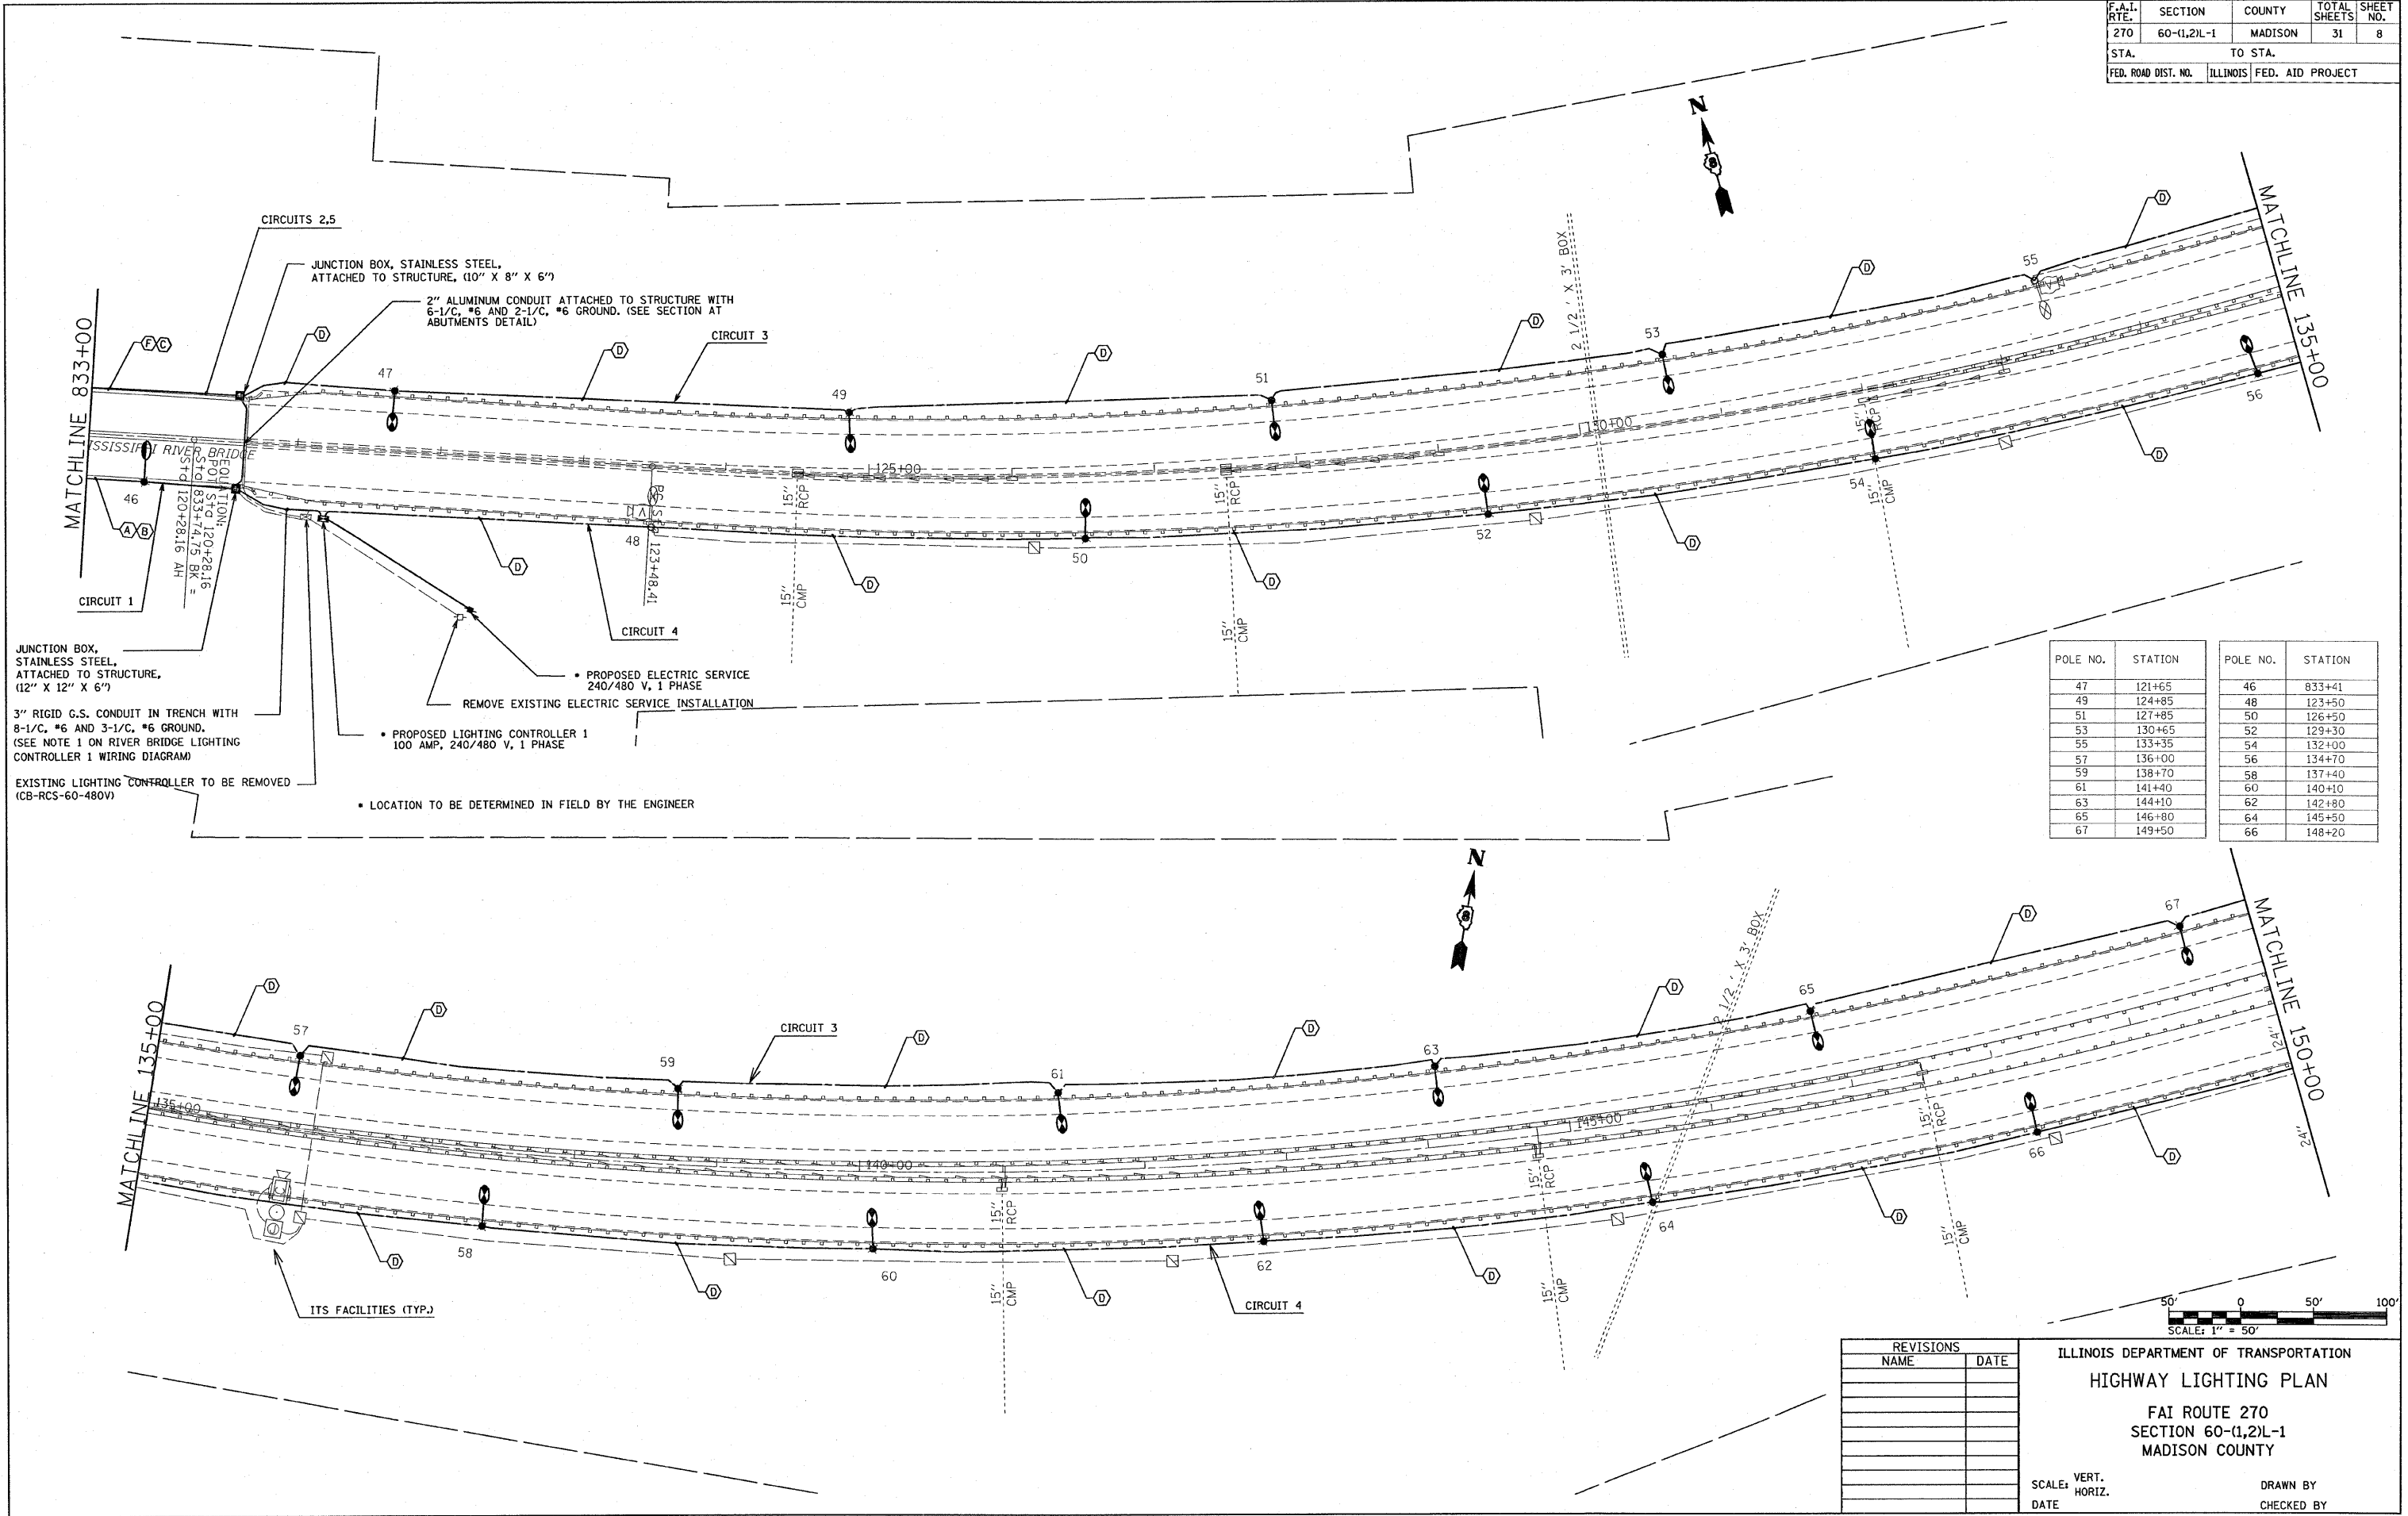

POLE NO.	STATION	POLE NO.	STATION
47	121+65	46	833+41
49	124+85	48	123+50
51	127+85	50	126+50
53	130+65	52	129+30
55	133+35	54	132+00
57	136+00	56	134+70
59	138+70	58	137+40
61	141+40	60	140+10
63	144+10	62	142+80
65	146+80	64	145+50
67	149+50	66	148+20

REVISIONS	
NAME	DATE

ILLINOIS DEPARTMENT OF TRANSPORTATION
HIGHWAY LIGHTING PLAN
 FAI ROUTE 270
 SECTION 60-(1,2)L-1
 MADISON COUNTY

SCALE: VERT. _____
 HORIZ. _____
 DATE _____

DRAWN BY _____
 CHECKED BY _____

* DATE *
 * PLOT *
 * SCALE *
 * REFERENCE *