



F.A.I. RTE.	SECTION	COUNTY	TOTAL SHEETS	SHEET NO.
270	60-(1,2)L-1	MADISON	31	9
STA.		TO STA.		
FED. ROAD DIST. NO.	ILLINOIS	FED. AID PROJECT		

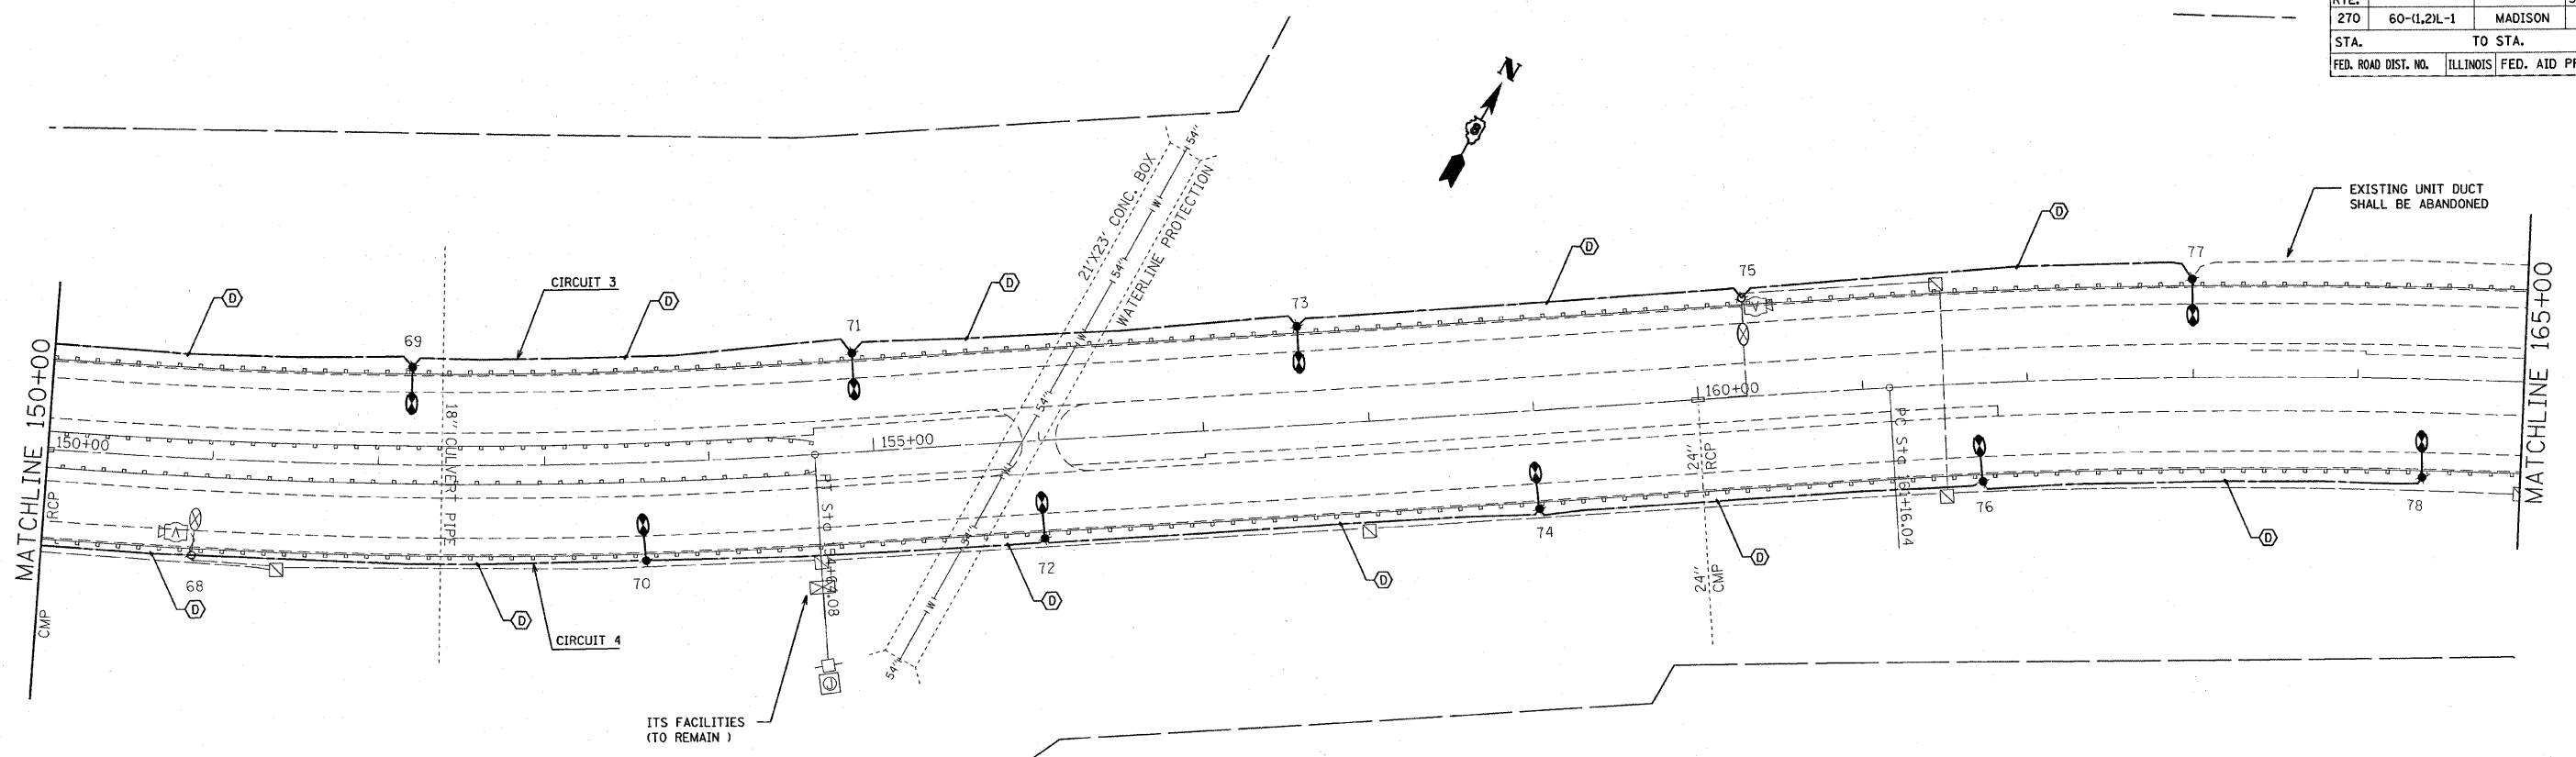

POLE NO.	STATION	POLE NO.	STATION
69	152.20	68	150+90
71	154+90	70	153+60
73	157+60	72	156+30
75	160+30	74	159+00
77	163+00	76	161+70
79	168+70	78	164+40
81	168+40	80	167+10
83	171+10	82	169+80
85	173+80	84	172+50
C87	176+50	C86	175+20
C89	179+20	C88	178+00

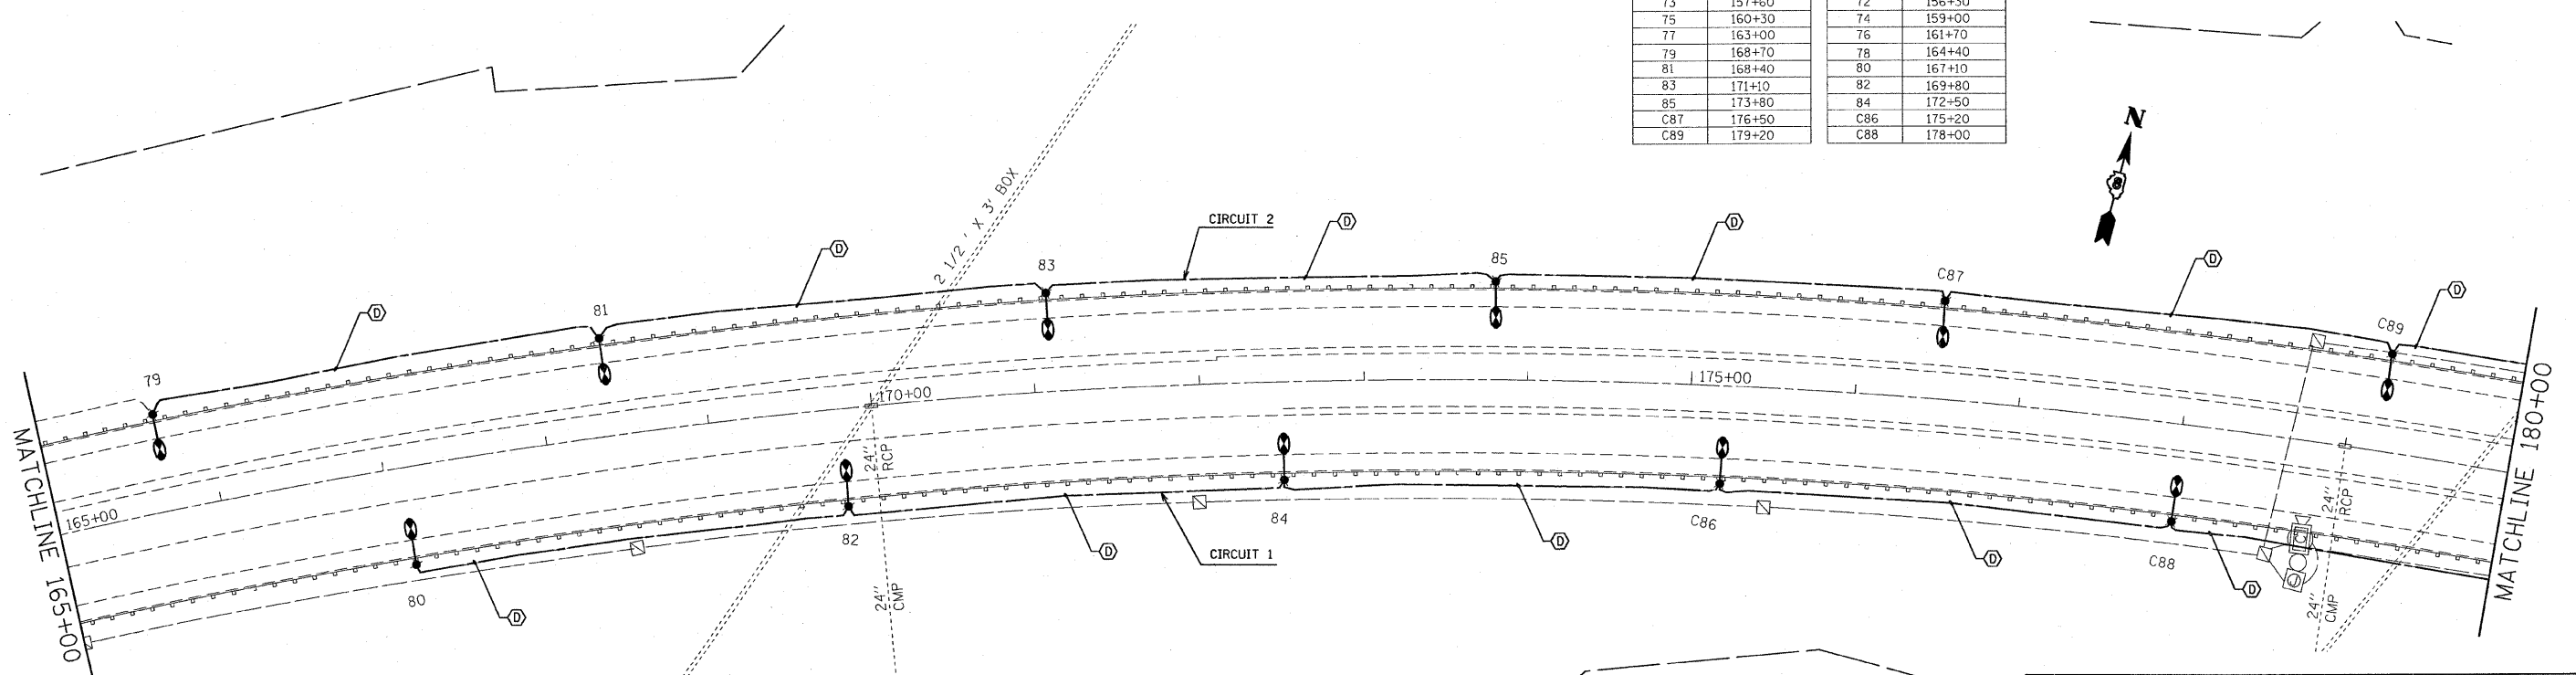

DATE
 SCALE
 REF



REVISIONS	
NAME	DATE

ILLINOIS DEPARTMENT OF TRANSPORTATION
 HIGHWAY LIGHTING PLAN
 FAI ROUTE 270
 SECTION 60-(1,2)L-1
 MADISON COUNTY
 SCALE: VERT. _____
 HORIZ. _____
 DATE _____
 DRAWN BY _____
 CHECKED BY _____