


FILE NO.	SECTION	COUNTY	TOTAL SHEETS	SHEET NO.
1380	00-00084-00-FV	DUPAGE	93	53
STA. 193+00		TO STA. 198+00		
ALIGN		SURFACE TRANSPORTATION FUNDING		

CONTRACT NUMBER 83993

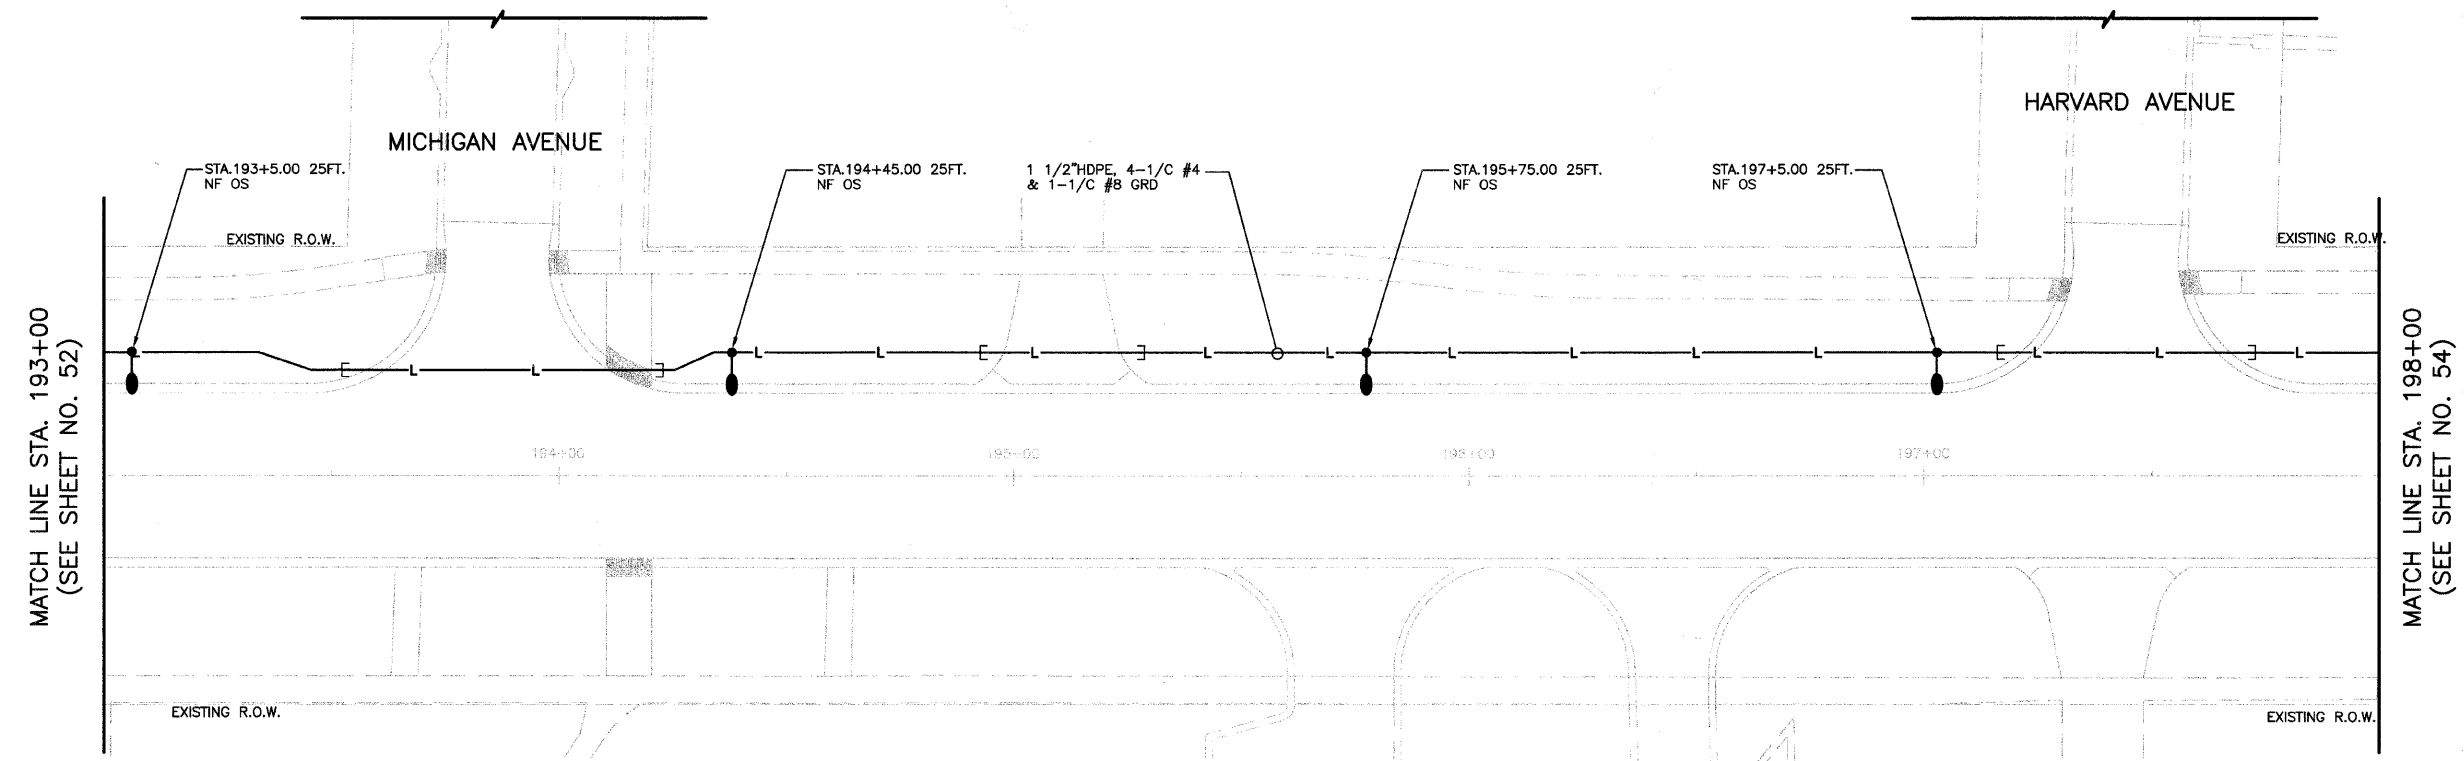

MATCH LINE STA. 193+00
(SEE SHEET NO. 52)

MATCH LINE STA. 198+00
(SEE SHEET NO. 54)

NOTE: ALL POLES MARKED "NF" REQUIRE NON-FRANGIBLE MOUNTING.
ALL POLES MARKED AS "OS" REQUIRE OFFSET FOUNDATION.

REVISIONS	
NAME	DATE

VILLAGE OF ADDISON

LIGHTING PLAN

FULLERTON AVENUE

STA. 193+00 TO 198+00

DATE: 11/26/2007
DESIGNED BY: FEJ
TECHNICIAN: FEJ
CHECKED BY: DEM

20 0 20 HORIZ.
5 5 VERT.
SCALE IN FEET