


FILE NO.	SECTION	COUNTY	TOTAL SHEETS	SHEET NO.
1380	00-00084-00-PV	DUPAGE	93	54
STA. 198+00		TO STA. 203+50		
ALIGN		SURFACE TRANSPORTATION FUNDING		

CONTRACT NUMBER 83993

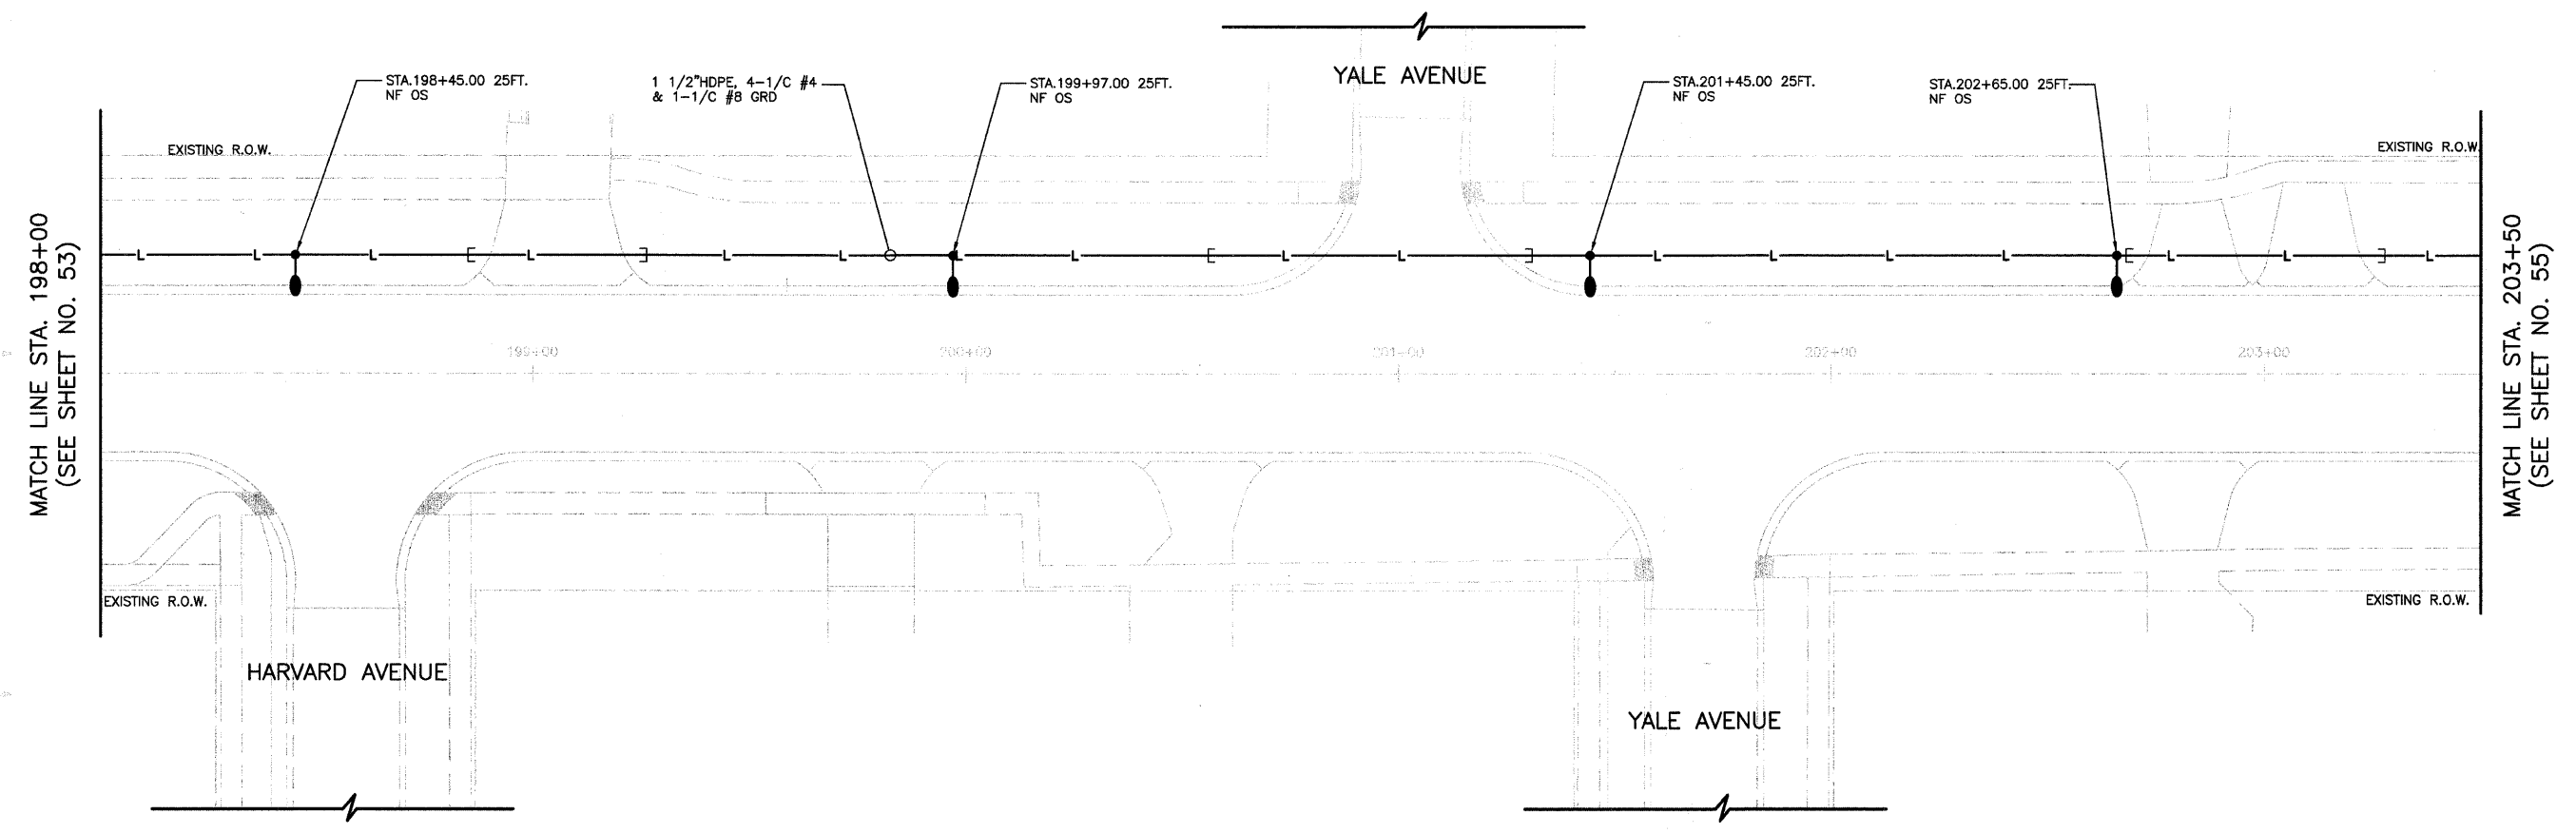

NOTE: ALL POLES MARKED "NF" REQUIRE NON-FRANGIBLE MOUNTING.
ALL POLES MARKED AS "OS" REQUIRE OFFSET FOUNDATION.

REVISIONS	
NAME	DATE

VILLAGE OF ADDISON

LIGHTING PLAN

FULLERTON AVENUE

STA. 198+00 TO 203+50

DATE: 11/26/2007
DESIGNED BY: FEJ
TECHNICIAN: FEJ
CHECKED BY: DEM

SCALE IN FEET: 20 HORIZ. / 5 VERT.