


FILE NO.	SECTION	COUNTY	TOTAL SHEETS	SHEET NO.
1380	00-00084-00-PV	DUPAGE	93	56
STA. 209+00		TO STA. 214+50		
ALIGN		SURFACE TRANSPORTATION FUNDING		

CONTRACT NUMBER 83993

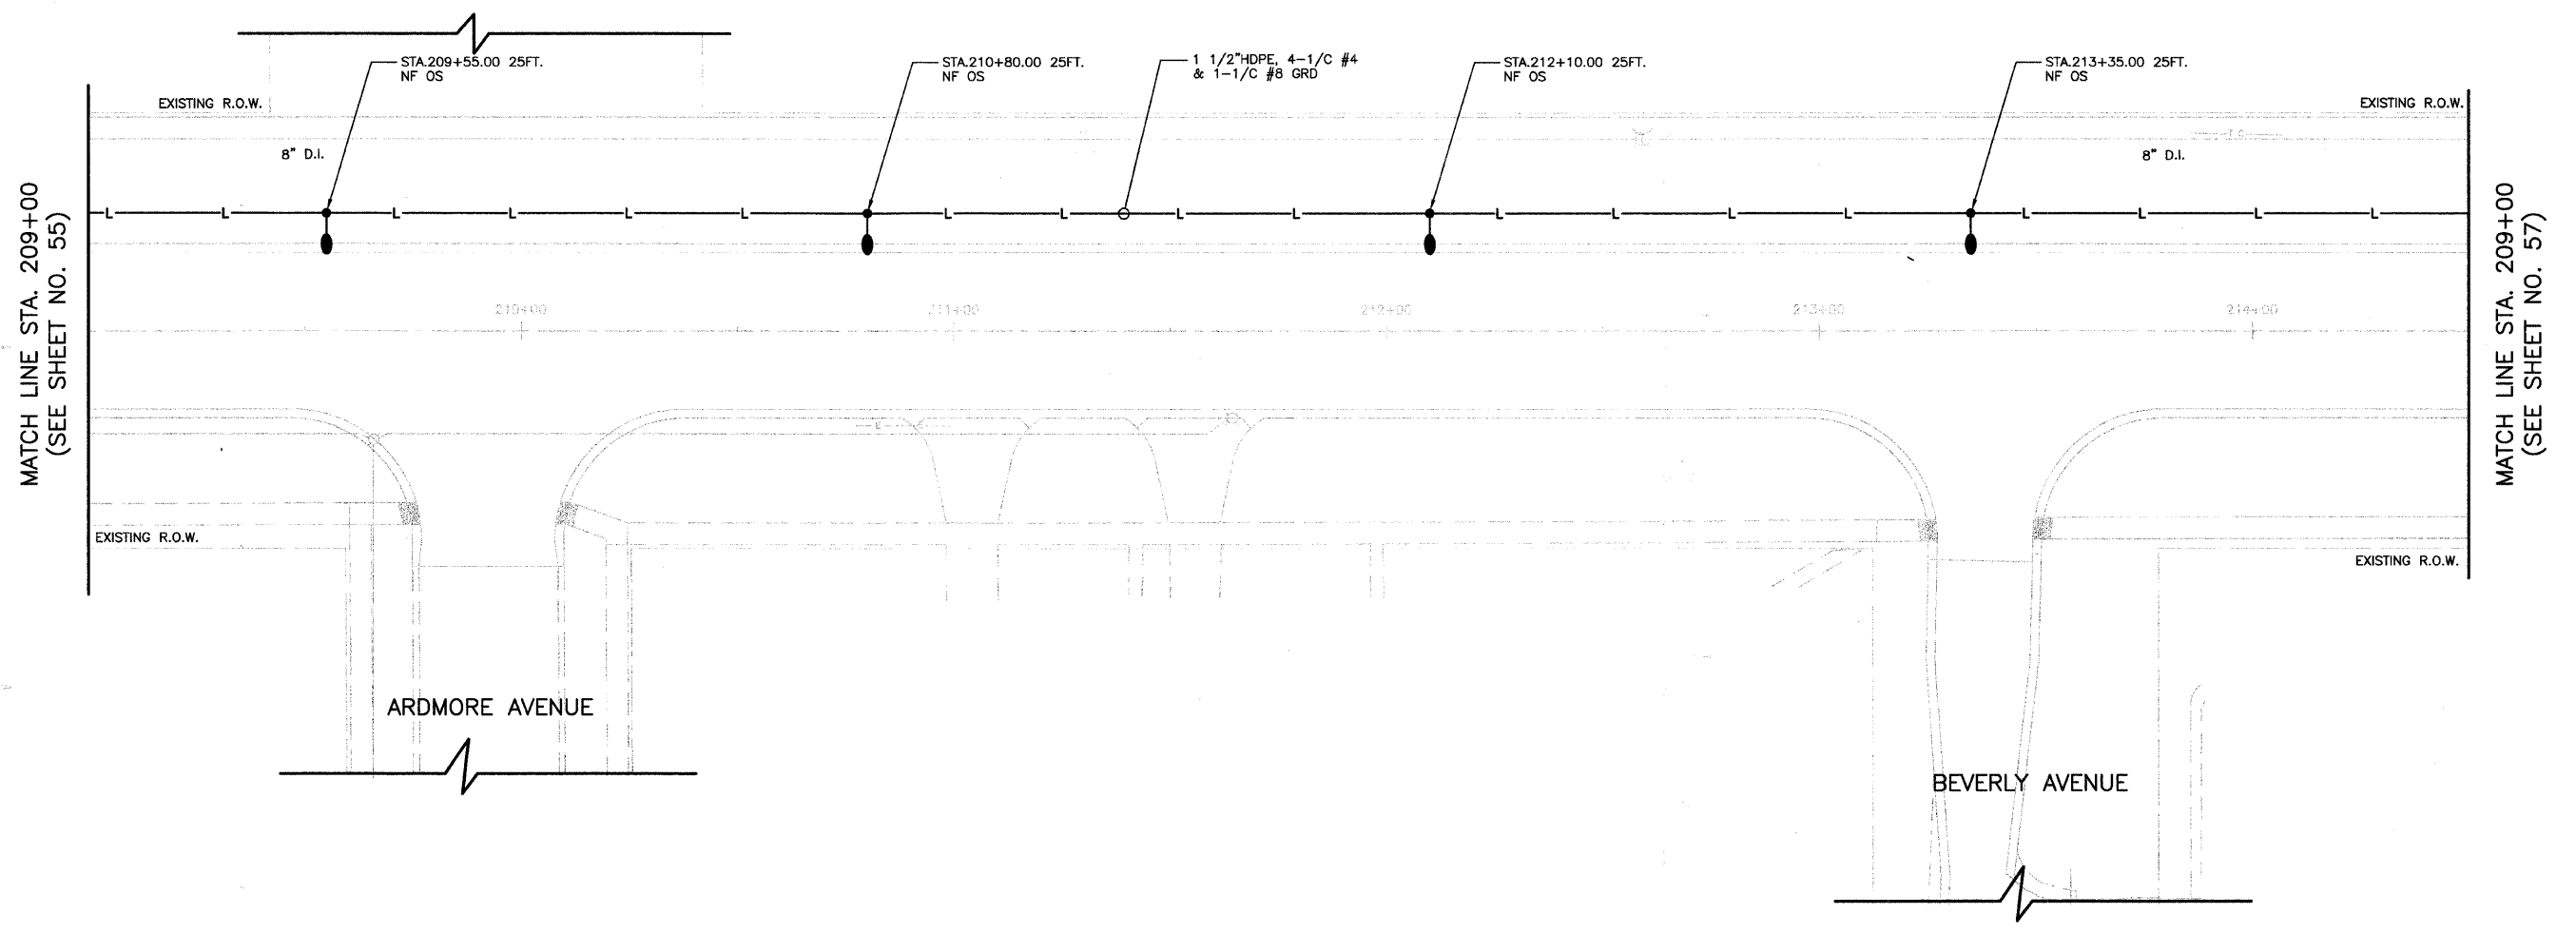

NOTE: ALL POLES MARKED "NF" REQUIRE NON-FRANGIBLE MOUNTING.
ALL POLES MARKED AS "OS" REQUIRE OFFSET FOUNDATION.

REVISIONS	
NAME	DATE

VILLAGE OF ADDISON

LIGHTING PLAN

FULLERTON AVENUE
STA. 209+00 TO 214+50

DATE: 11/26/2007
DESIGNED BY: FEI
TECHNICIAN: FEI
CHECKED BY: DEM

20 0 20 HORIZ.
5 5 VERT.
SCALE IN FEET