


FILE NO.	SECTION	COUNTY	TOTAL SHEETS	SHEET NO.
1380	00-00084-00-PV	DUPAGE	93	59
STA. 514+00		TO STA. 517+00		
ELBOW		SURFACE TRANSPORTATION FUNDING		

CONTRACT NUMBER 83993

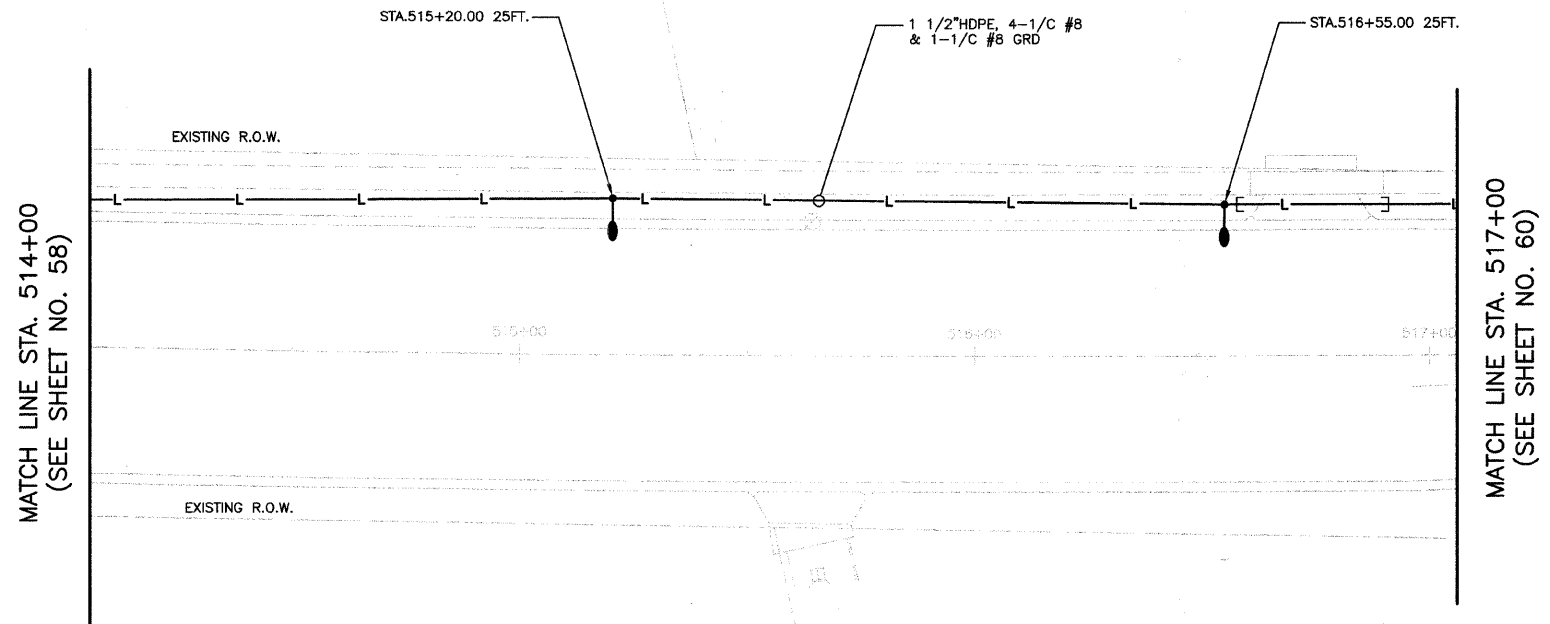

NOTE: ALL POLES MARKED "NF" REQUIRE NON-FRANGIBLE MOUNTING.  
ALL POLES MARKED AS "OS" REQUIRE OFFSET FOUNDATION.

REVISIONS	
NAME	DATE

VILLAGE OF ADDISON  
**LIGHTING PLAN**  
 VILLA AVENUE  
 STA. 514+00 TO 517+00

DATE: 11/26/2007  
 DESIGNED BY: FEJ  
 TECHNICIAN: FEJ  
 CHECKED BY: DEM

20 0 20 HORIZ.  
 5 5 VERT.  
 SCALE IN FEET