
 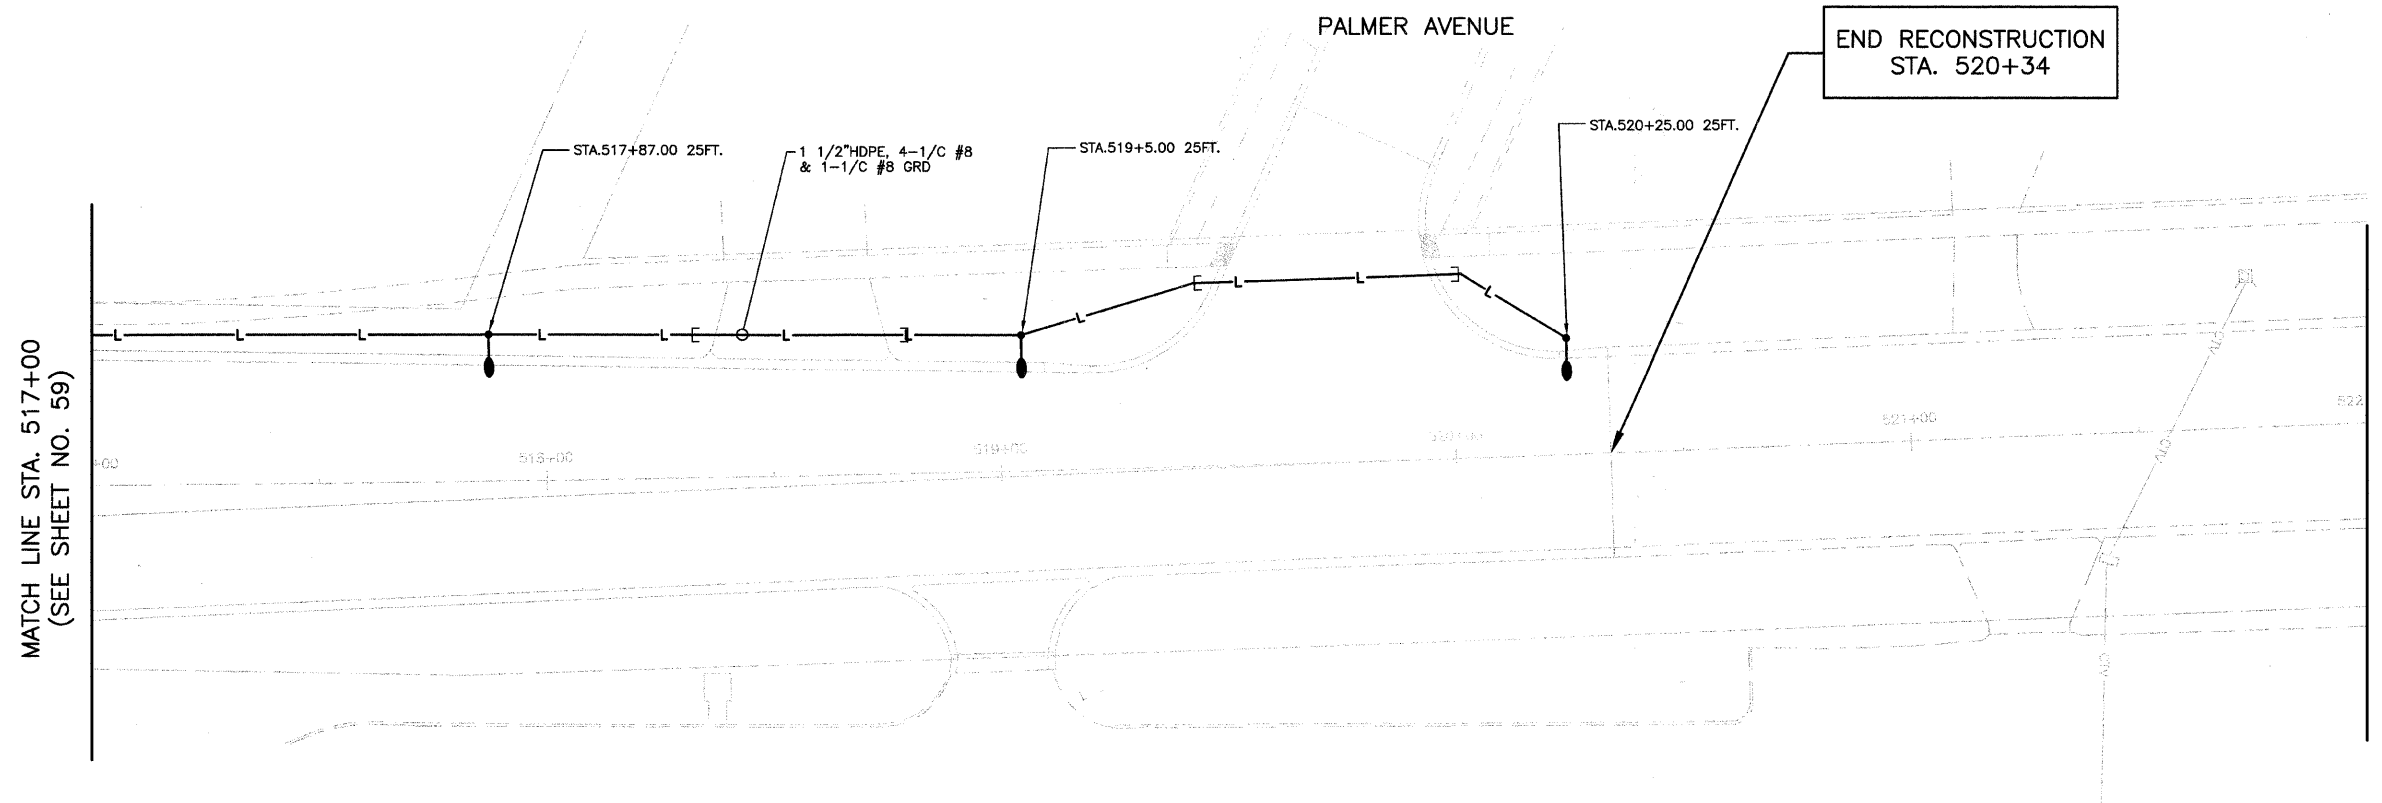


FILE NO.	SECTION	COUNTY	TOTAL SHEETS	SHEET NO.
1380	00-00084-00-PV	DUPAGE	93	60
STA.	FIRST STA.	TO STA.	SECOND STA.	

CONTRACT NUMBER 83993



NOTE: ALL POLES MARKED "NF" REQUIRE NON-FRANGIBLE MOUNTING.
ALL POLES MARKED AS "OS" REQUIRE OFFSET FOUNDATION.

REVISIONS	
NAME	DATE

VILLAGE OF ADDISON

LIGHTING PLAN

VILLA AVENUE

STA. 517+00 TO 520+34

DATE: 11/26/2007
DESIGNED BY: FEI
TECHNICIAN: FEI
CHECKED BY: DEM

20 0 20 HORIZ.
5 5 VERT.
SCALE IN FEET