


FILE NO.	SECTION	COUNTY	TOTAL SHEETS	SHEET NO.
1380	00-00084-00-PV	DUPAGE	93	61
STA.		TO STA.		
ELMS		SURFACE TRANSPORTATION FUNDING		

CONTRACT NUMBER 83993

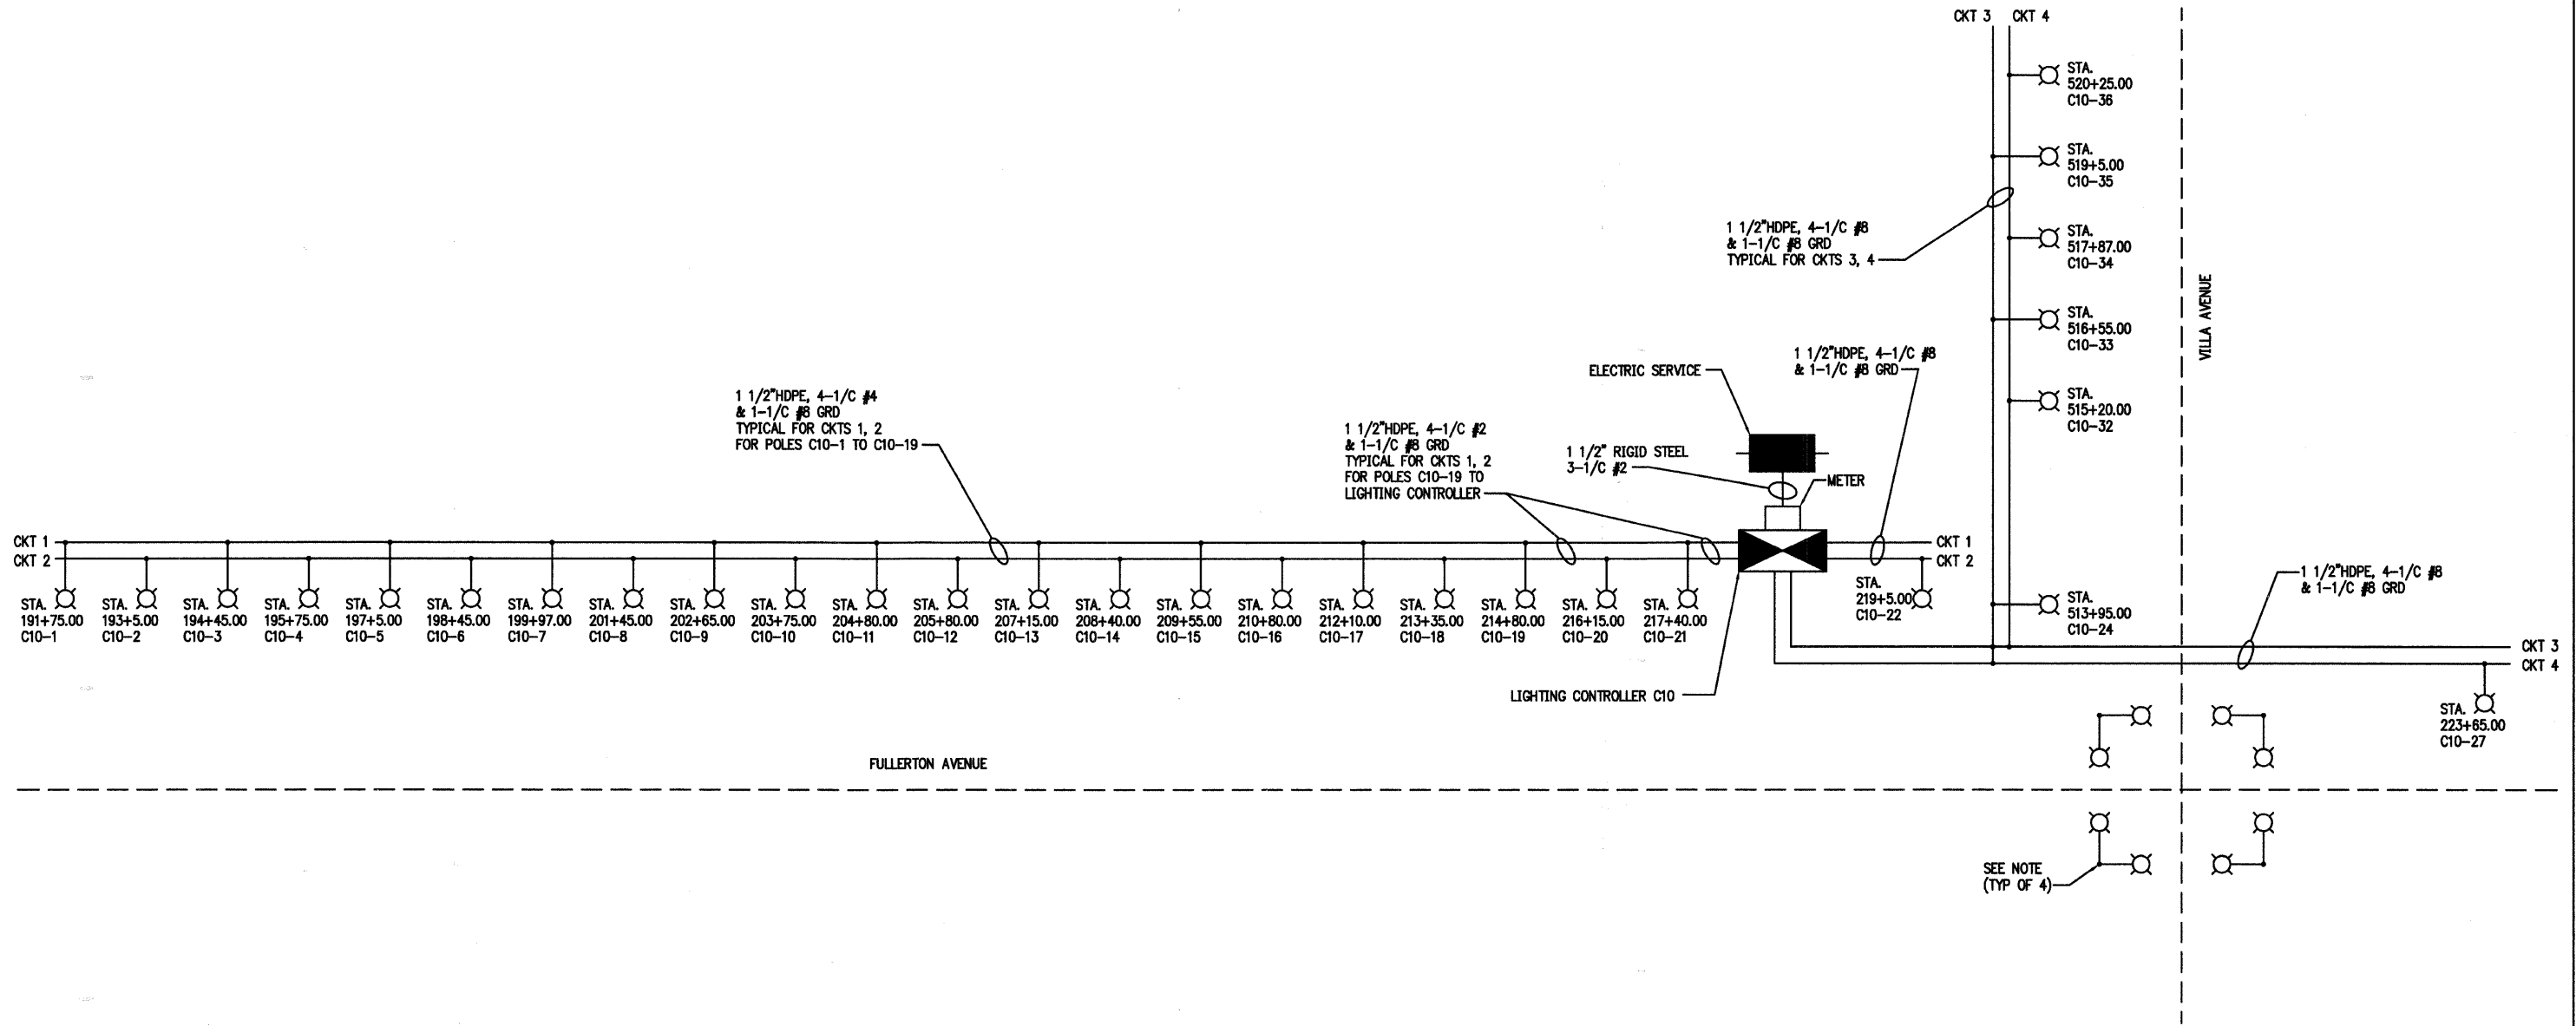

VILLAGE OF ADDISON
LIGHTING SYSTEM ONE-LINE DIAGRAM
 FULLERTON AVENUE

REVISIONS	
NAME	DATE

DATE: 11/26/2007
 DESIGNED BY: FEJ
 TECHNICIAN: FEJ
 CHECKED BY: DEM