


STRUCTURE SCHEDULE												
STR. NO.	STA.	OFFSET	STRUCTURE	OTHER	COVER	TEMP. RIM ELEV. CONTRACT 60W09	TEMP. RIM ELEV. CONTRACT 60M61	FINAL RIM ELEV. CONTRACT 60M61	N	E	S	W
217	193+45.00	3.3' RT	MH TA 4		T1F CL	691.07	691.43	693.06	684.00(N) 18"	685.65(E) 12"	684.10(S) 18"	685.53(W) 12"
220	194+45.00	1.26' RT	MH TA 4		T1F CL	689.97	690.38	691.93	683.02(N) 24"	684.49(E) 12"	683.52(S) 18"	684.49(W) 12"
223	195+45.00	1' RT	MH TA 4		T1F CL	689.02	689.45	690.98	682.48(N) 24"	684.62(E) 12"	682.58(S) 24"	684.62(W) 12"
232	196+63.30	1' RT	MH TA 4		T1F CL	688.55	689.04	690.47	681.86(N) 24"	684.12(E) 12"	681.96(S) 24"	684.11(W) 12"
233A	197+95.00	1' RT	MH TA 5		T1F CL	688.61	689.39	690.94	681.23(N) 24"	683.44(E) 12"	681.23(S) 24"	683.34(W) 24"


PIPE SCHEDULE							
PIPE NO.	STR. NO. FROM	STR. NO. TO	DESCRIPTION	IN DIA.	FT LEN	SLOPE	CU YD TBF
217	217	220	SS, CL A, TY 2	18	96.0	0.50%	83.1
220	220	223	SS, CL A, TY 2	24	96.0	0.46%	81.1
223	223	232	SS, CL A, TY 2	24	114.3	0.45%	96.6
232	232	233A	SS, CL A, TY 2	24	127.2	0.50%	117.9
232A	233A	EX CULV	SS, CL A, TY 2	24	20.0	0.005	22.6

PRECAST CONCRETE BOX CULVERT 9' x 6'
96' LENGTH
ASTM C 1577; 198+89.00; 0° SKEW; DESIGN FILL, 3.2FT.

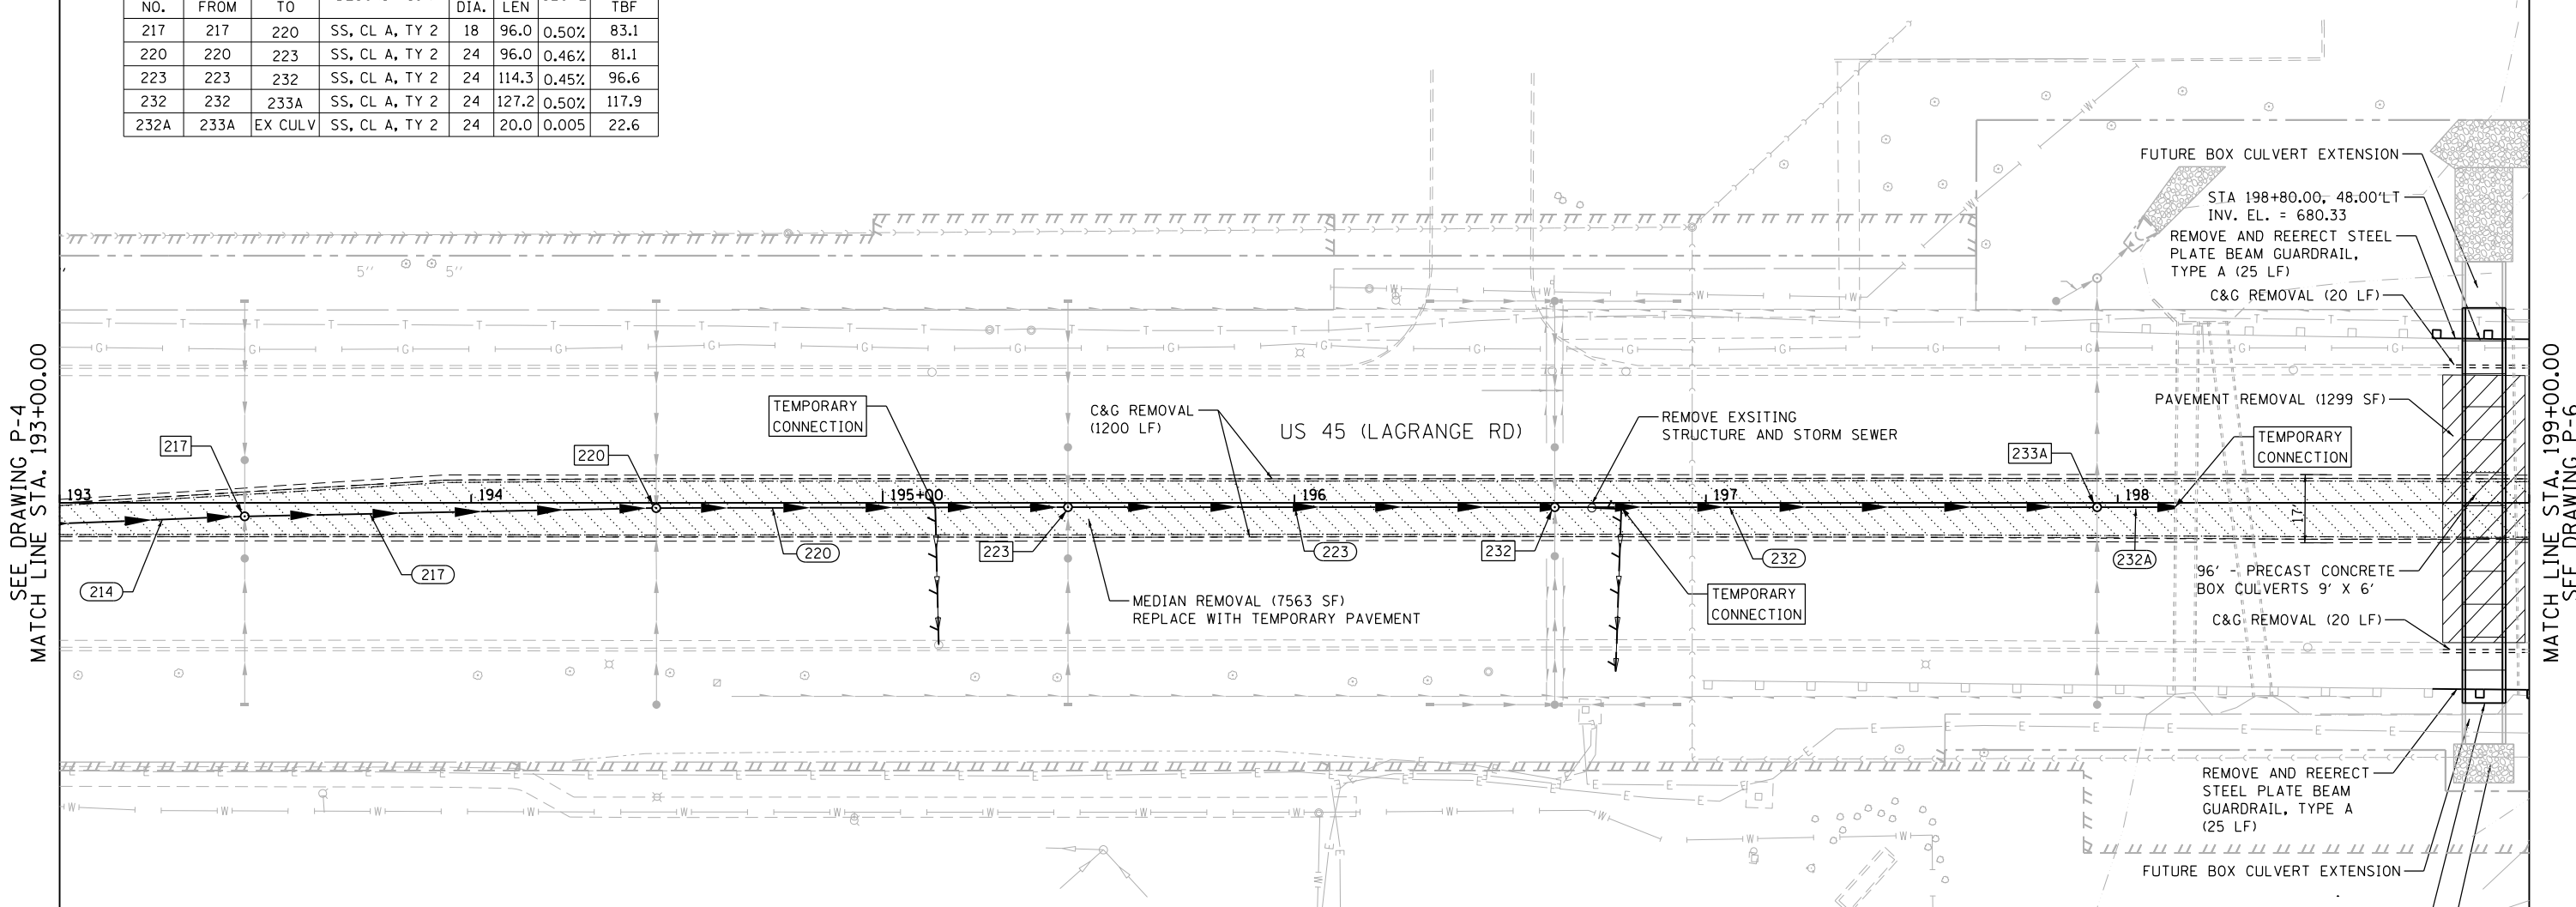

LEGEND

- | | | | |
|-------------------------|--|--|--|
| MEDIAN REMOVAL | | PROPOSED STORM SEWER | |
| BARRIER MEDIAN REMOVAL | | EXISTING STORM SEWER | |
| CONCRETE MEDIAN REMOVAL | | STORM SEWER TO BE PLUGGED AND ABANDONED (REMOVED IN FUTURE CONTRACT) | |
| SELECTIVE CLEARING | | TREE TO BE REMOVED | |
| TREE REMOVAL | | STORM STRUCTURE TO BE ADJUSTED | |
| PAVEMENT REMOVAL | | SIGN TO BE REMOVED | |
| R.O.W. NOT YET ACQUIRED | | PROPOSED MANHOLE | |
| | | FUTURE STORM SEWER | |

 

100 S. WACKER DR.
 CHICAGO, IL 60606
 TEL (312) 939-1000
 FAX (312) 939-4998
URS

FILE NAME = D:\60W09-SHT-DRAINPR05.dgn	USER NAME = Anthony.Plutz	DESIGNED - EJD	REVISED -	STATE OF ILLINOIS DEPARTMENT OF TRANSPORTATION	REMOVAL, TEMPORARY PAVEMENT, AND DRAINAGE PLAN	F.A.P. RTE. 330	SECTION 2012-0881	COUNTY COOK	TOTAL SHEETS 152	SHEET NO. 30		
SHT_PLAN	PLOT SCALE = 48.0000' / in.	CHECKED - JWM	REVISED -			P-5		CONTRACT NO. 60W09		ILLINOIS FED. AID PROJECT		
D160W09-SHT-DRAINPR05.dgn	PLOT DATE = 1/18/2013	DATE - 01/02/13	REVISED -			SCALE: 1"=20'	SHEET 5 OF 37 SHEETS	STA. 193+00.00 TO STA. 199+00.00				
<p style="text-align: center;">MATCH LINE STA. 193+00.00 MATCH LINE STA. 199+00.00</p>												