


PIPE SCHEDULE							
PIPE NO.	STR. NO. FROM	STR. NO. TO	DESCRIPTION	IN DIA.	FT LEN	SLOPE	CU YD TBF
423	423	430	SS, CL A, TY 2	18	61.0	0.54%	48.4
423A	420	423	SS, CL A, TY 2	15	66.0	0.53%	49.2
424B	430	429	SS, CL A, TY 2	18	104.1	0.54%	90.1
429	429	EX430	SS, CL A, TY 2	18	36.0	0.61%	32.5
434	435	429	SS, CL A, TY 2	12	46.9	1.11%	18.0

STRUCTURE SCHEDULE												
STR. NO.	STA.	OFFSET	STRUCTURE	OTHER	COVER	TEMP. RIM ELEV.	TEMP. RIM ELEV.	FINAL RIM ELEV.	N	E	S	W
						CONTRACT 60W09	CONTRACT 60M61	CONTRACT 60M61				
420	204+55.00	3' RT	MH TA 4		T1F CL	691.07	691.72	693.35	684.89(N) 15"	687.03(E) 12"	684.79(S) 15"	685.80(W) 12"
423	203+85.00	3' RT	MH TA 4		T1F CL	690.70	691.46	693.16	684.44(N) 15"		684.19(S) 18"	685.50(W) 12"
430	203+20.00	3' RT	MH TA 4		T1F CL	690.41	691.23	692.98	683.86(N) 18"	685.75(E) 12"	683.76(S) 18"	685.23(W) 12"
429	202+11.40	3' RT	MH TA 5		T1F CL	690.06	690.85	692.59	683.20(N) 18"	683.10(E) 18"	684.22(S) 12"	685.76(NW) 12"
EX430	202+11.40	40.5' RT	ADJ MH					690.12	681.96(N) 48"	682.29(E) 18"	682.26(S) 48"	682.88(W) 18"
435	201+60.00	3' RT	MH TA 4		T1F CL	689.96	690.66	692.41	684.74(N) 12"	685.88(E) 12"		684.84(W) 12"

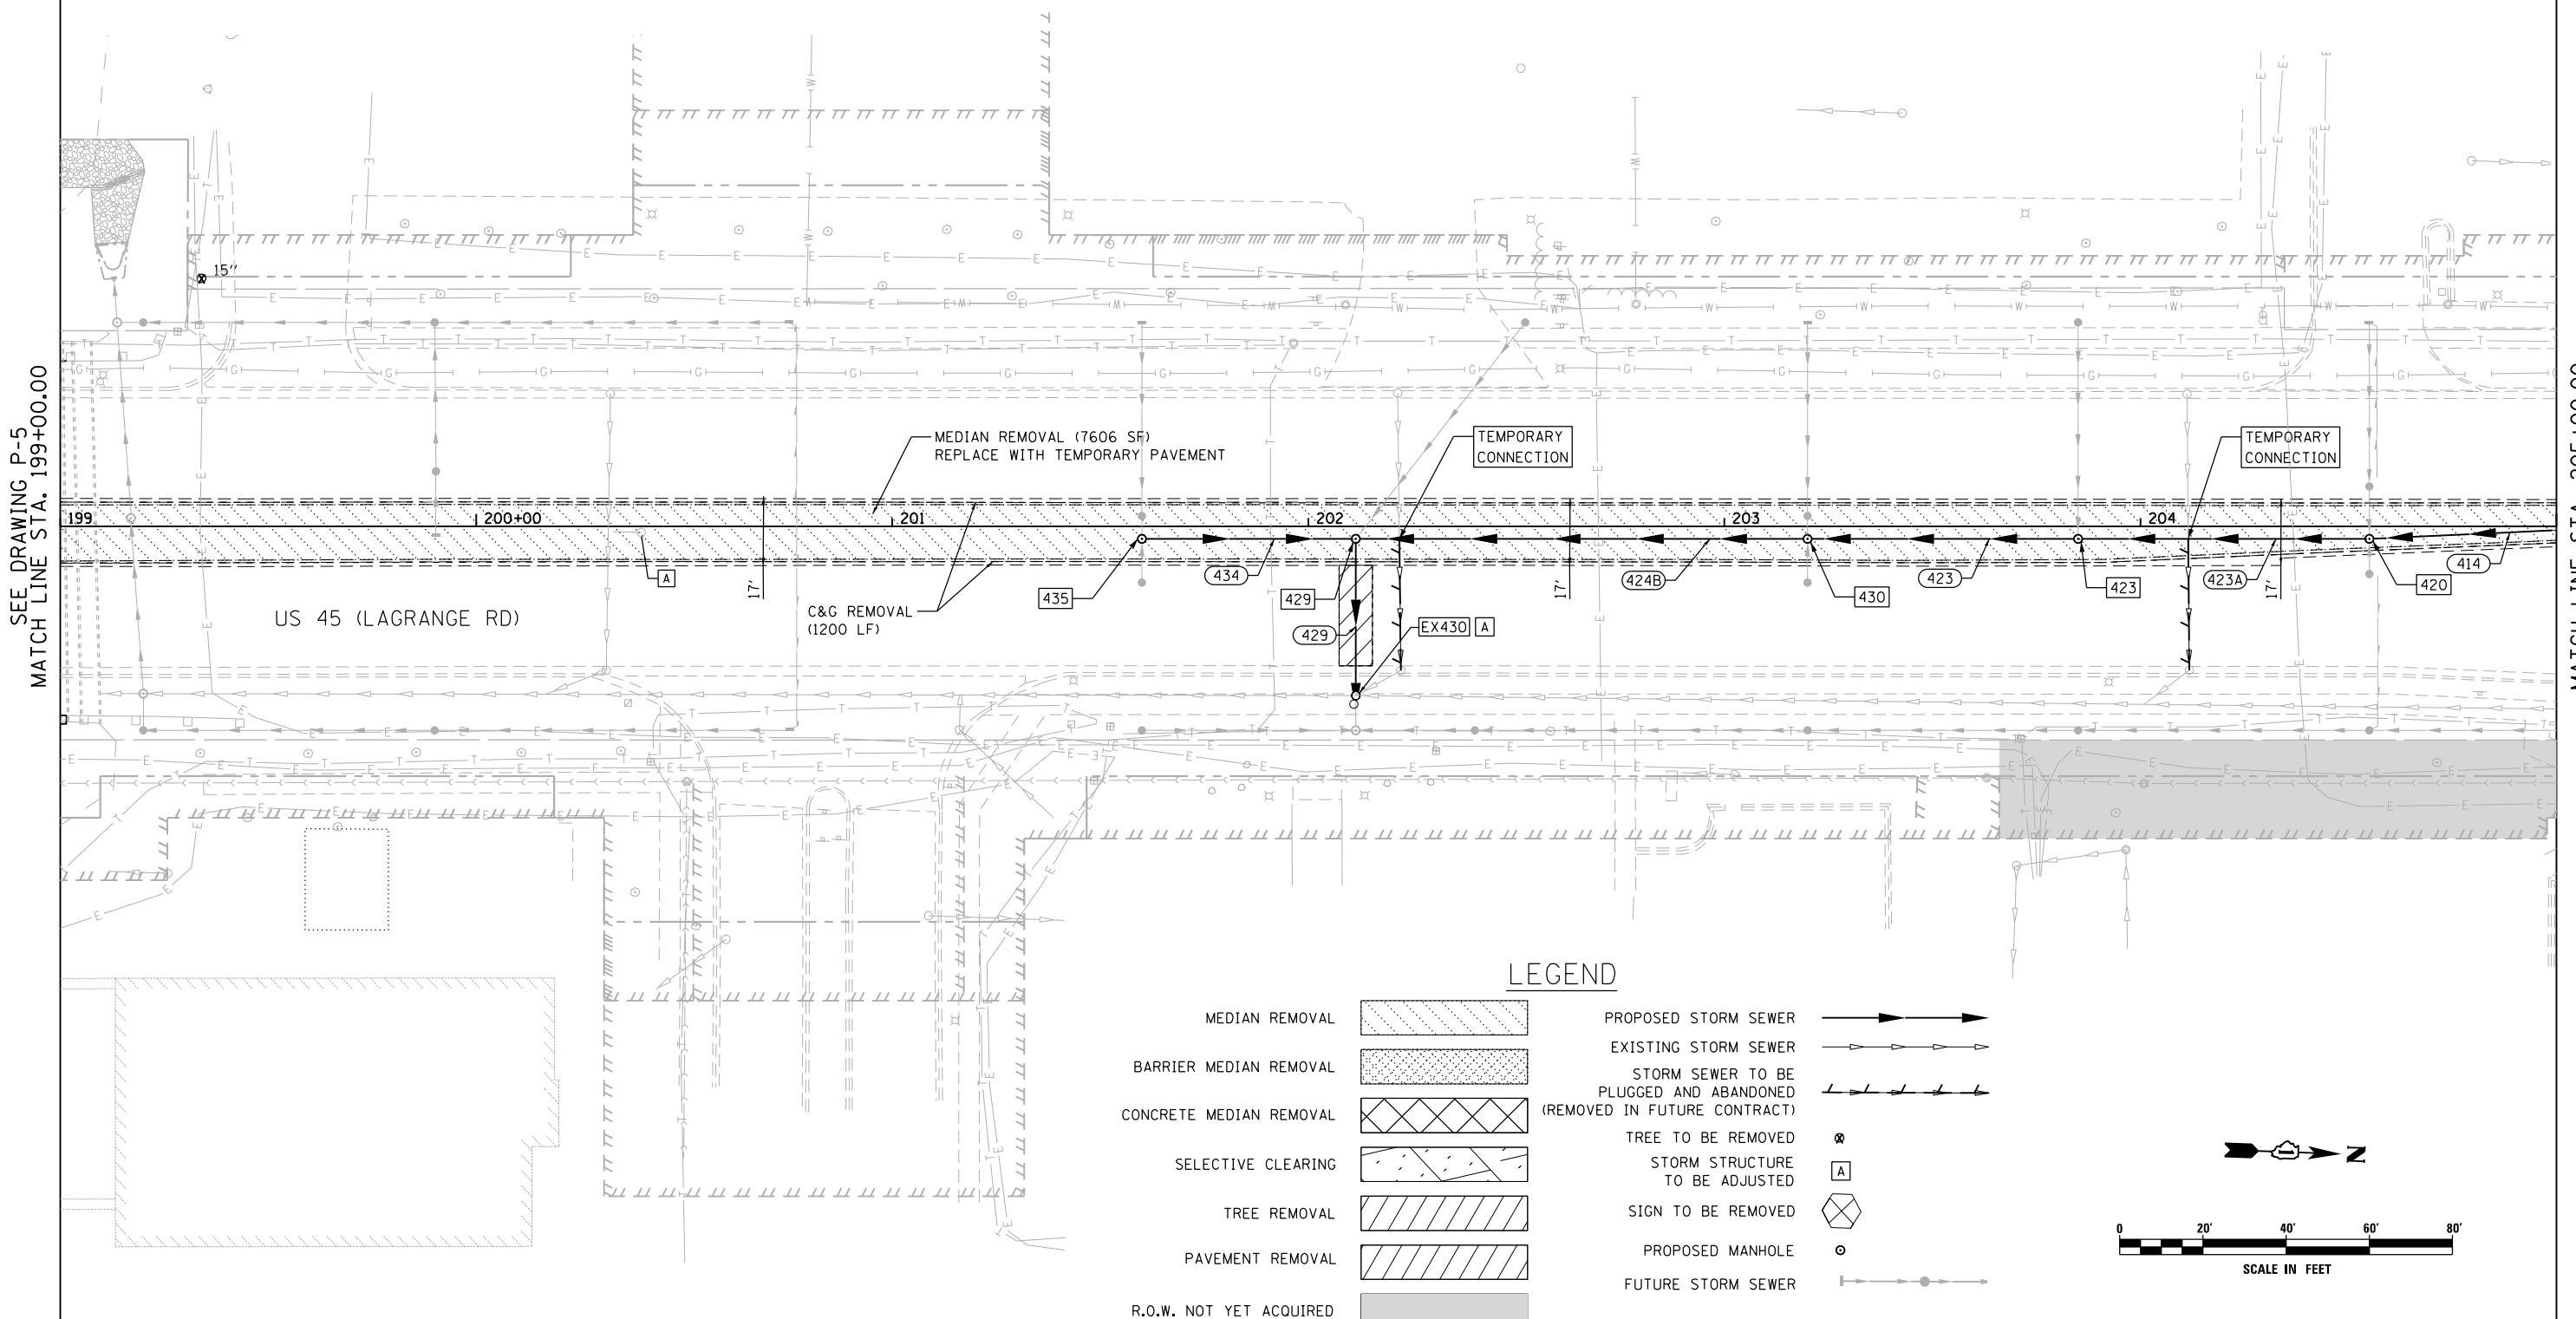

LEGEND

- MEDIAN REMOVAL
- BARRIER MEDIAN REMOVAL
- CONCRETE MEDIAN REMOVAL
- SELECTIVE CLEARING
- TREE REMOVAL
- PAVEMENT REMOVAL
- R.O.W. NOT YET ACQUIRED
- PROPOSED STORM SEWER
- EXISTING STORM SEWER
- STORM SEWER TO BE PLUGGED AND ABANDONED (REMOVED IN FUTURE CONTRACT)
- TREE TO BE REMOVED
- STORM STRUCTURE TO BE ADJUSTED
- SIGN TO BE REMOVED
- PROPOSED MANHOLE
- FUTURE STORM SEWER

SEE DRAWING P-5
MATCH LINE STA. 199+00.00

MATCH LINE STA. 205+00.00
SEE DRAWING P-7

URS
100 S. WACKER DR.
SUITE 600
CHICAGO, IL 60606
TEL (312) 935-1000
FAX (312) 935-4998

FILE NAME = D:\160W09-SHT-DRAINPR06.dgn	USER NAME = Anthony.Plutz	DESIGNED - EJD	REVISED -	STATE OF ILLINOIS DEPARTMENT OF TRANSPORTATION	PROPOSED DRAINAGE PLAN - US 45 (LAGRANGE ROAD)			F.A.P. RTE. 330	SECTION 2012-0881	COUNTY COOK	TOTAL SHEETS 152	SHEET NO. 31
SHT.PLAN	PLOT SCALE = 48.0000' / in.	CHECKED - JWM	REVISED -		SCALE: 1"=20'	SHEET 6 OF 37 SHEETS	STA. 199+00.00 TO STA. 205+00.00	P-6		CONTRACT NO. 60W09		
	PLOT DATE = 1/7/2013	DATE - 01/02/13	REVISED -		ILLINOIS FED. AID PROJECT							