



STRUCTURE SCHEDULE												
STR. NO.	STA.	OFFSET	STRUCTURE	OTHER	COVER	TEMP. RIM ELEV. CONTRACT 60W09	TEMP. RIM ELEV. CONTRACT 60M61	FINAL RIM ELEV. CONTRACT 60M61	N	E	S	W
349	220+55.00	3.6' LT	MH TA 4		TIF CL	704.88	706.54	706.34		700.64(E) 12"	700.51(S) 12"	700.61(W) 12"
EX350	219+81.90	43' RT	ADJ MH					705.36	688.43(N) 42"	700.68(SE) 12"	688.48(S) 48"	699.70(W) 12"
355	219+81.90	2.3' LT	MH TA 4		TIF CL	704.66	706.22	706.05	699.38(N) 12"	700.15(E) 12"	699.38(S) 12"	700.25(W) 12"
358	219+05.00	' RT	MH TA 4		TIF CL	704.37	705.87	705.78	699.87(N) 12"	699.97(E) 12"		700.01(W) 12"
361	218+35.00	' RT	MH TA 4		TIF CL	704.15	705.57	705.49		699.68(E) 12"	699.58(S) 12"	699.68(W) 12"
366	217+60.00	0.8' LT	MH TA 4		TIF CL	703.95	705.28	705.25	698.98(N) 12"	699.37(E) 12"	699.36(S) 12"	699.36(W) 12"

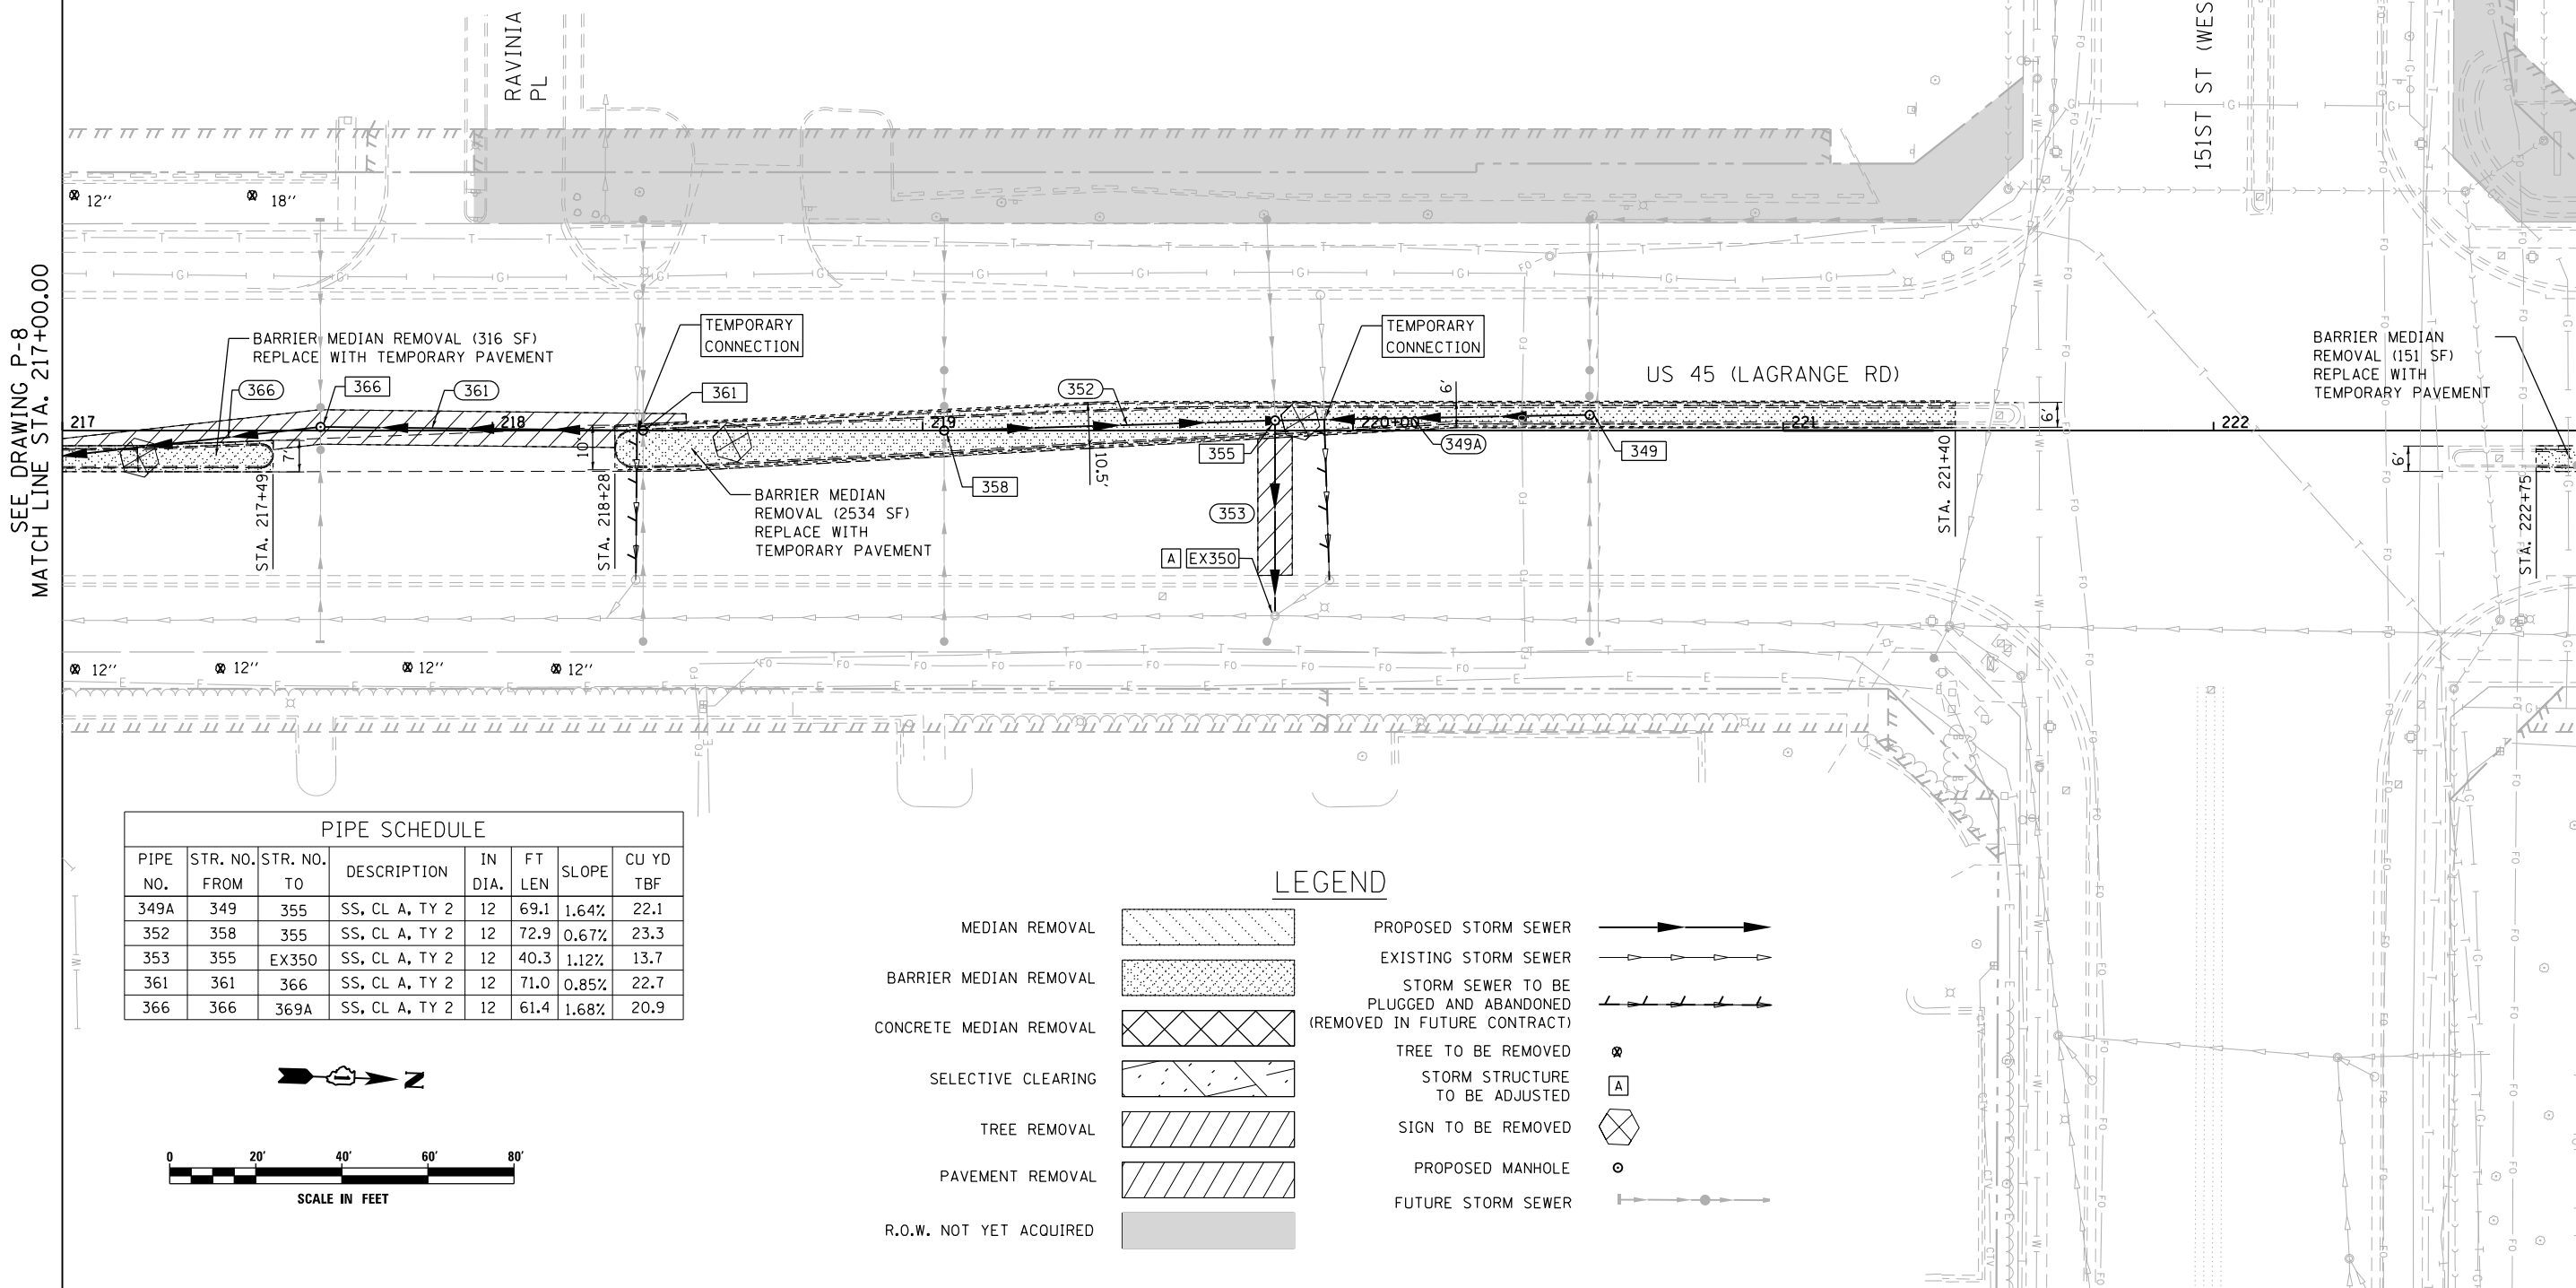

SEE DRAWING P-8  
MATCH LINE STA. 217+00.00

MATCH LINE STA. 223+00.00  
SEE DRAWING P-10

PIPE SCHEDULE							
PIPE NO.	STR. NO. FROM	STR. NO. TO	DESCRIPTION	IN DIA.	FT LEN	SLOPE	CU YD TBF
349A	349	355	SS, CL A, TY 2	12	69.1	1.64%	22.1
352	358	355	SS, CL A, TY 2	12	72.9	0.67%	23.3
353	355	EX350	SS, CL A, TY 2	12	40.3	1.12%	13.7
361	361	366	SS, CL A, TY 2	12	71.0	0.85%	22.7
366	366	369A	SS, CL A, TY 2	12	61.4	1.68%	20.9

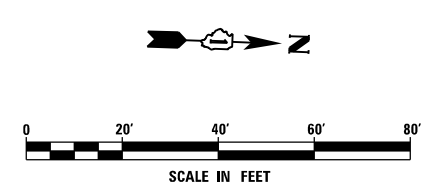

**LEGEND**

MEDIAN REMOVAL		PROPOSED STORM SEWER	
BARRIER MEDIAN REMOVAL		EXISTING STORM SEWER	
CONCRETE MEDIAN REMOVAL		STORM SEWER TO BE PLUGGED AND ABANDONED (REMOVED IN FUTURE CONTRACT)	
SELECTIVE CLEARING		TREE TO BE REMOVED	
TREE REMOVAL		STORM STRUCTURE TO BE ADJUSTED	
PAVEMENT REMOVAL		SIGN TO BE REMOVED	
R.O.W. NOT YET ACQUIRED		PROPOSED MANHOLE	
		FUTURE STORM SEWER	

URS  
100 S. WACKER DR.  
100 S. WACKER DR.  
CHICAGO, IL 60606  
TEL (312) 935-1000  
FAX (312) 935-4998

FILE NAME = D:\160W09-SHT-DRAINPR09.dgn	USER NAME = Anthony.Plutz	DESIGNED - EJD	REVISED -
PLOT SCALE = 48.0000' / in.	CHECKED - JWM	DRAWN - EJD	REVISED -
PLOT DATE = 1/7/2013	DATE - 01/02/13	REVISOR -	REVISED -

STATE OF ILLINOIS  
DEPARTMENT OF TRANSPORTATION

REMOVAL, TEMPORARY PAVEMENT, AND DRAINAGE PLAN

SCALE: 1"=20' SHEET 9 OF 37 SHEETS STA. 217+00.00 TO STA. 223+00.00

F.A.P. RTE.	SECTION	COUNTY	TOTAL SHEETS	SHEET NO.
330	2012-0881	COOK	152	34
P-9		CONTRACT NO. 60W09		
ILLINOIS FED. AID PROJECT				