


PLAN	DATE
BY	
CHECKED	
DATE	
NO.	
FILE NAME	

PROF. FILE	DATE
BY	
CHECKED	
DATE	
NO.	
FILE NAME	

MATCH LINE STA. 219+45  
(SEE SHEET NO. 147)

MATCH LINE STA. 225+10  
(SEE SHEET NO. 149)

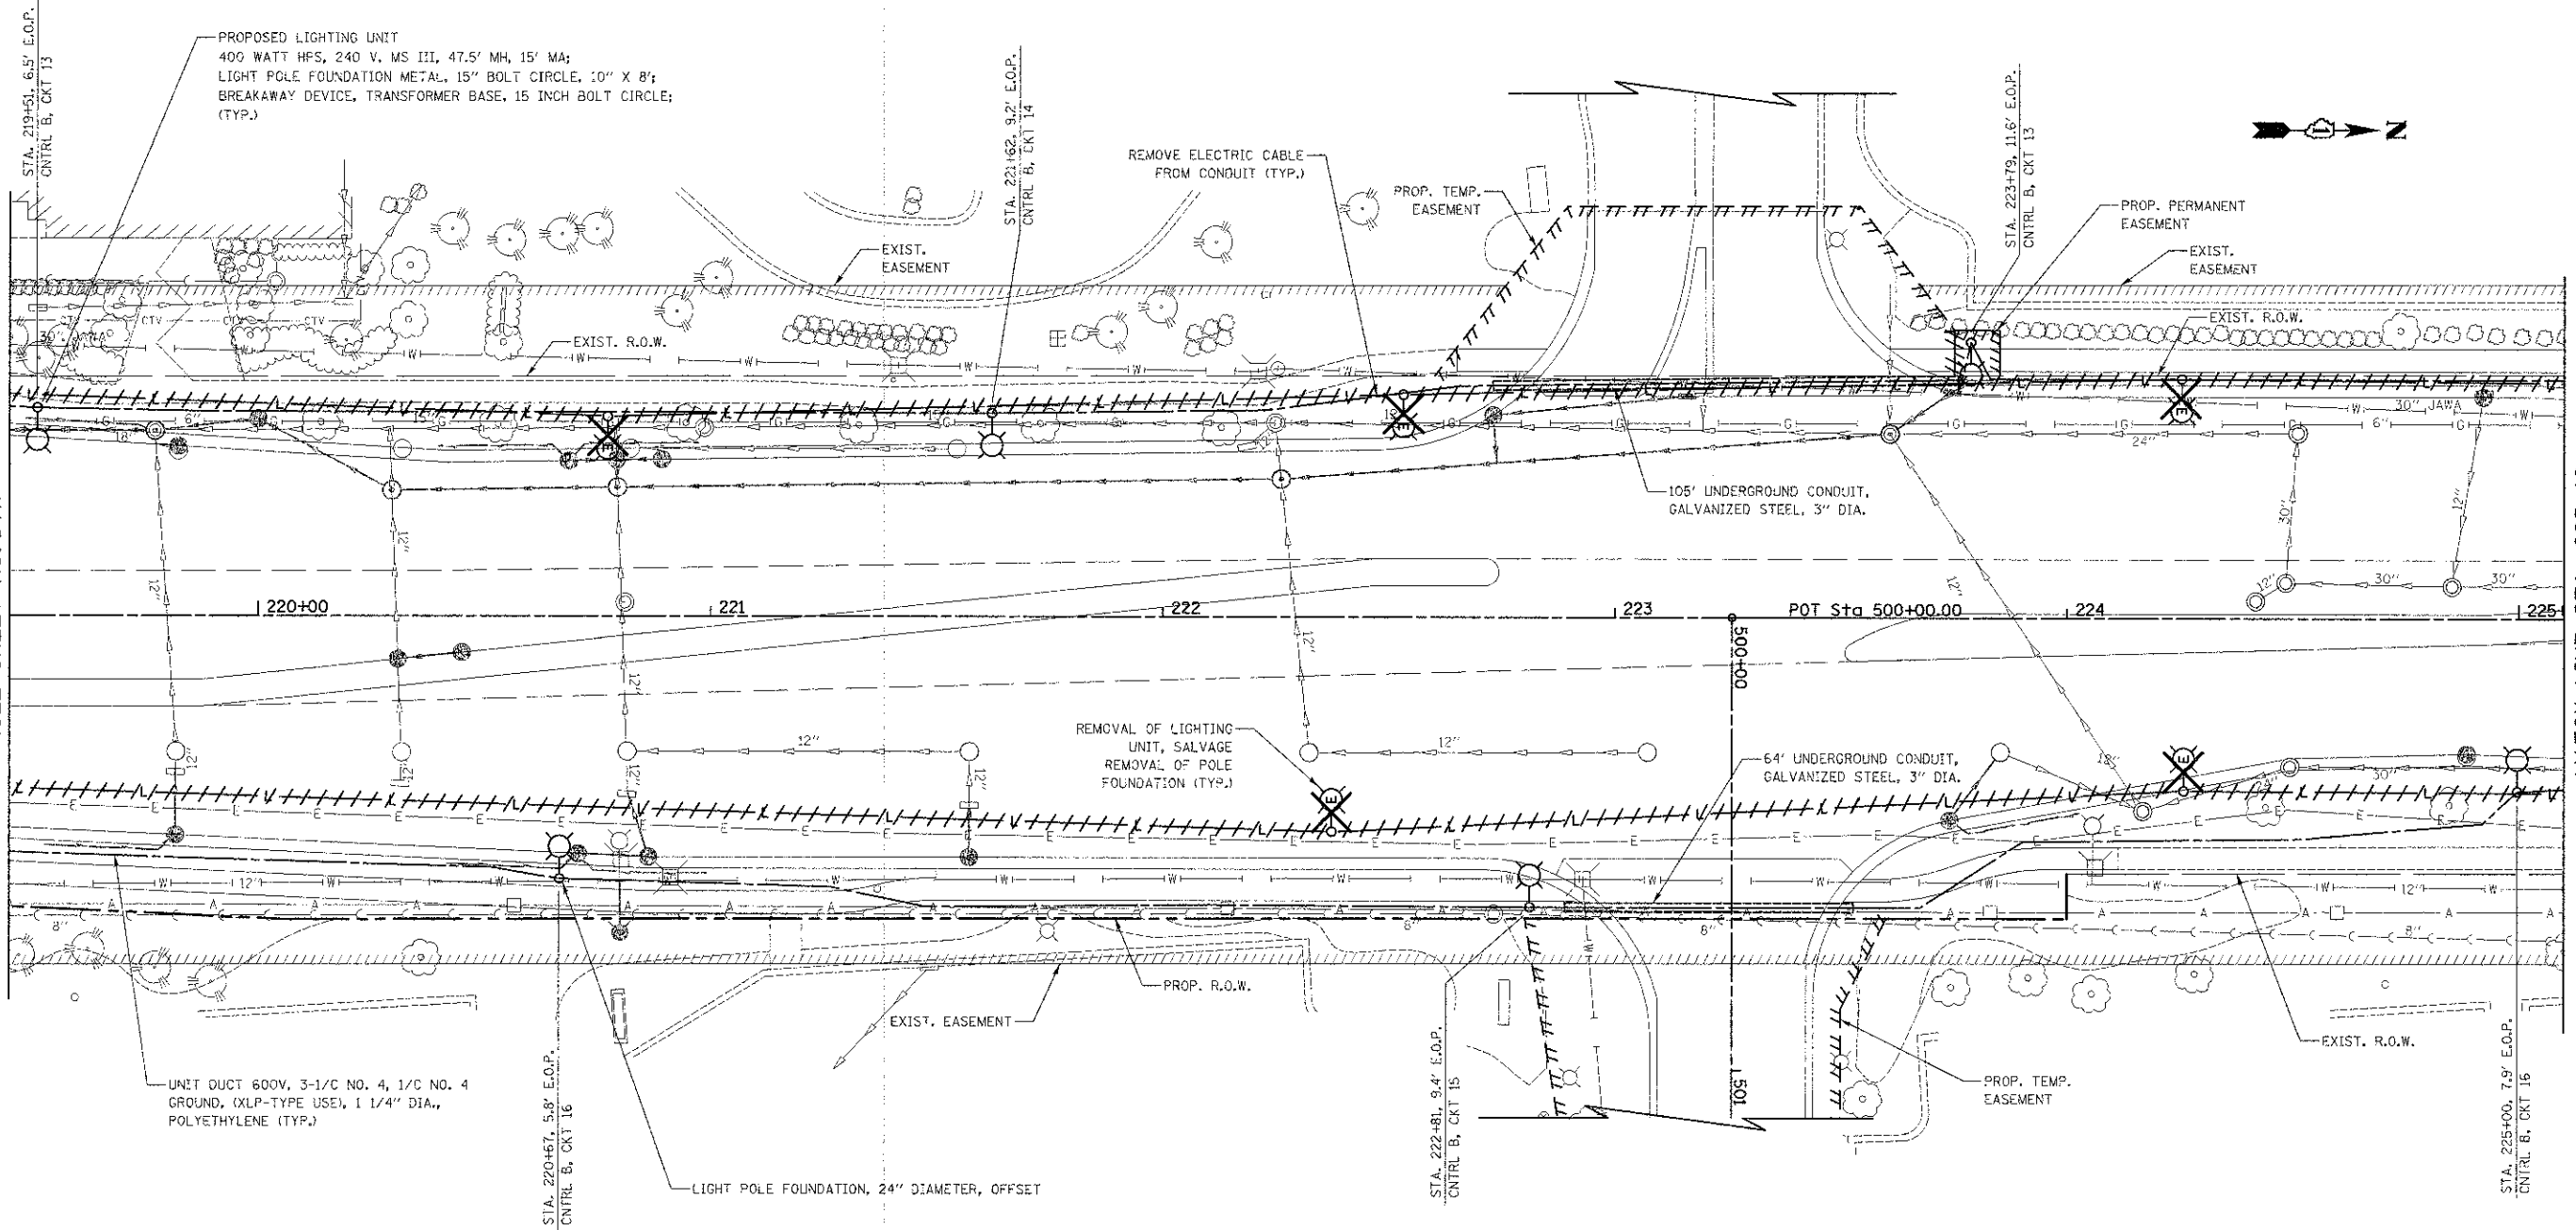

BARRINGTON ROAD

FILE NAME = ...\\od\sheet\2325\_LIGHT\_04.dgn

USER NAME = djk  
PLOT SCALE = 20,0000 1/ in.  
PLOT DATE = 8/16/2012

DESIGNED - SJC  
DRAWN - SJC  
CHECKED - DNM  
DATE - 8-20-12

REVISED -  
REVISED -  
REVISED -  
REVISED -

STATE OF ILLINOIS  
DEPARTMENT OF TRANSPORTATION

BARRINGTON ROAD  
LIGHTING PLANS

SCALE: 1" = 20' SHEET NO. 4 OF 12 SHEETS STA. 219+45 TO STA. 225+10

F.A.U. RTE.	SECTION	COUNTY	TOTAL SHEETS NO.
1322	01-00074-00-CH	COOK	245 / 148
CONTRACT NO. 63629			
FED. ROAD DIST. NO. 1 ILLINOIS FED. AID PROJECT M-CM-800305D			