



PLAN	DATE	BY
DESIGNED		
DRAWN		
CHECKED		
NOTED		
FILE NAME		

PROFILE	DATE	BY
DESIGNED		
DRAWN		
CHECKED		
NOTED		
FILE NAME		

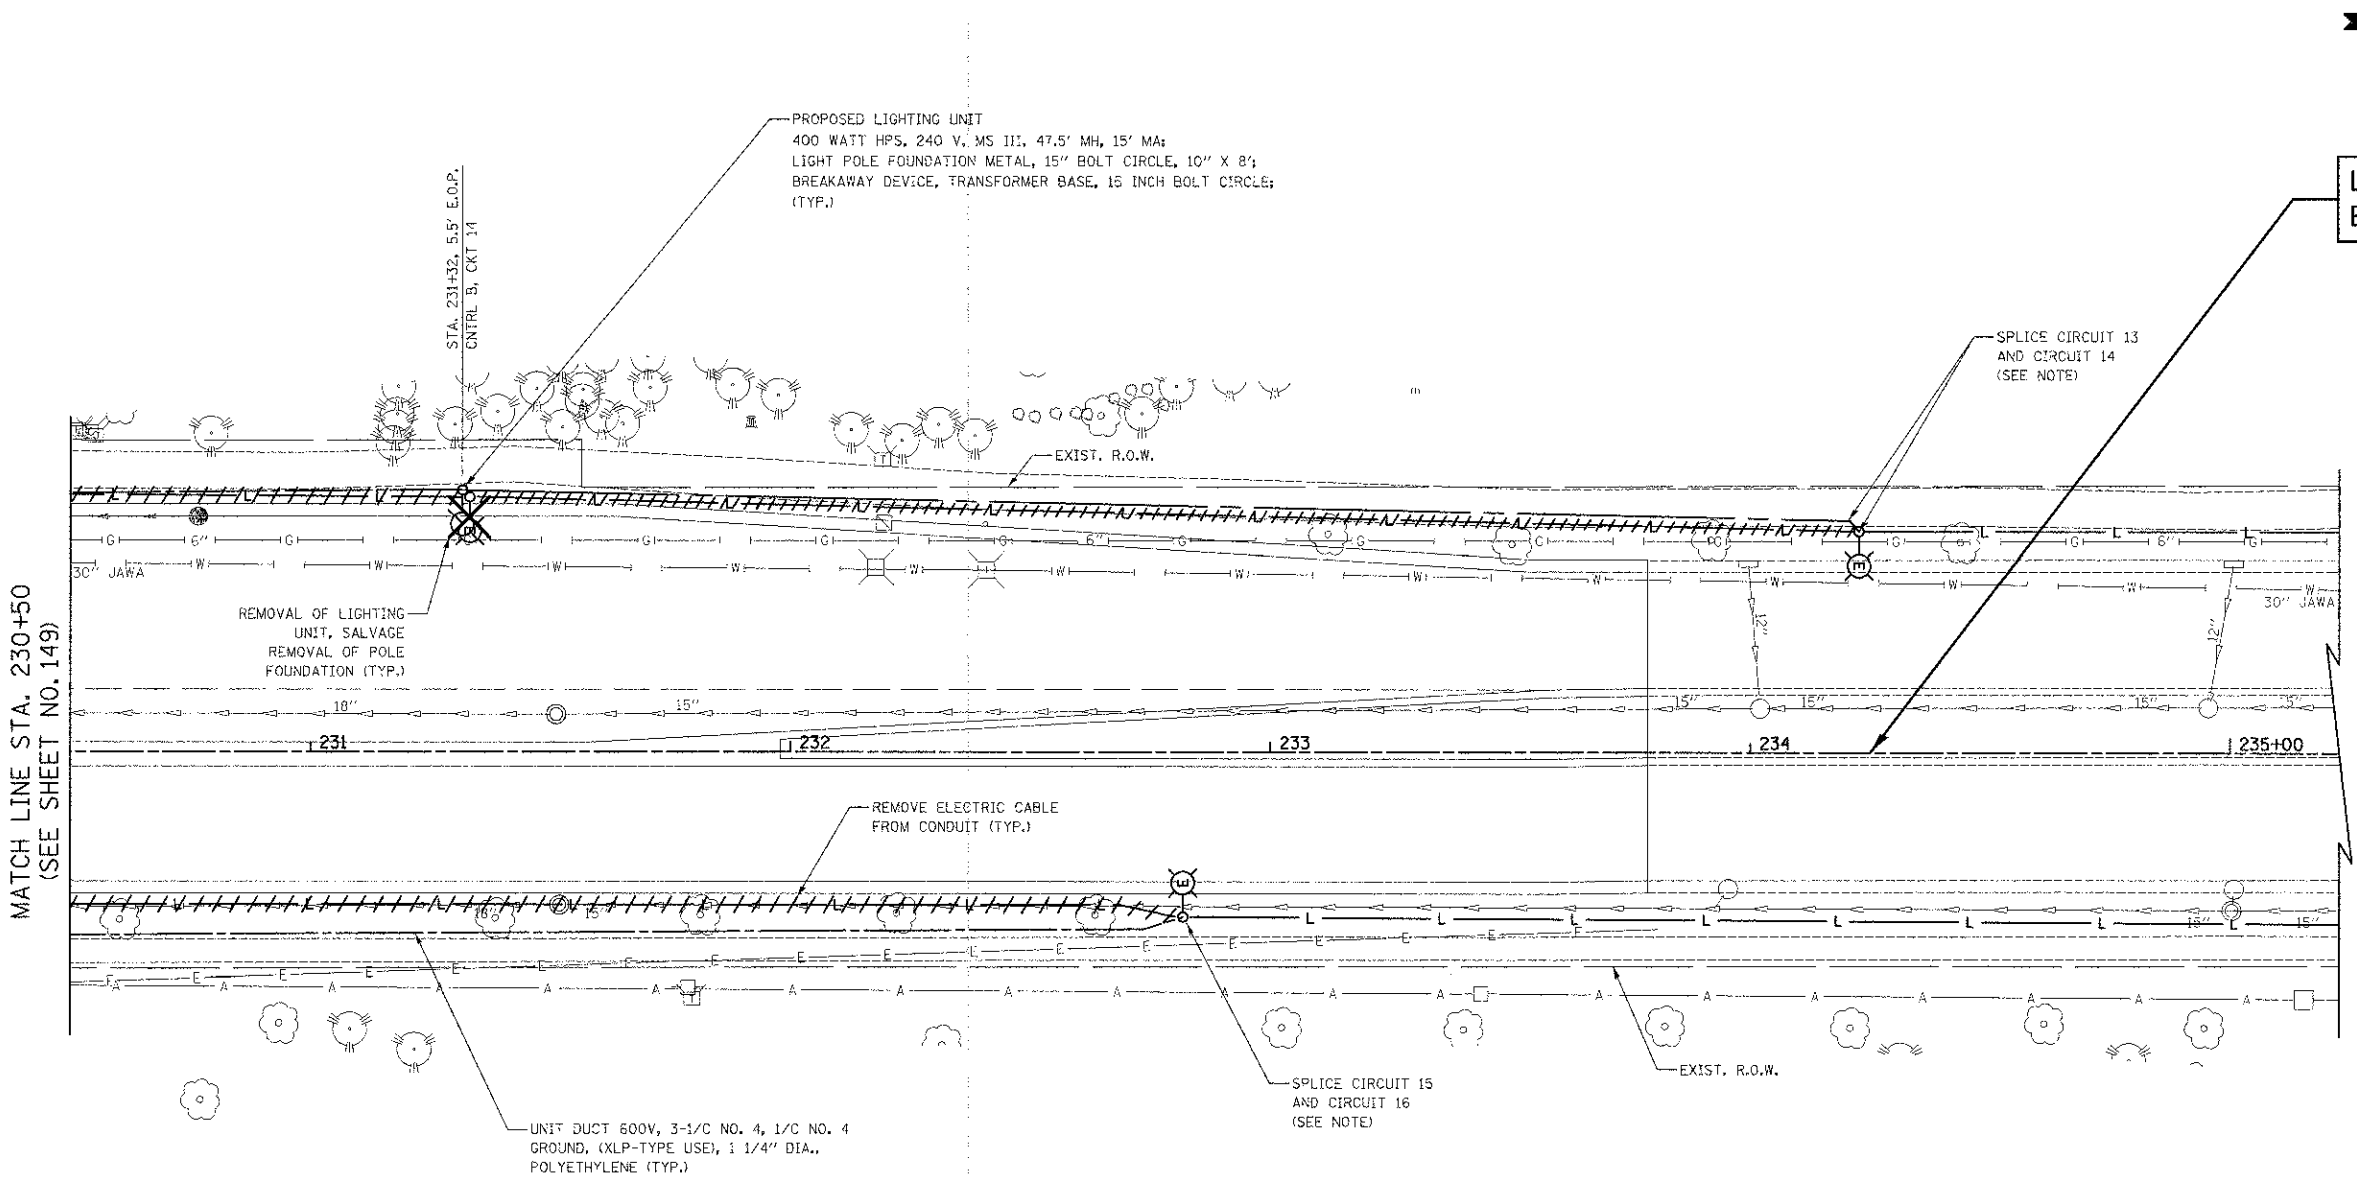

**LIGHTING IMPROVEMENT
 ENDS STA. 234+25**

 **MATCH LINE STA. 230+50
 (SEE SHEET NO. 149)**



BARRINGTON ROAD

NOTE:
 WHEN SPlicing TO EXISTING POLE, ANY AND ALL WORK REQUIRED TO RUN THE PROPOSED UNIT DUCT INTO EXISTING FOUNDATION SLEEVE AND SPlicing IN EXISTING POLE SHALL BE COVERED AND INCLUDED IN THE PAY ITEM FOR THE UNIT DUCT.

FILE NAME = \\oad\ahot\2329_LIGHT_05.dgn

USER NAME = d.j.k	DESIGNED - SJC	REVISED -
	DRAWN - SJC	REVISED -
PLOT SCALE = 20.0000' / 1" =	CHECKED - DNM	REVISED -
PLOT DATE = 8/16/2012	DATE - 8-20-12	REVISED -

**STATE OF ILLINOIS
 DEPARTMENT OF TRANSPORTATION**

**BARRINGTON ROAD
 LIGHTING PLANS**

SCALE: 1" = 20' SHEET NO. 6 OF 12 SHEETS STA. 230+50 TO STA. 233+00

F.A.U. RTE.	SECTION	COUNTY	TOTAL SHEET NO.
1322	01-00074-00-CH	COOK	245 156
FED. ROAD DIST. NO. 1 ILLINOIS FED. AID PROJECT M-DM-8603050			CONTRACT NO. 63629