



PLAN	SURVEYED	BY	DATE
	IN (NAME)		
	NOTE BOOK NO.		
	FIELD FILE NAME		

PROF. ILL.	SURVEYED	BY	DATE
	GRABS CHECKED		
	STRUCTURE NOTATIONS CHECKED		
	NOTE BOOK NO.		

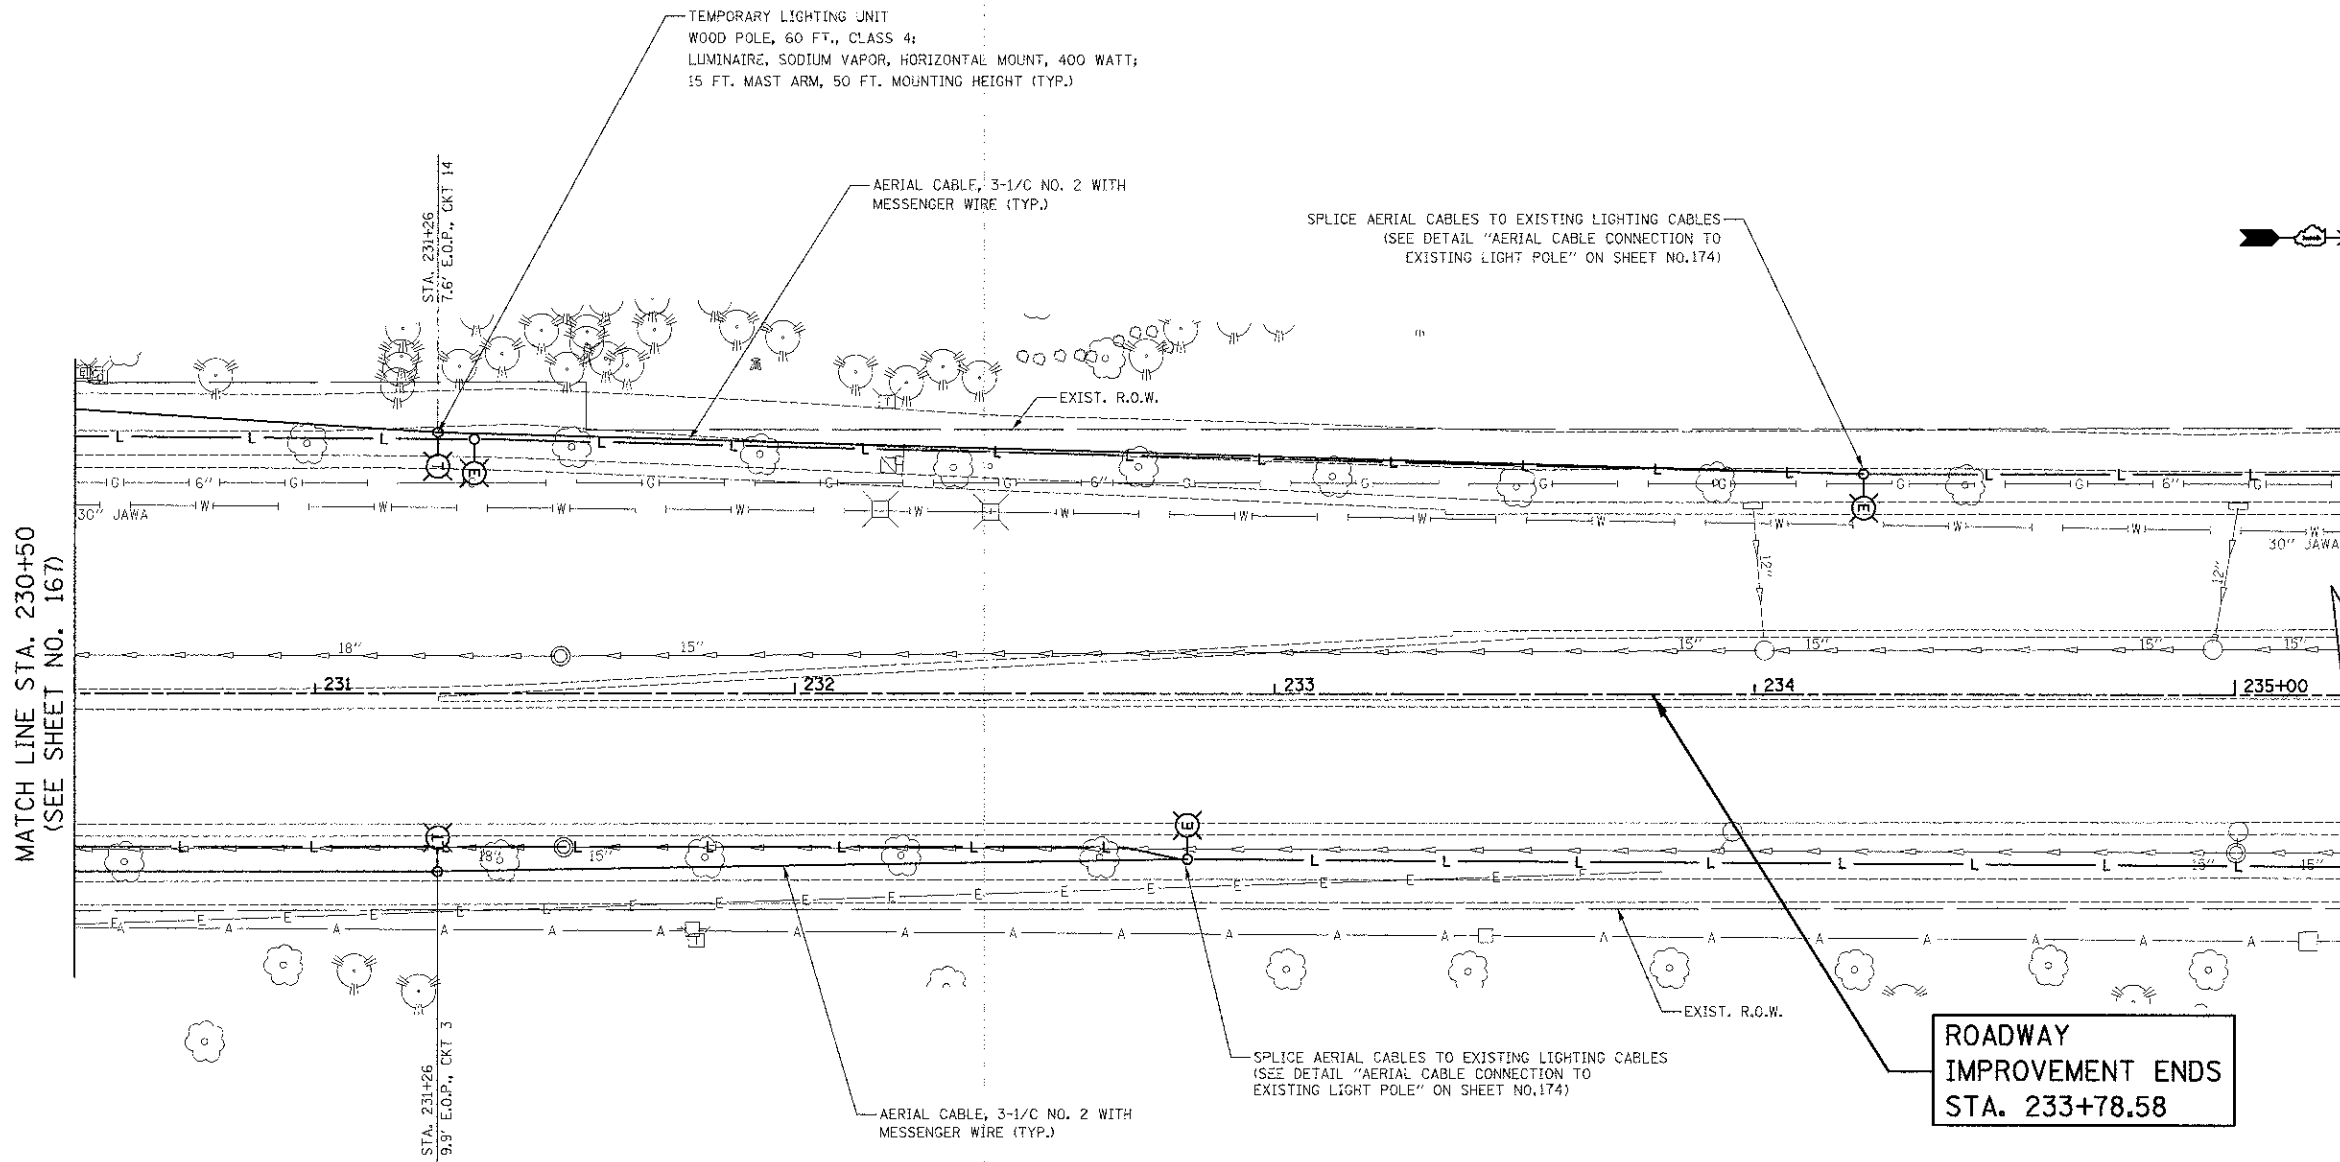

NOTES:

 1. TEMPORARY LIGHTING SHALL BE INSTALLED AND OPERATIONAL BEFORE DISCONNECTING AND REMOVING EXISTING LIGHTING UNITS.
2. TEMPORARY LIGHTING SHALL REMAIN OPERATIONAL UNTIL THE PROPOSED LIGHTING SYSTEM IS INSTALLED AND IS OPERATIONAL.



BARRINGTON ROAD

FILE NAME = ...sheet\2329\_TEMP\_LIGHT\_05.dgn

USER NAME = djk  
 PLOT SCALE = 20.0000' / 1" = 20'  
 PLOT DATE = 8/16/2012

DESIGNED - SJC  
 DRAWN - SJC  
 CHECKED - DNM  
 DATE - 8-20-12

REVISED -  
 REVISED -  
 REVISED -  
 REVISED -

STATE OF ILLINOIS  
 DEPARTMENT OF TRANSPORTATION

BARRINGTON ROAD  
 TEMPORARY LIGHTING PLANS

SCALE: 1" = 20' SHEET NO. 6 OF 11 SHEETS STA. 230+50 TO STA. 233+78.58

F.A.U. RTE.	SECTION	COUNTY	TOTAL SHEETS	SHEET NO.
1322	01-00074-00-CH	COOK	245	168
CONTRACT NO. 63629				
FED. ROAD DIST. NO. 1 ILLINOIS FED. AID PROJECT M-CMM-80030651				