



DATE	BY	REVISIONS
		1. PLOTTED
		2. CHECKED
		3. APPROVED
		4. DATE
		5. TIME
		6. BY
		7. TITLE
		8. NO.

DATE	BY	REVISIONS
		1. PLOTTED
		2. CHECKED
		3. APPROVED
		4. DATE
		5. TIME
		6. BY
		7. TITLE
		8. NO.

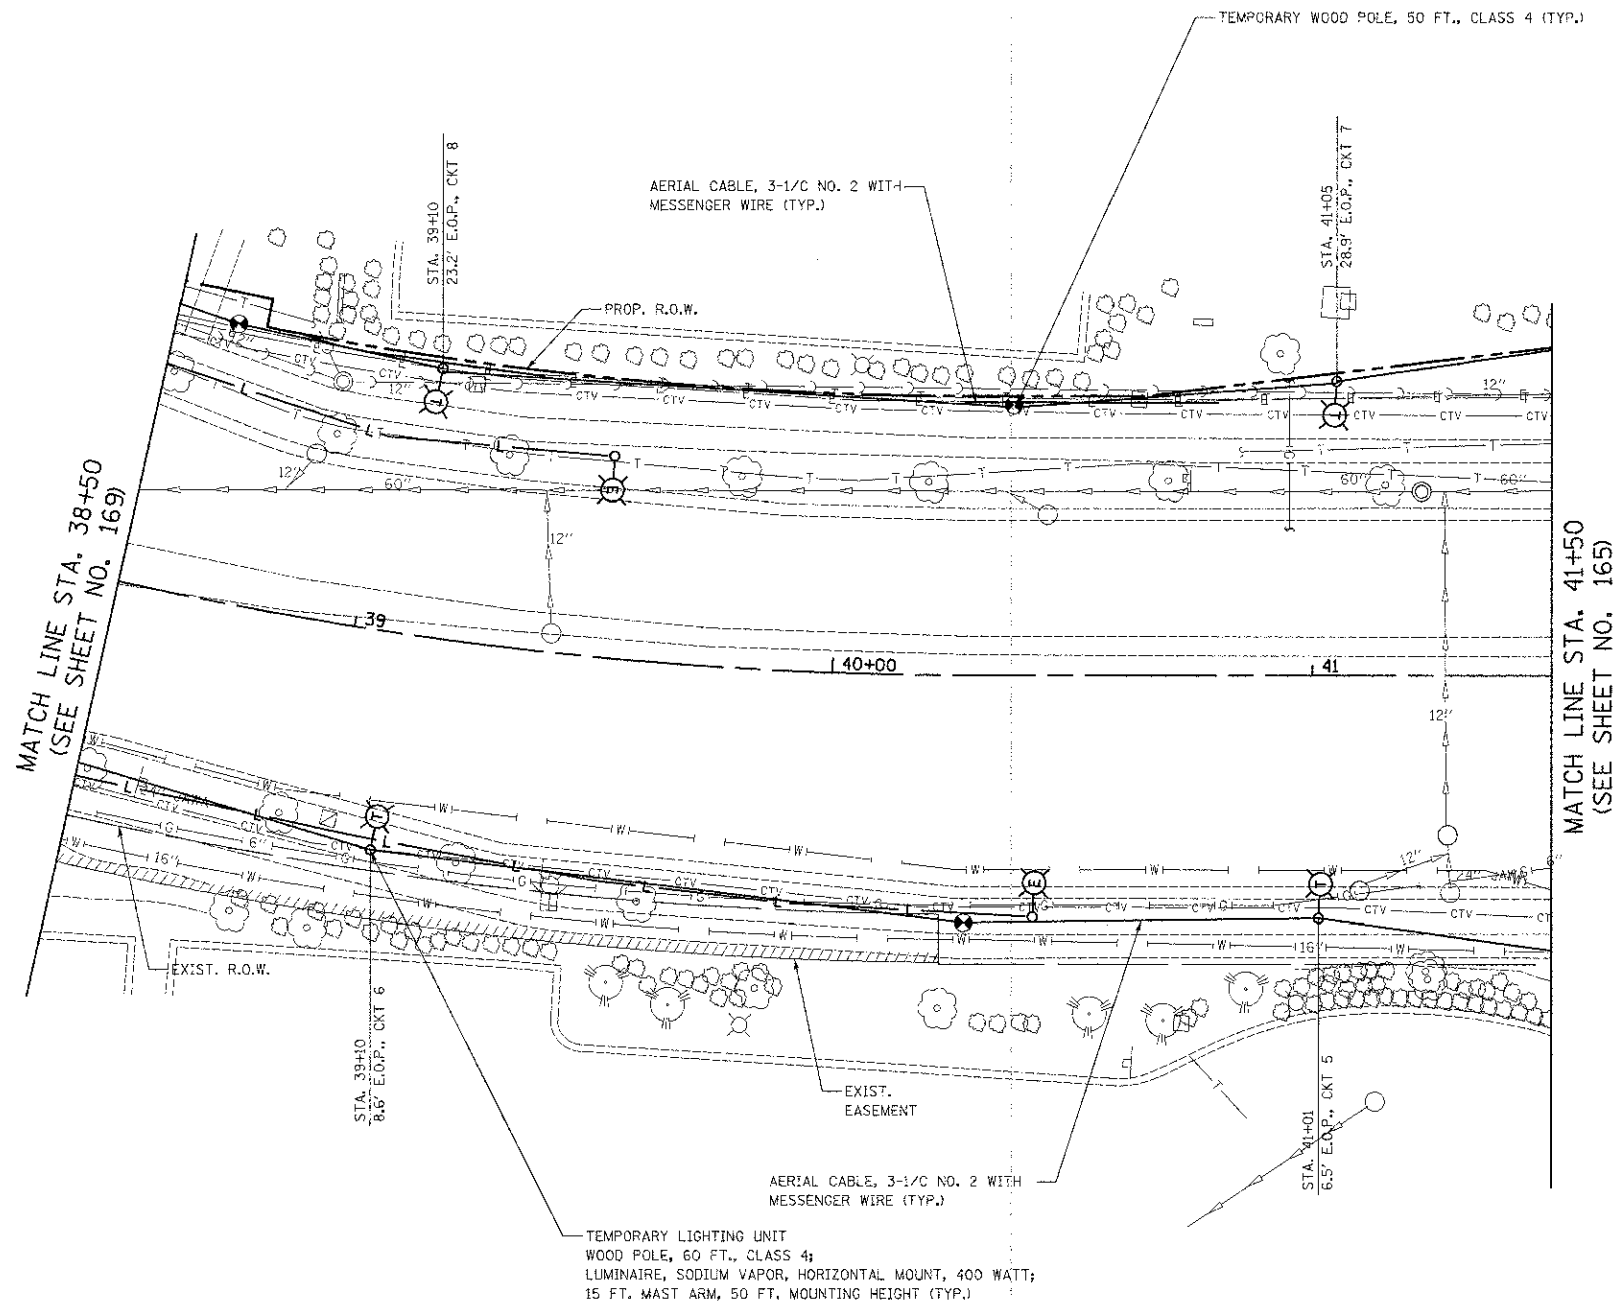

NOTES:

 1. TEMPORARY LIGHTING SHALL BE INSTALLED AND OPERATIONAL BEFORE DISCONNECTING AND REMOVING EXISTING LIGHTING UNITS.
2. TEMPORARY LIGHTING SHALL REMAIN OPERATIONAL UNTIL THE PROPOSED LIGHTING SYSTEM IS INSTALLED AND IS OPERATIONAL.



SCHAUMBURG ROAD

FILE NAME =	USER NAME = djk	DESIGNED - SJC	REVISED -	<b>STATE OF ILLINOIS DEPARTMENT OF TRANSPORTATION</b>	<b>SCHAUMBURG ROAD TEMPORARY LIGHTING PLANS</b>	F.A.I.D. RTE.	SECTION	COUNTY	TOTAL SHEETS	SHEET NO.
...sheet\2329_TEMP_LIGHT_06.dgn	PLOT SCALE = 20,0000' / in.	DRAWN - SJC	REVISED -			1322	01-00074-00-CH	COOK	245	170
PLOT DATE = 8/15/2012	DATE - 8-20-12	CHECKED - DNM	REVISED -			<b>CONTRACT NO. 63629</b>				
		DATE - 8-20-12	REVISED -			FED. ROAD DIST. NO. : ILLINOIS FED. AID PROJECT M-DMM-800305D				
				SCALE: 1" = 20'	SHEET NO. 8 OF 11 SHEETS	STA. 38+50 TO STA. 41+50				