



DATE	
BY	
REVISIONS	
NO.	DESCRIPTION
1	AS SHOWN
2	REVISIONS
3	REVISIONS
4	REVISIONS
100	REVISIONS

DATE	
BY	
REVISIONS	
NO.	DESCRIPTION
1	AS SHOWN
2	REVISIONS
3	REVISIONS
4	REVISIONS
100	REVISIONS

MATCH LINE STA. 49+50
(SEE SHEET NO. 171)

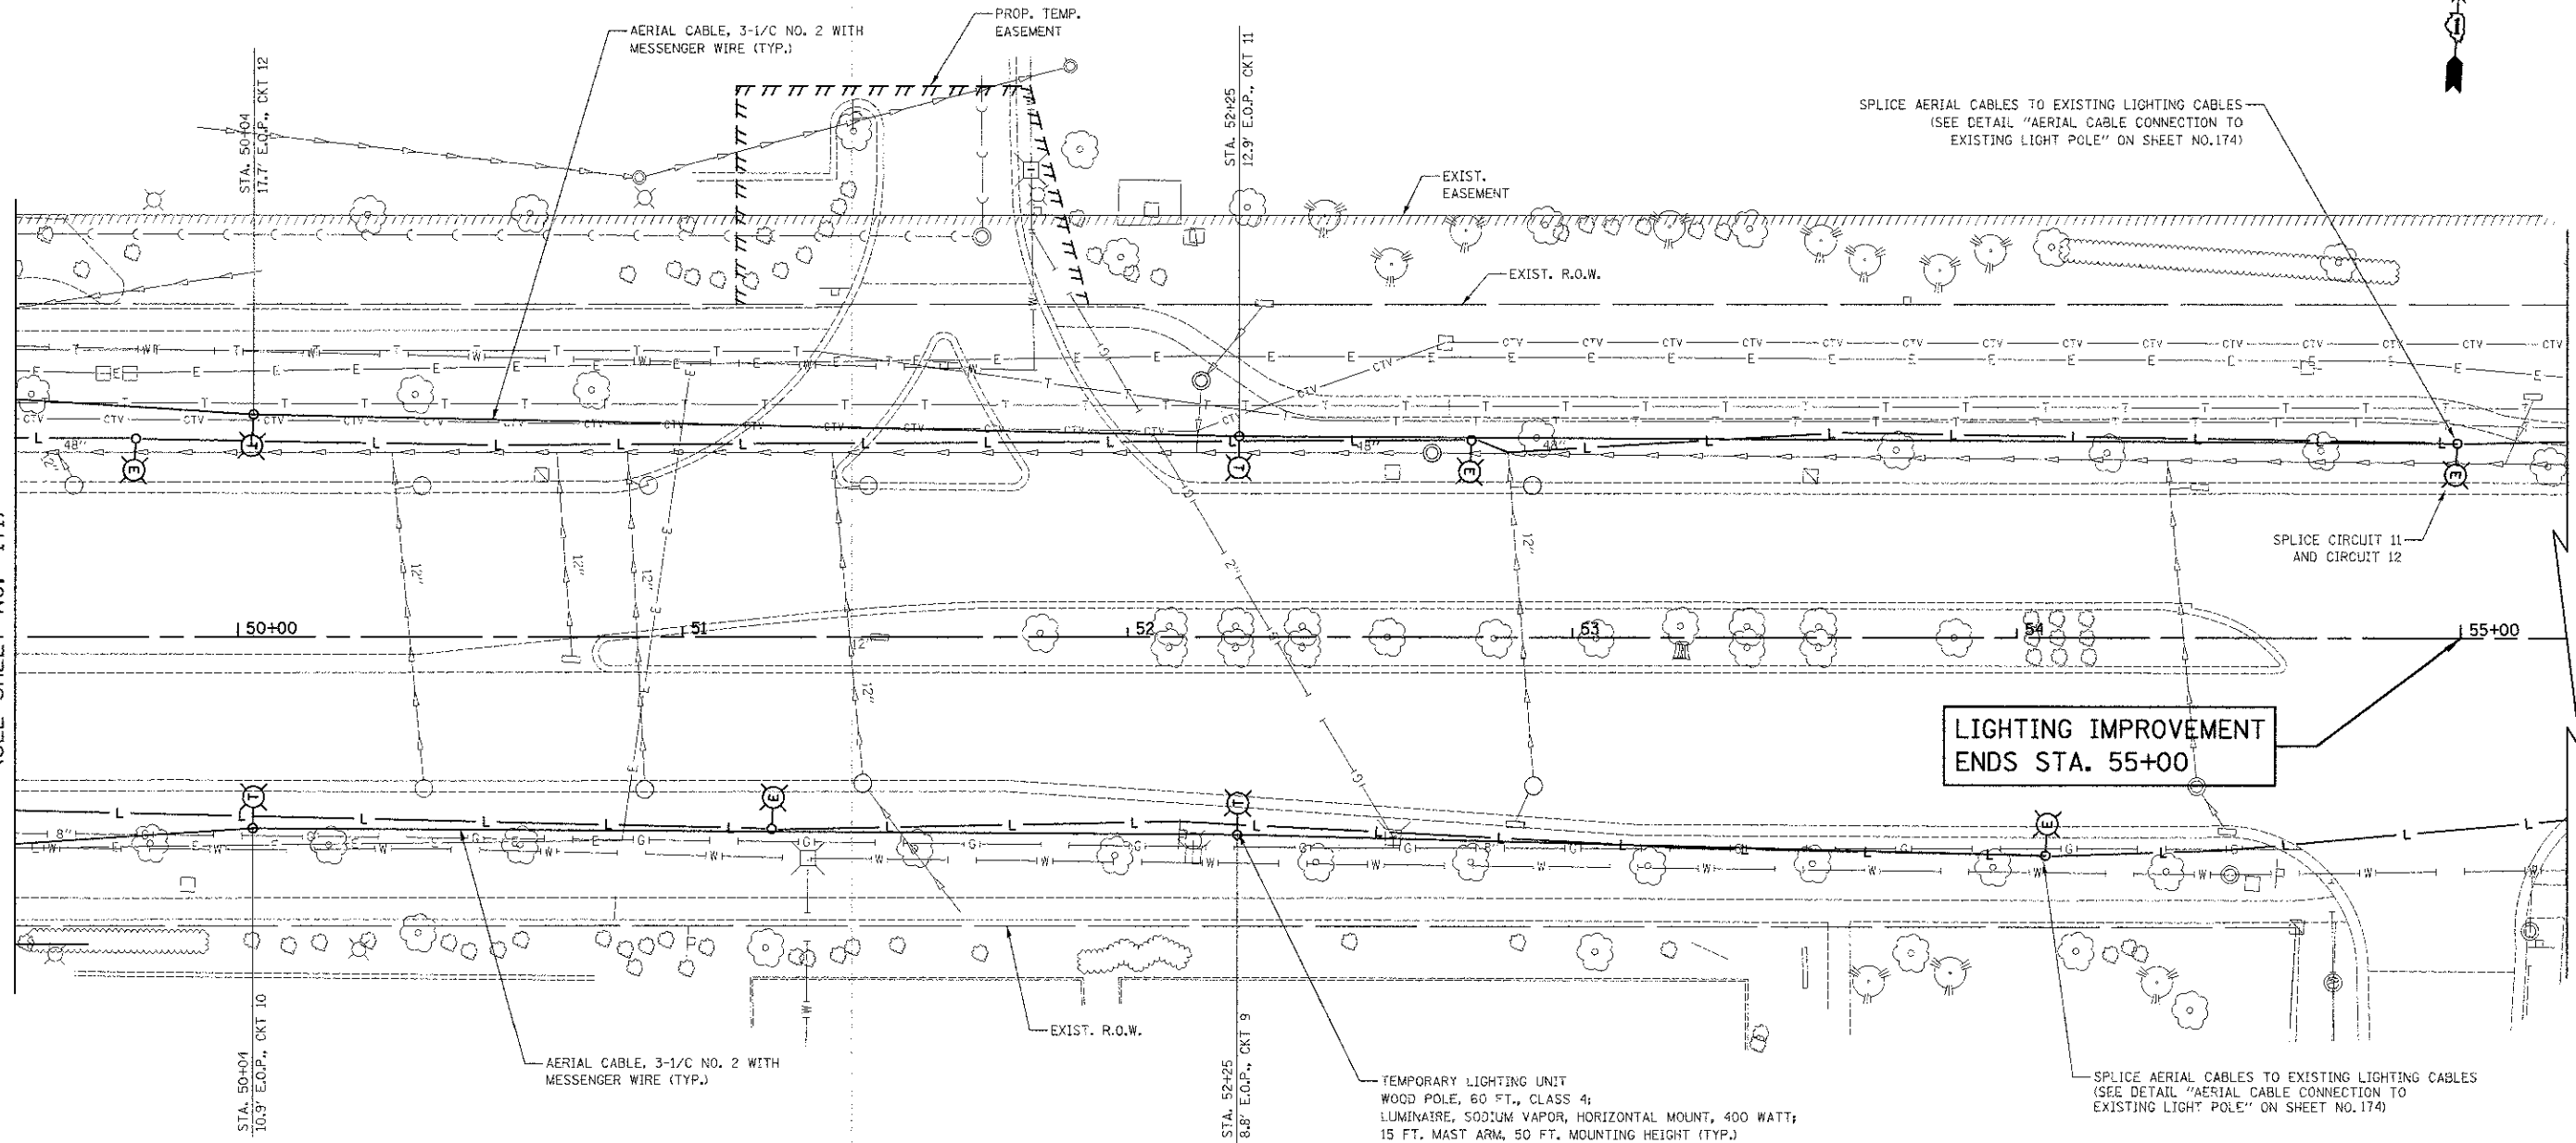

 LIGHTING IMPROVEMENT
ENDS STA. 55+00



SCHAUMBURG ROAD

- NOTES:
1. TEMPORARY LIGHTING SHALL BE INSTALLED AND OPERATIONAL BEFORE DISCONNECTING AND REMOVING EXISTING LIGHTING UNITS.
 2. TEMPORARY LIGHTING SHALL REMAIN OPERATIONAL UNTIL THE PROPOSED LIGHTING SYSTEM IS INSTALLED AND IS OPERATIONAL.

FILE NAME : ...sheet\2329_TEMP_LIGHT_18.dgn

USER NAME = djk
PLOT SCALE = 20.0000' / in.
PLOT DATE = 8/16/2012

DESIGNED - SJC
DRAWN - SJC
CHECKED - DNM
DATE - 8-20-12

REVISED -
REVISED -
REVISED -
REVISED -

STATE OF ILLINOIS
DEPARTMENT OF TRANSPORTATION

SCHAUMBURG ROAD
TEMPORARY LIGHTING PLANS

SCALE: 1" = 20' SHEET NO. 10 OF 11 SHEETS STA. 49+50 TO STA. 55+00

F.A.U. RTE.	SECTION	COUNTY	TOTAL SHEETS	SHEET NO.
1322	01-00074-00-CH	COOK	245	172
FED. ROAD DIST. NO. 1 (ILLINOIS) FED. AID PROJECT M-CM-8003(051)			CONTRACT NO. 63629	