


DATE	
BY	
NO. OF SHEETS	
NO. OF BOOKS	
NO. OF PAGES	
NO. OF SHEETS	
NO. OF BOOKS	
NO. OF PAGES	

DATE	
BY	
NO. OF SHEETS	
NO. OF BOOKS	
NO. OF PAGES	
NO. OF SHEETS	
NO. OF BOOKS	
NO. OF PAGES	

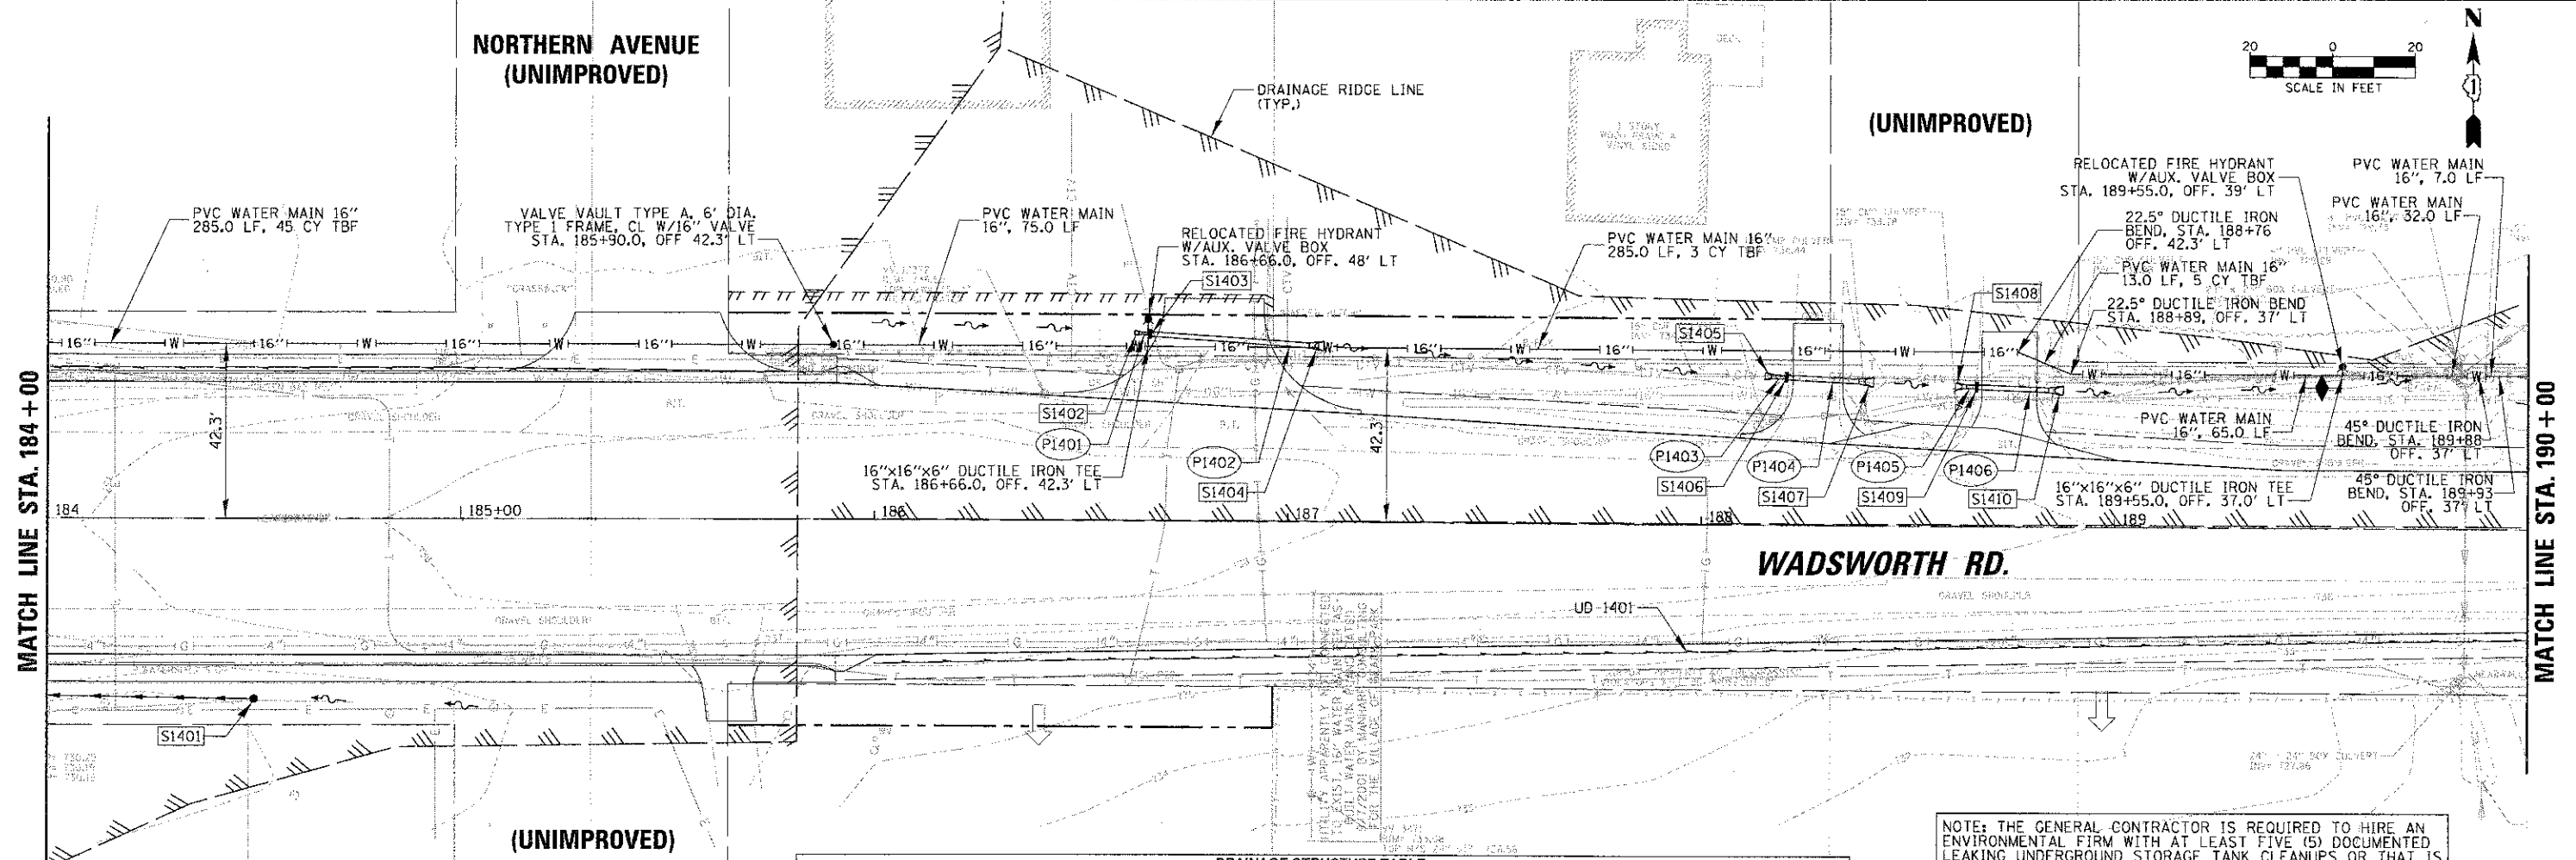


PIPE NO.	FROM	TO	LENGTH (FT)	DIA. (IN)	PIPE TYPE	SLOPE (%)	TBF (CY)
P1401	S1402	S1403	2	6	PC CLASS A TYPE 1	0.80	0
P1402	S1403	S1404	40	15	PC CLASS A TYPE 1	0.80	4.5
P1403	S1405	S1406	3	10	PC CLASS A TYPE 1	1.31	0
P1404	S1406	S1407	18	15	PC CLASS A TYPE 1	1.31	2.2
P1405	S1408	S1409	3	10	PC CLASS A TYPE 1	2.46	0
P1406	S1409	S1410	18	15	PC CLASS A TYPE 1	2.46	2.3

STRUCTURE NO.	STRUCTURE TYPE	STATION	OFFSET	RIM	INV (N)	INV (S)	INV (W)	INV (E)
S1401	CB, TYPE A, 4', TYPE 3 GRATE	184+50	43.7 RT	735.38			731.10	
S1402	CONCRETE HW FOR PIPE DRAINS, 6"	186+63	45.4 LT	-				733.78
S1403	IN, TYPE A, TYPE 1 FR. CL	186+66.5	45.3 LT	735.70			733.77	733.77
S1404	FLARED END SECTION, 15"	187+08	42.6 LT	-			733.46	-
S1405	FLARED END SECTION, 10"	188+15	38.1 LT	-				731.95
S1406	IN, TYPE A, TYPE 1 FR. CL	188+20.5	35.9 LT	734.50			731.92	731.92
S1407	FLARED END SECTION, 15"	188+41.5	34.7 LT	-			731.69	-
S1408	FLARED END SECTION, 10"	188+61.5	33.9 LT	-				731.46
S1409	IN, TYPE A, TYPE 1 FR. CL	188+66.5	33.8 LT	733.80			731.40	731.40
S1410	FLARED END SECTION, 15"	188+87.5	33.0 LT	-			730.98	-

NOTE: THE GENERAL CONTRACTOR IS REQUIRED TO HIRE AN ENVIRONMENTAL FIRM WITH AT LEAST FIVE (5) DOCUMENTED LEAKING UNDERGROUND STORAGE TANK CLEANUPS OR THAT IS PRE-QUALIFIED IN HAZARDOUS WASTE BY THE ILLINOIS DEPARTMENT OF TRANSPORTATION TO REMEDIATE THE SOIL CONTAMINATION AND MONITOR FOR WORKER PROTECTION.

SPD NO.	FROM STATION	OFFSET	TO STATION	OFFSET	LENGTH (FT)	LENGTH SP (FT)	DIA. (IN)
1401	186+00.00	34.86 RT	190+25.00	26.36 RT	425		4

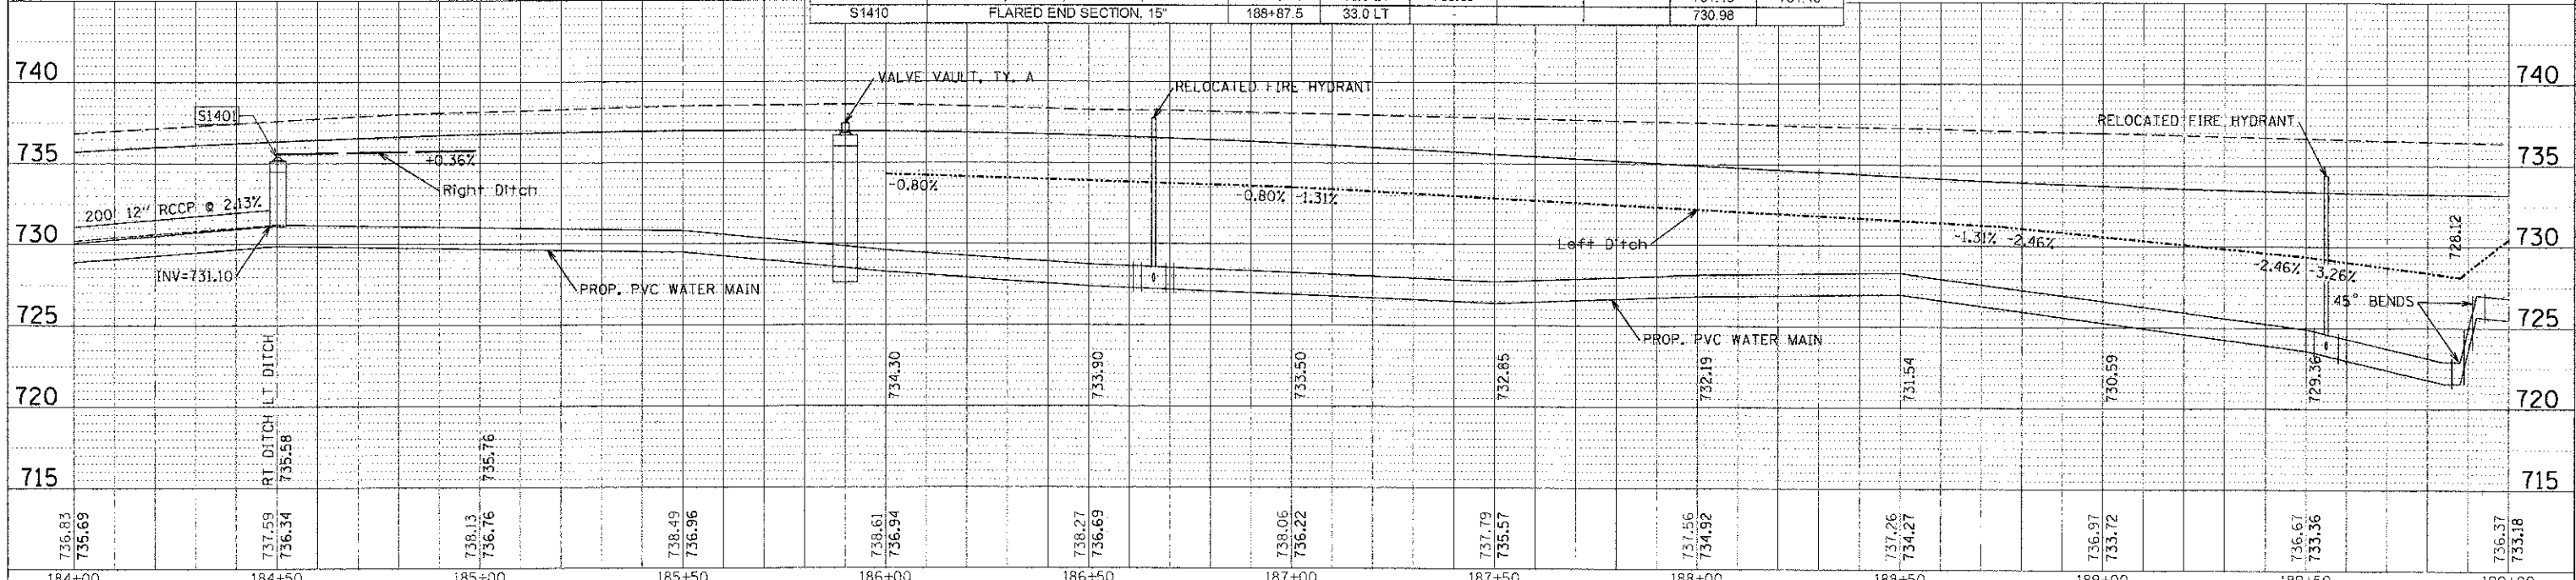

FILE NAME =	USFR NAME = pmmg11	DESIGNED -	REVISD -	STATE OF ILLINOIS DEPARTMENT OF TRANSPORTATION				WADSWORTH ROAD DRAINAGE AND UTILITIES PLAN AND PROFILE STA. 184 + 00.00 TO STA. 190 + 00.00				F.A.U. R.T.E. =	SECTION =	COUNTY =	TOTAL SHEETS =		
PLAN SCALE = 20'	CHECKED -	REVISD -	NO. =									1209	03-00033-12-CH	LAKE	189	74	
PLST DATE = 1/23/2013	DATE -	REVISD -	NO. =									SCALE: SHEET NO. OF SHEETS STA. TO STA.				FED. ROAD DIST. NO. 1 ILLINOIS FED. AID PROJECT	
												CONTRACT NO. 63766					