


DATE	
BY	
REVIEWED	
PLANNED	
ALIGNED	
CHECKED	
NOTE BOOK	
NO.	
FILE NAME	

DATE	
BY	
REVIEWED	
PLANNED	
CHECKED	
NOTE BOOK	
NO.	
FILE NAME	

MATCH LINE STA. 228 + 00

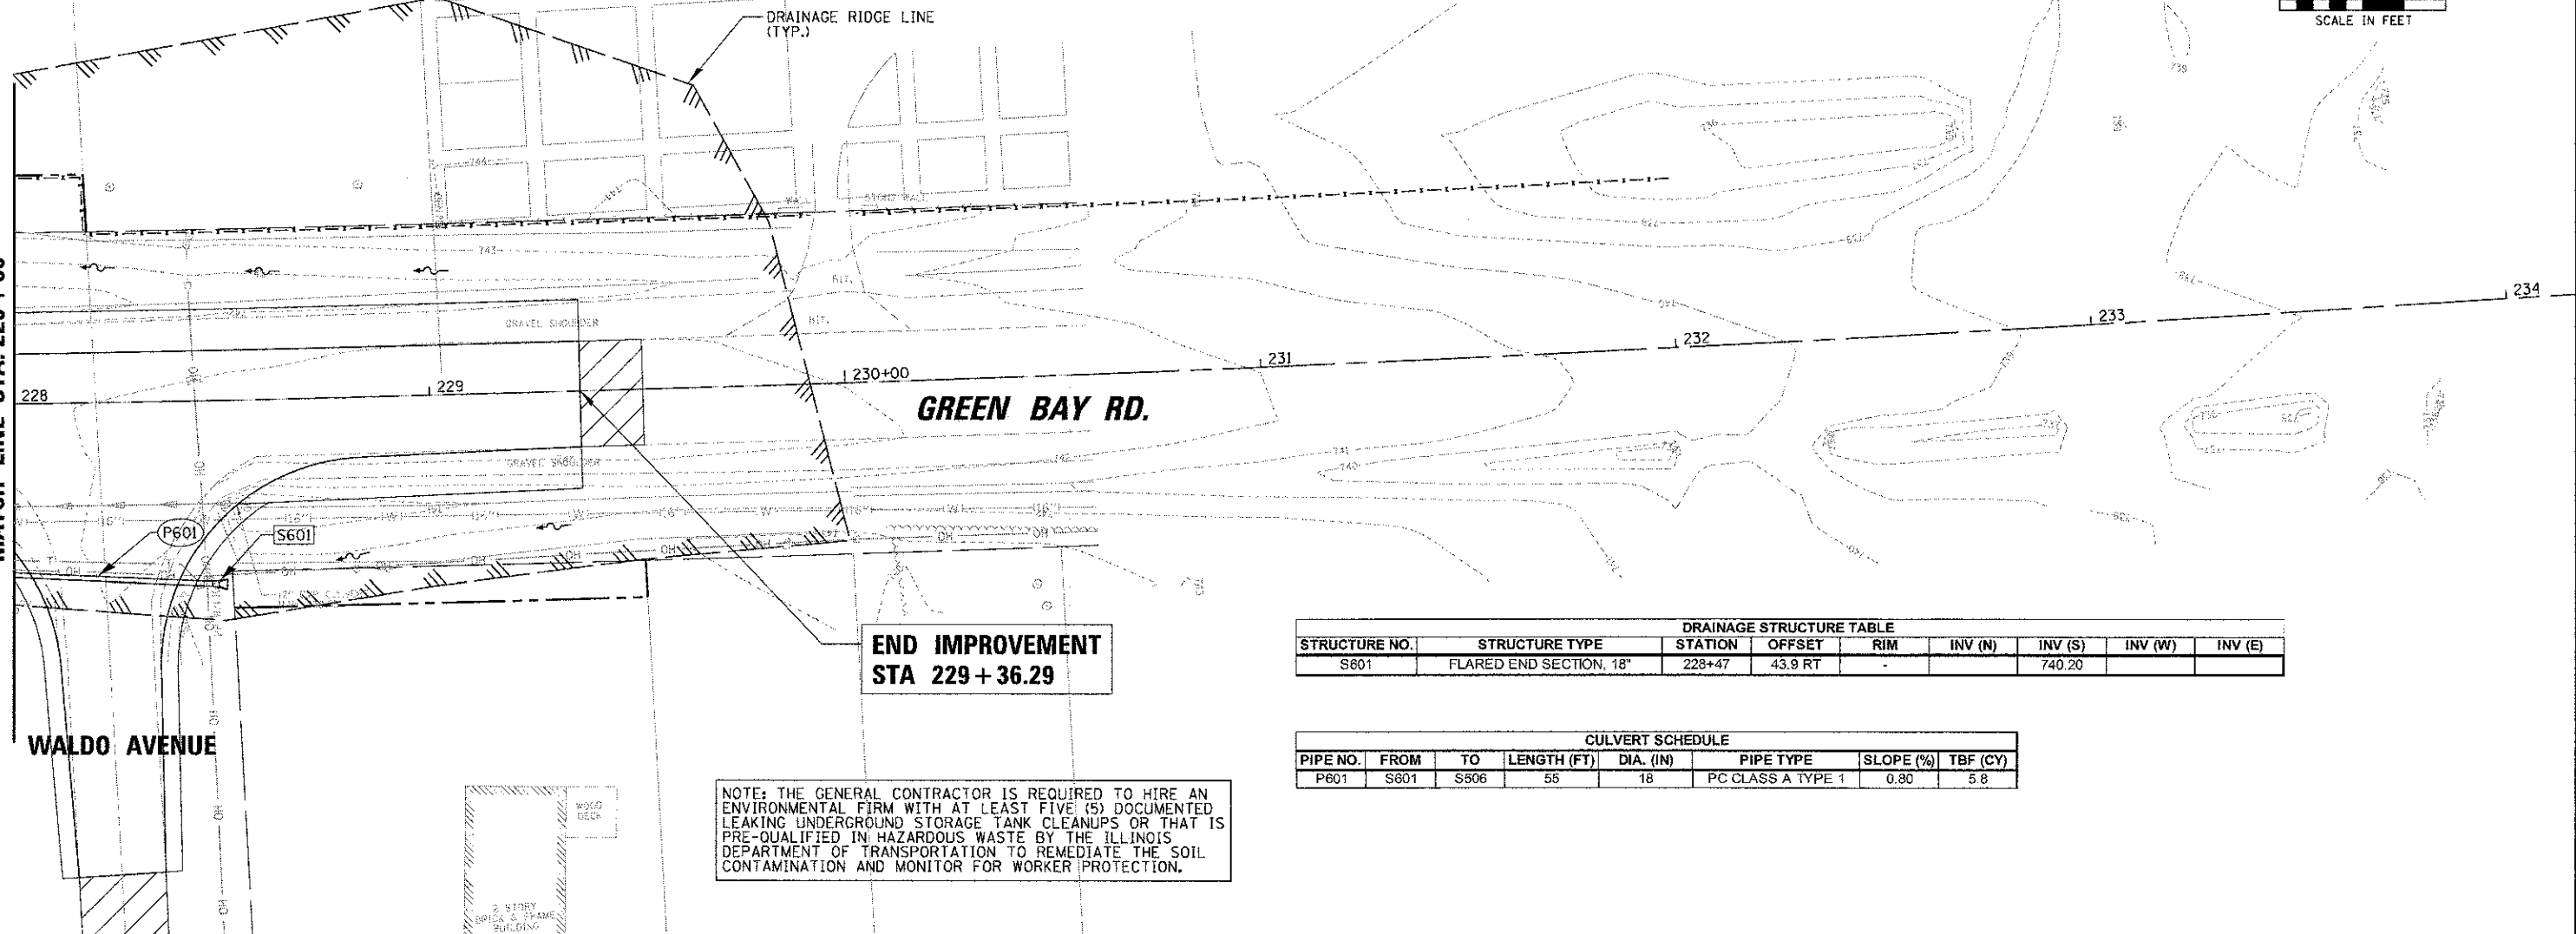


**END IMPROVEMENT  
STA 229 + 36.29**

NOTE: THE GENERAL CONTRACTOR IS REQUIRED TO HIRE AN ENVIRONMENTAL FIRM WITH AT LEAST FIVE (5) DOCUMENTED LEAKING UNDERGROUND STORAGE TANK CLEANUPS OR THAT IS PRE-QUALIFIED IN HAZARDOUS WASTE BY THE ILLINOIS DEPARTMENT OF TRANSPORTATION TO REMEDIATE THE SOIL CONTAMINATION AND MONITOR FOR WORKER PROTECTION.

DRAINAGE STRUCTURE TABLE								
STRUCTURE NO.	STRUCTURE TYPE	STATION	OFFSET	RIM	INV (N)	INV (S)	INV (W)	INV (E)
S801	FLARED END SECTION, 18"	228+47	43.9 RT	-		740.20		

CULVERT SCHEDULE							
PIPE NO.	FROM	TO	LENGTH (FT)	DIA. (IN)	PIPE TYPE	SLOPE (%)	TBF (CY)
P601	S601	S506	55	18	PC CLASS A TYPE 1	0.80	5.8

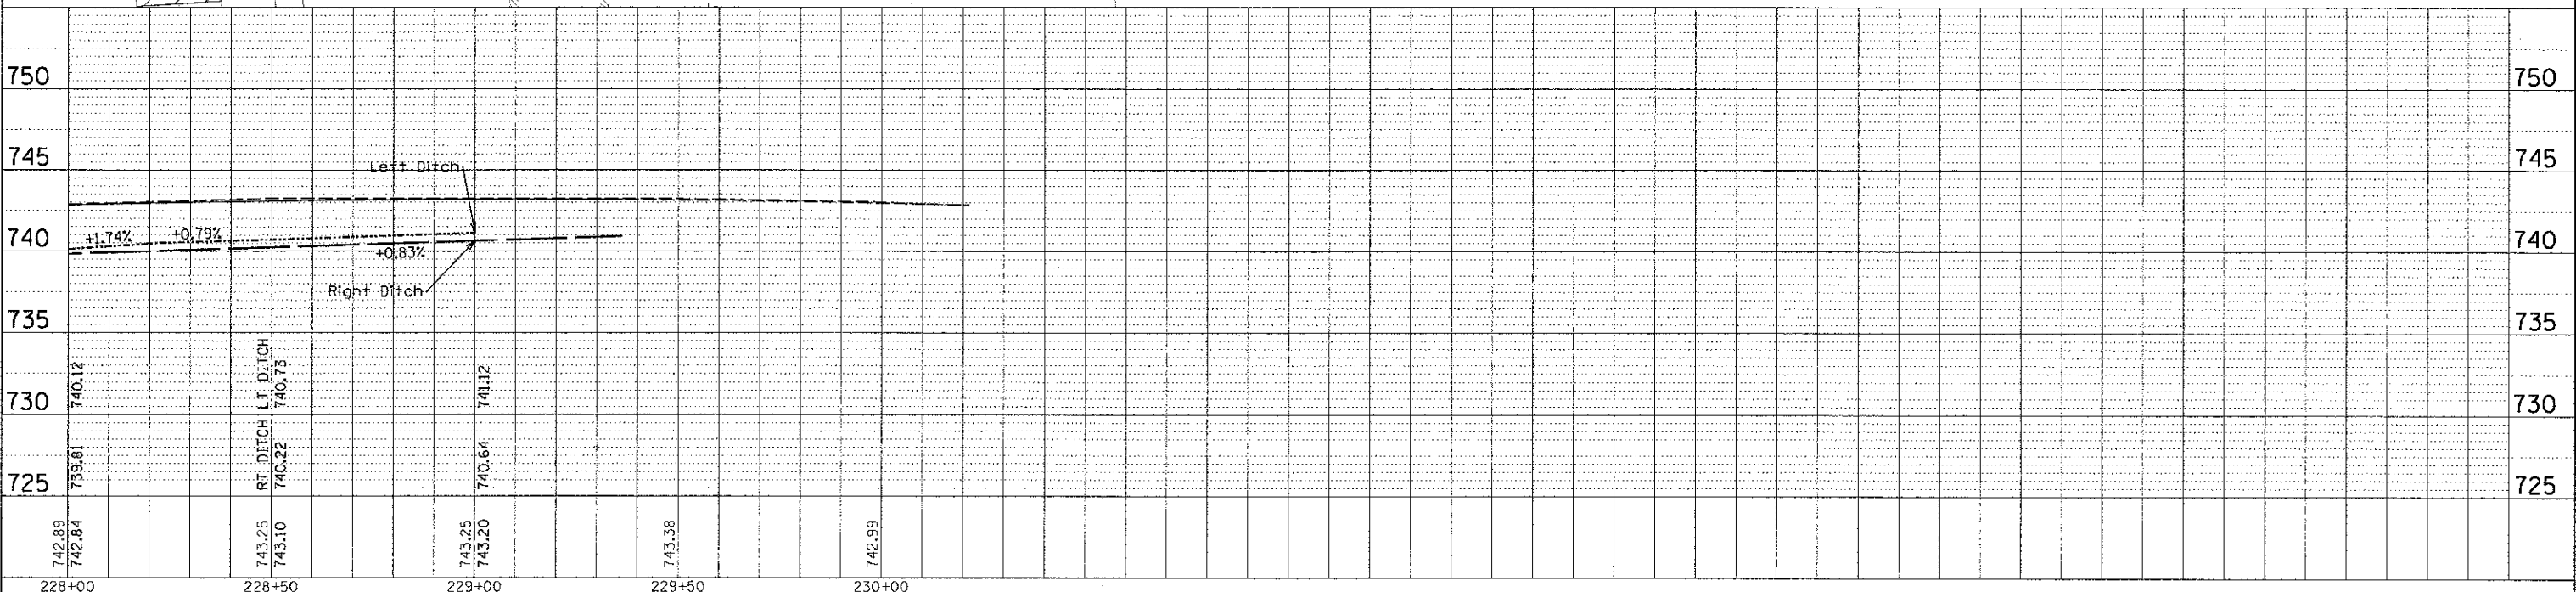

FILE NAME: \\N:\C007\04229\03\DRN\RT131_05.SHT	USER NAME: nborai	DESIGNED -	REVISOR -	<b>STATE OF ILLINOIS DEPARTMENT OF TRANSPORTATION</b>	<b>IL RTE 131 (GREEN BAY ROAD) DRAINAGE AND UTILITIES PLAN AND PROFILE STA. 228 + 00.00 TO STA. 229 + 36.29</b>	F.A. RTE. 1209	SECTION 03-00033-12-CH	COUNTY LAKE	TOTAL SHEETS 189	SHEET NO. 81	CONTRACT NO. 63766
PLOT SCALE = 20'	PLOT DATE = 1/22/2013	DRAWN -	REVISOR -			SCALE:	SHEET NO. OF SHEETS	STA. TO STA.	FED. ROAD DIST. NO. 1	ILLINOIS FED. AID PROJECT	
		CHECKED -	REVISOR -								
		DATE -	REVISOR -								