



SEC 13, T 6 N, R 3 W, 4th PM

AFC ILLINOIS II, LLC

PLAN	SURVEYED	BY	DATE
	PLOTTED		
	CHECKED		
	ALIGNED		
	FILE NAME		
	NO.		

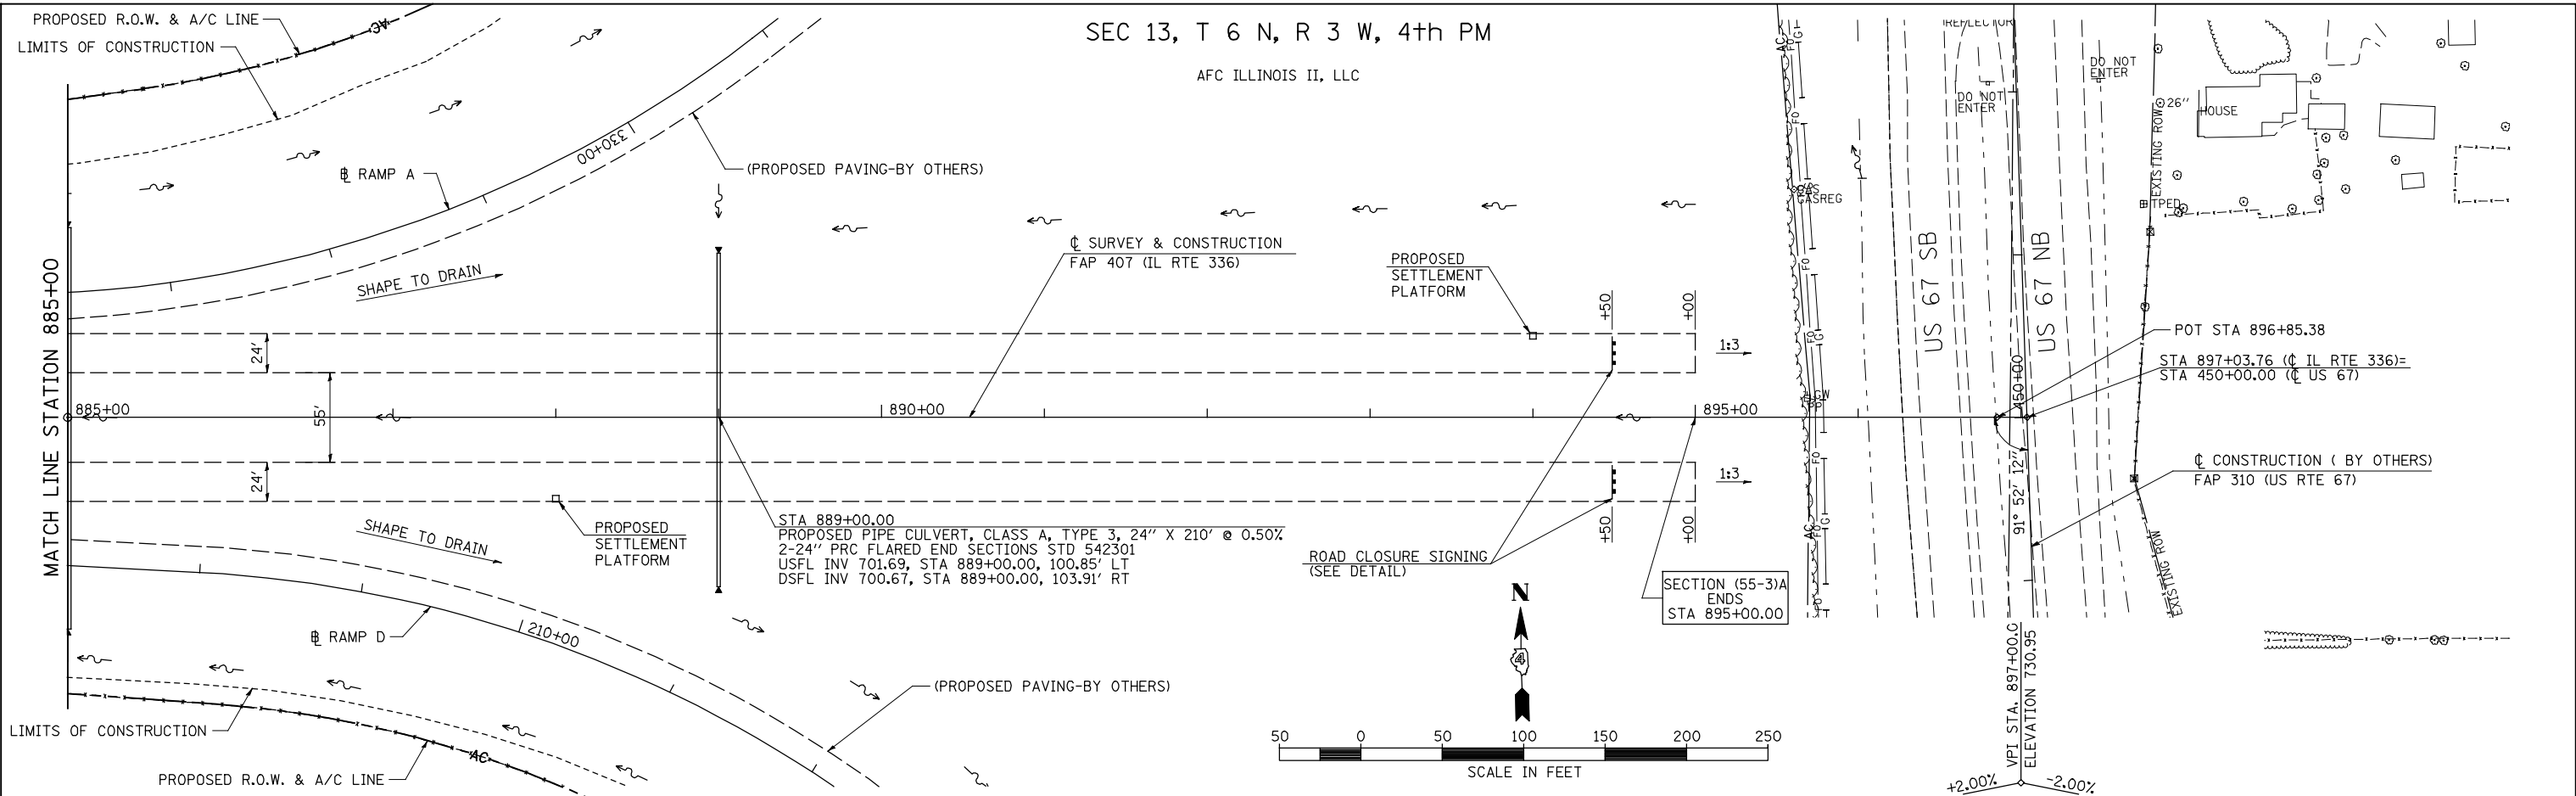

PROFILE	SURVEYED	BY	DATE
	PLOTTED		
	CHECKED		
	GRADES		
	STRUCTURE		
	NOTATIS		
	CHRD		
	NO.		

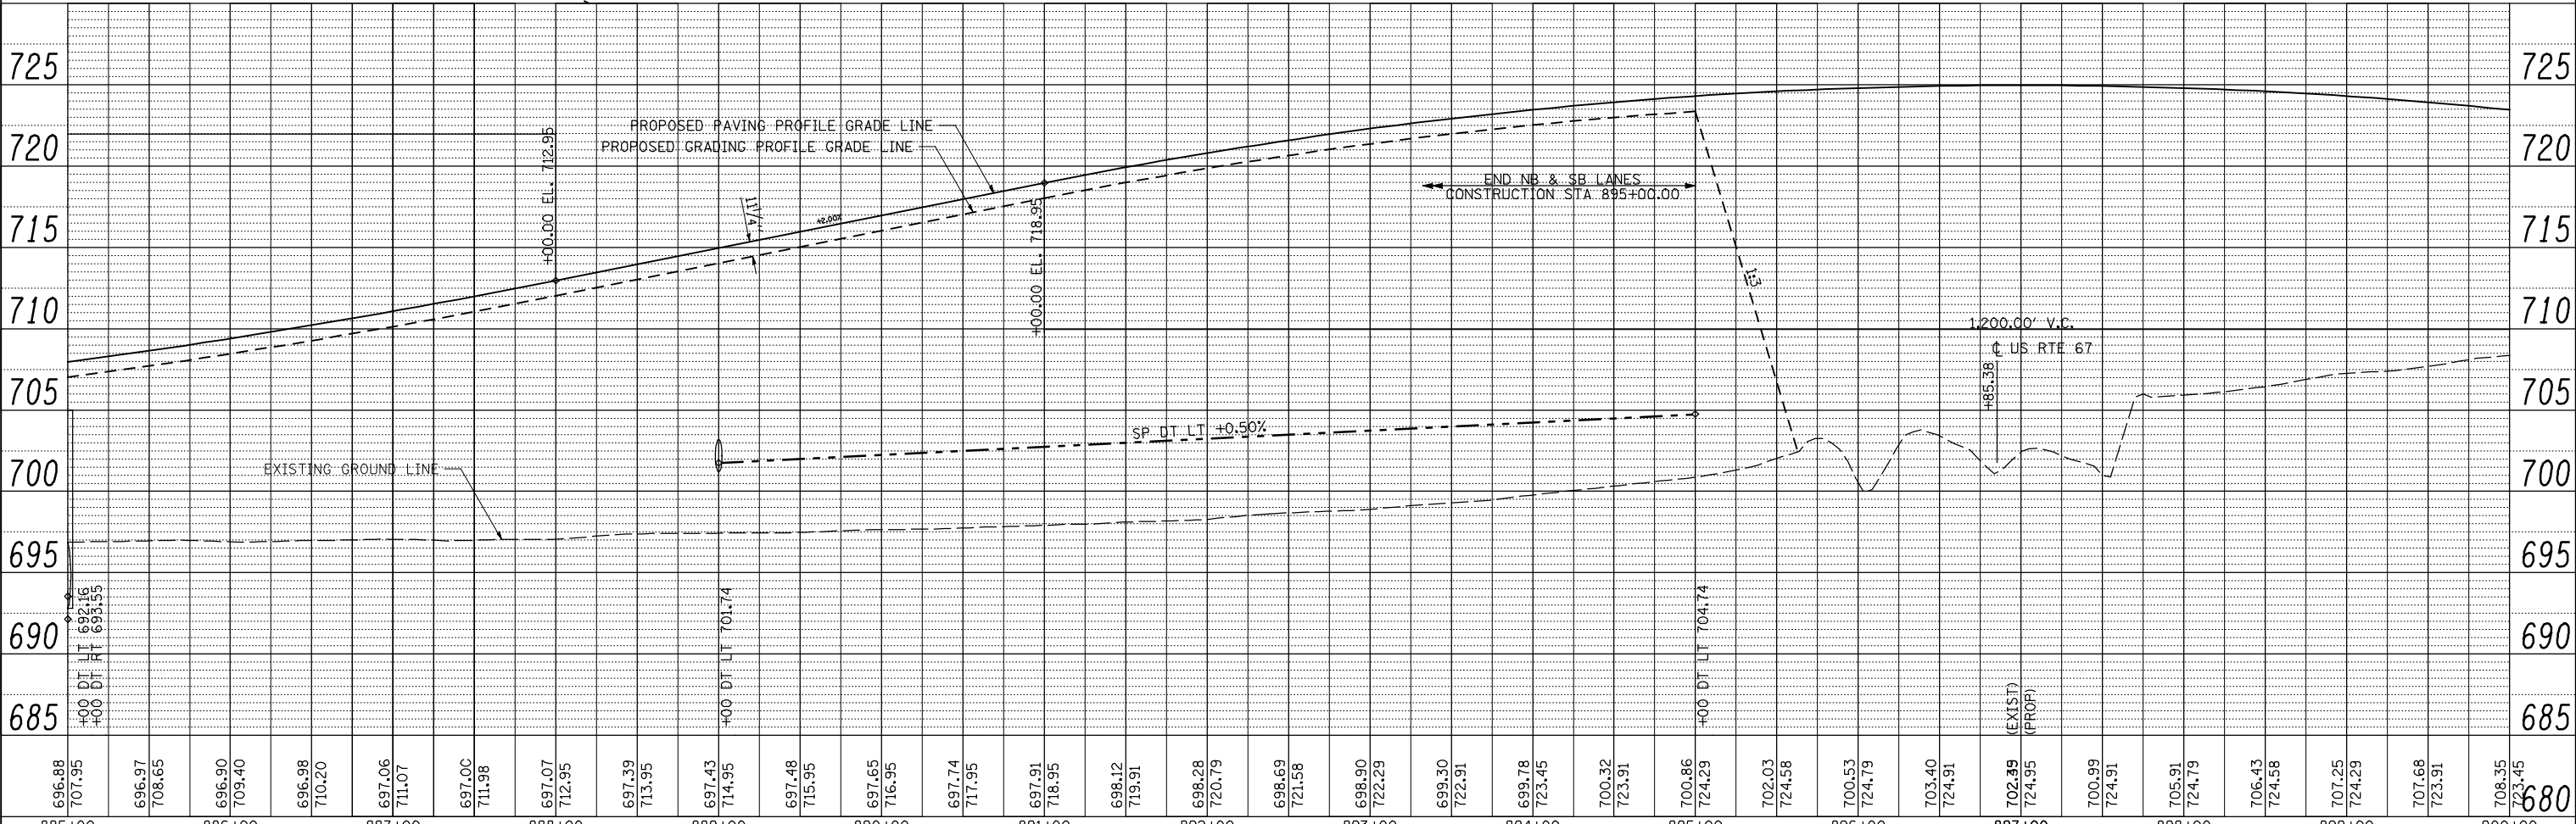

FILE NAME =	USER NAME = jdeen	DESIGNED - JRB	REVISED -
V:\transportation\2891\Grading Plans\2891D25.dgn		DRAWN - RLR	REVISED -
PLOT SCALE = 1/8" = 1' / IN.		CHECKED - AWM	REVISED -
PLOT DATE = 12/12/2012		DATE - 12-12-12	REVISED -

STATE OF ILLINOIS
DEPARTMENT OF TRANSPORTATION

FAP 407 (IL RTE 336)
GRADING & DRAINAGE PLAN & PROFILE
STATION 885+00 TO STATION 895+00

F.A.P. RTE.	SECTION	COUNTY	TOTAL SHEETS	SHEET NO.
407	(55-3)A	McDONOUGH	671	143
			CONTRACT NO. 68A42	

SCALE: 1"=50' SHEET NO. 37 OF 37 SHEETS STA. 885+00 TO STA. 895+00

ILLINOIS FED. AID PROJECT