

 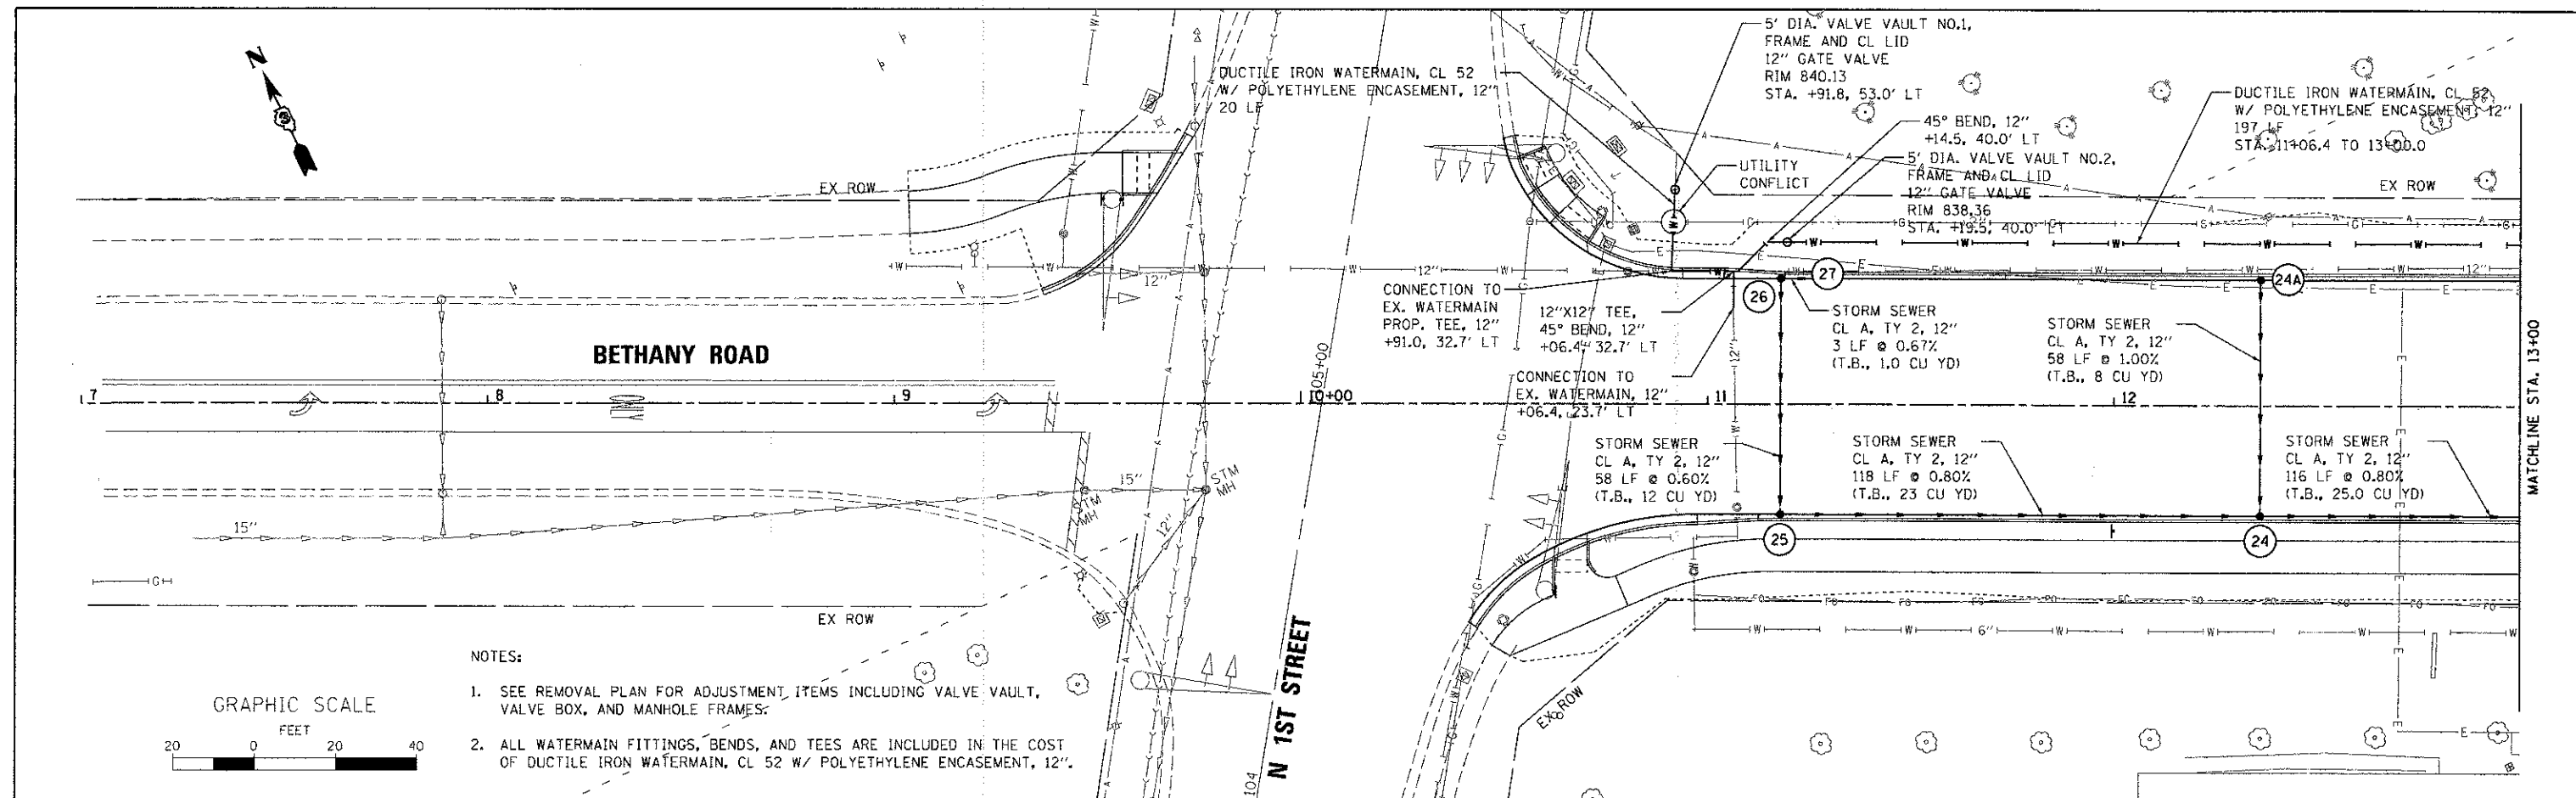


PLAN	SURVEYED	DATE
	PLOTTED	
	CHECKED	
	BY	
	NO.	
	FILE NAME	

PROFILE	SURVEYED	DATE
	PLOTTED	
	CHECKED	
	BY	
	NO.	
	FILE NAME	

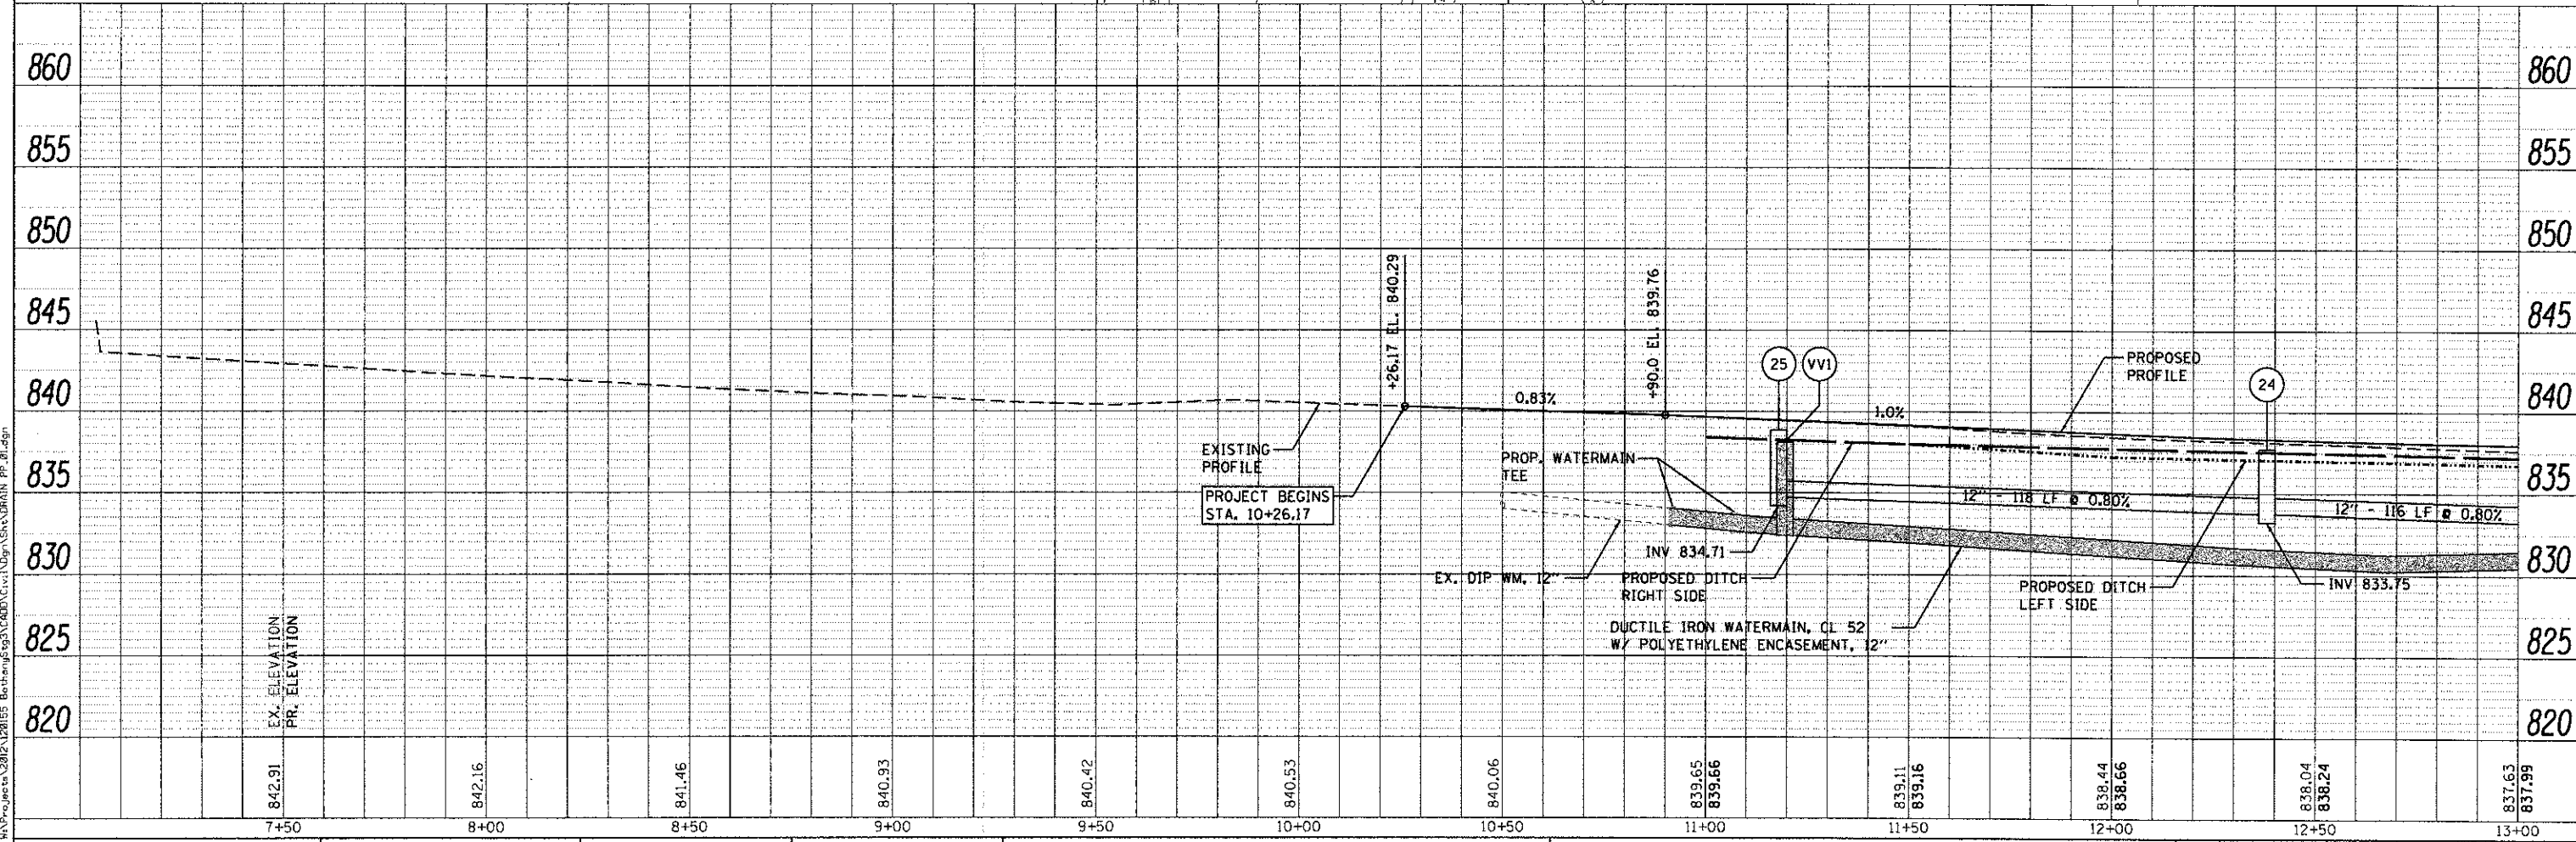

- NOTES:
- SEE REMOVAL PLAN FOR ADJUSTMENT ITEMS INCLUDING VALVE VAULT, VALVE BOX, AND MANHOLE FRAMES.
 - ALL WATERMAIN FITTINGS, BENDS, AND TEES ARE INCLUDED IN THE COST OF DUCTILE IRON WATERMAIN, CL 52 W/ POLYETHYLENE ENCASUREMENT, 12\".



WILLS BURKE KELSEY ASSOCIATES LTD 116 West Main Street, Suite 201 St. Charles, Illinois 60174	USER NAME = mparris	DESIGNED - JWW	REVISED -	STATE OF ILLINOIS DEPARTMENT OF TRANSPORTATION	DRAINAGE AND UTILITY PLAN & PROFILE	F.A.U. RTE. 5355	SECTION 10-00167-01-WR	COUNTY DEKALB	TOTAL SHEETS 78	SHEET NO. 42		
	PLOT SCALE = 1:20	DRAWN - NDP	REVISED -			SCALE: 1"=20'	SHEET NO. 1 OF 5 SHEETS	STA. 10+26.17 TO STA. 13+00.00	CONTRACT NO. 87544			
	PLOT DATE = 12/20/2012	CHECKED - DPB	REVISED -			ILLINOIS FED. AID PROJECT						