
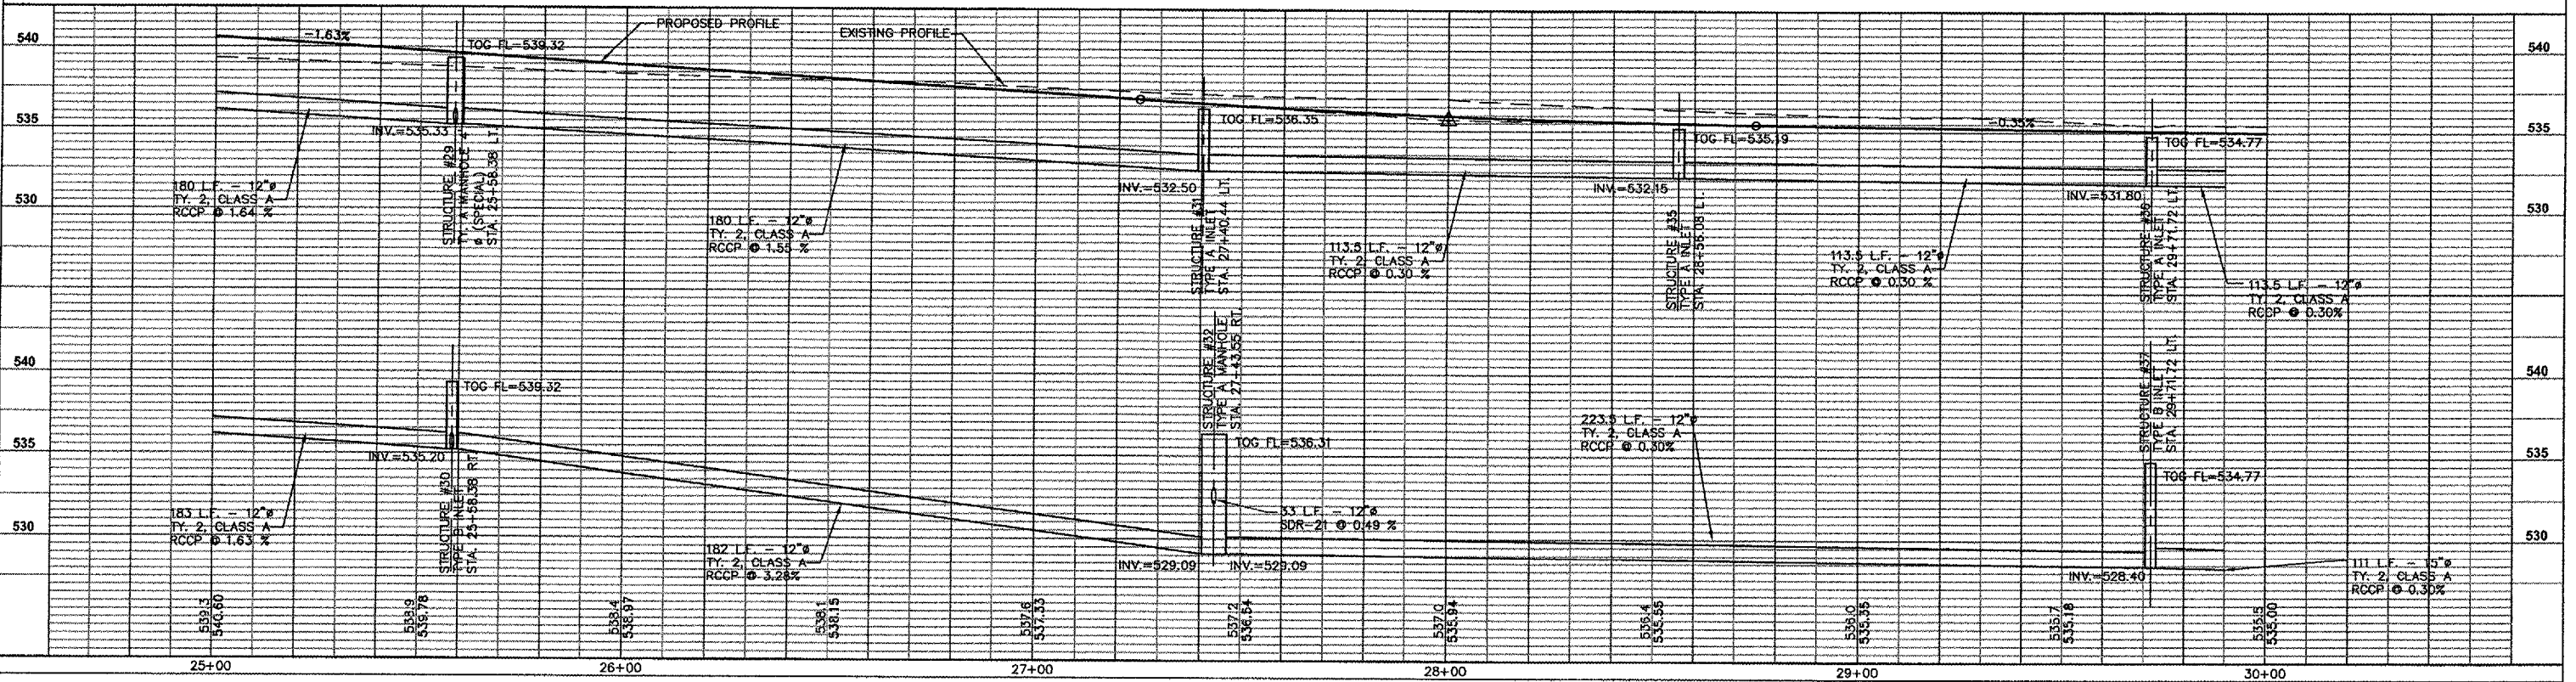


PROJECT NO.	SECTION	COUNTY	TOTAL SHEETS	SHEET NO.
9397	01-00022-00-RP	MADISON	72	32
STA. 25+00 TO STA. 30+00		DRAINAGE PLAN AND PROFILE		

CONTRACT NO. 97269

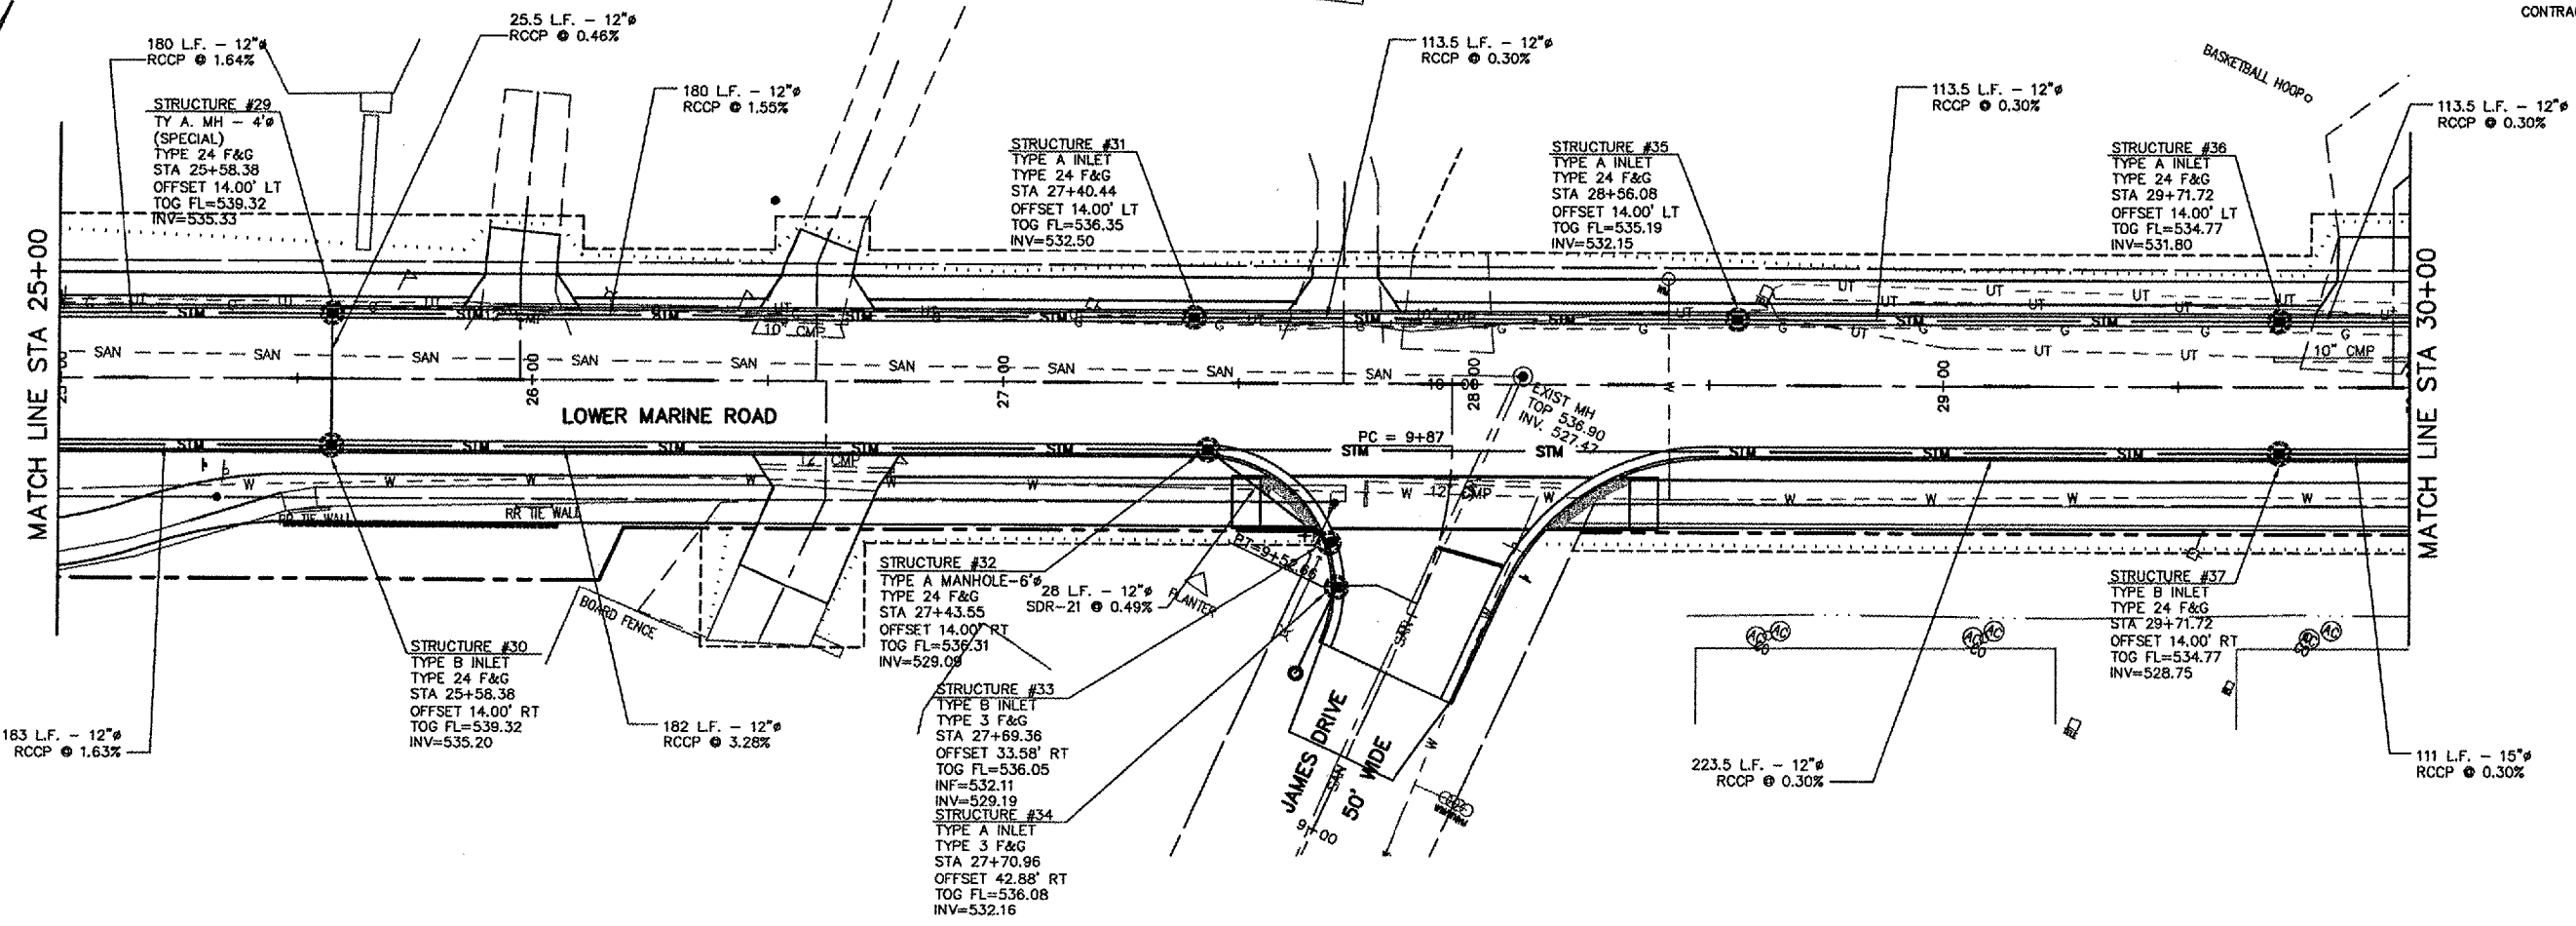

P:\00139a.dwg_000139AK04.dwg 11/21/2005 4:44:55 PM CST