 



CA002
 K:\Springfield\0503507\Draw\Sheets
 FILE: 52_ELECO2.dwg
 UPDATE BY: Dove Allen
 PLOT DATE: 2/6/2006 4:40 PM
 BASE_PROPGEO
 BASE_EXISTTOPO
 KEY
 BASE_PROPELEC
 tbinfo


REVISIONS		
NUMBER	BY	DATE




- LEGEND**
- EXISTING STAKE MOUNTED TAXIWAY LIGHT
 - EXISTING BASE MOUNTED RUNWAY LIGHT
 - ⊠ EXISTING BASE MOUNTED TAXIWAY LIGHT
 - ▣ NEW BASE MOUNTED TAXIWAY LIGHT
 - ⊙ EXISTING FLUSH MOUNTED RUNWAY EDGE LIGHT
 - RP ▭ EXISTING AIRFIELD SIGN (SIGN PANELS TO BE REPLACED)
 - ▭ NEW AIRFIELD SIGN
 - ⊕ EXIST. SPLICE CAN
 - NEW SPLICE CAN
 - ▭ EXISTING DUCT BANK
 - ▭ NEW DUCT BANK
 - ▭ NEW 4" SPLIT DUCT
 - EXISTING CABLE
 - NEW CIRCUIT #3
 - NEW CIRCUIT #7
 - EXISTING TELEPHONE CABLE
 - EXISTING ILS FAA CABLE
 - R REMOVE

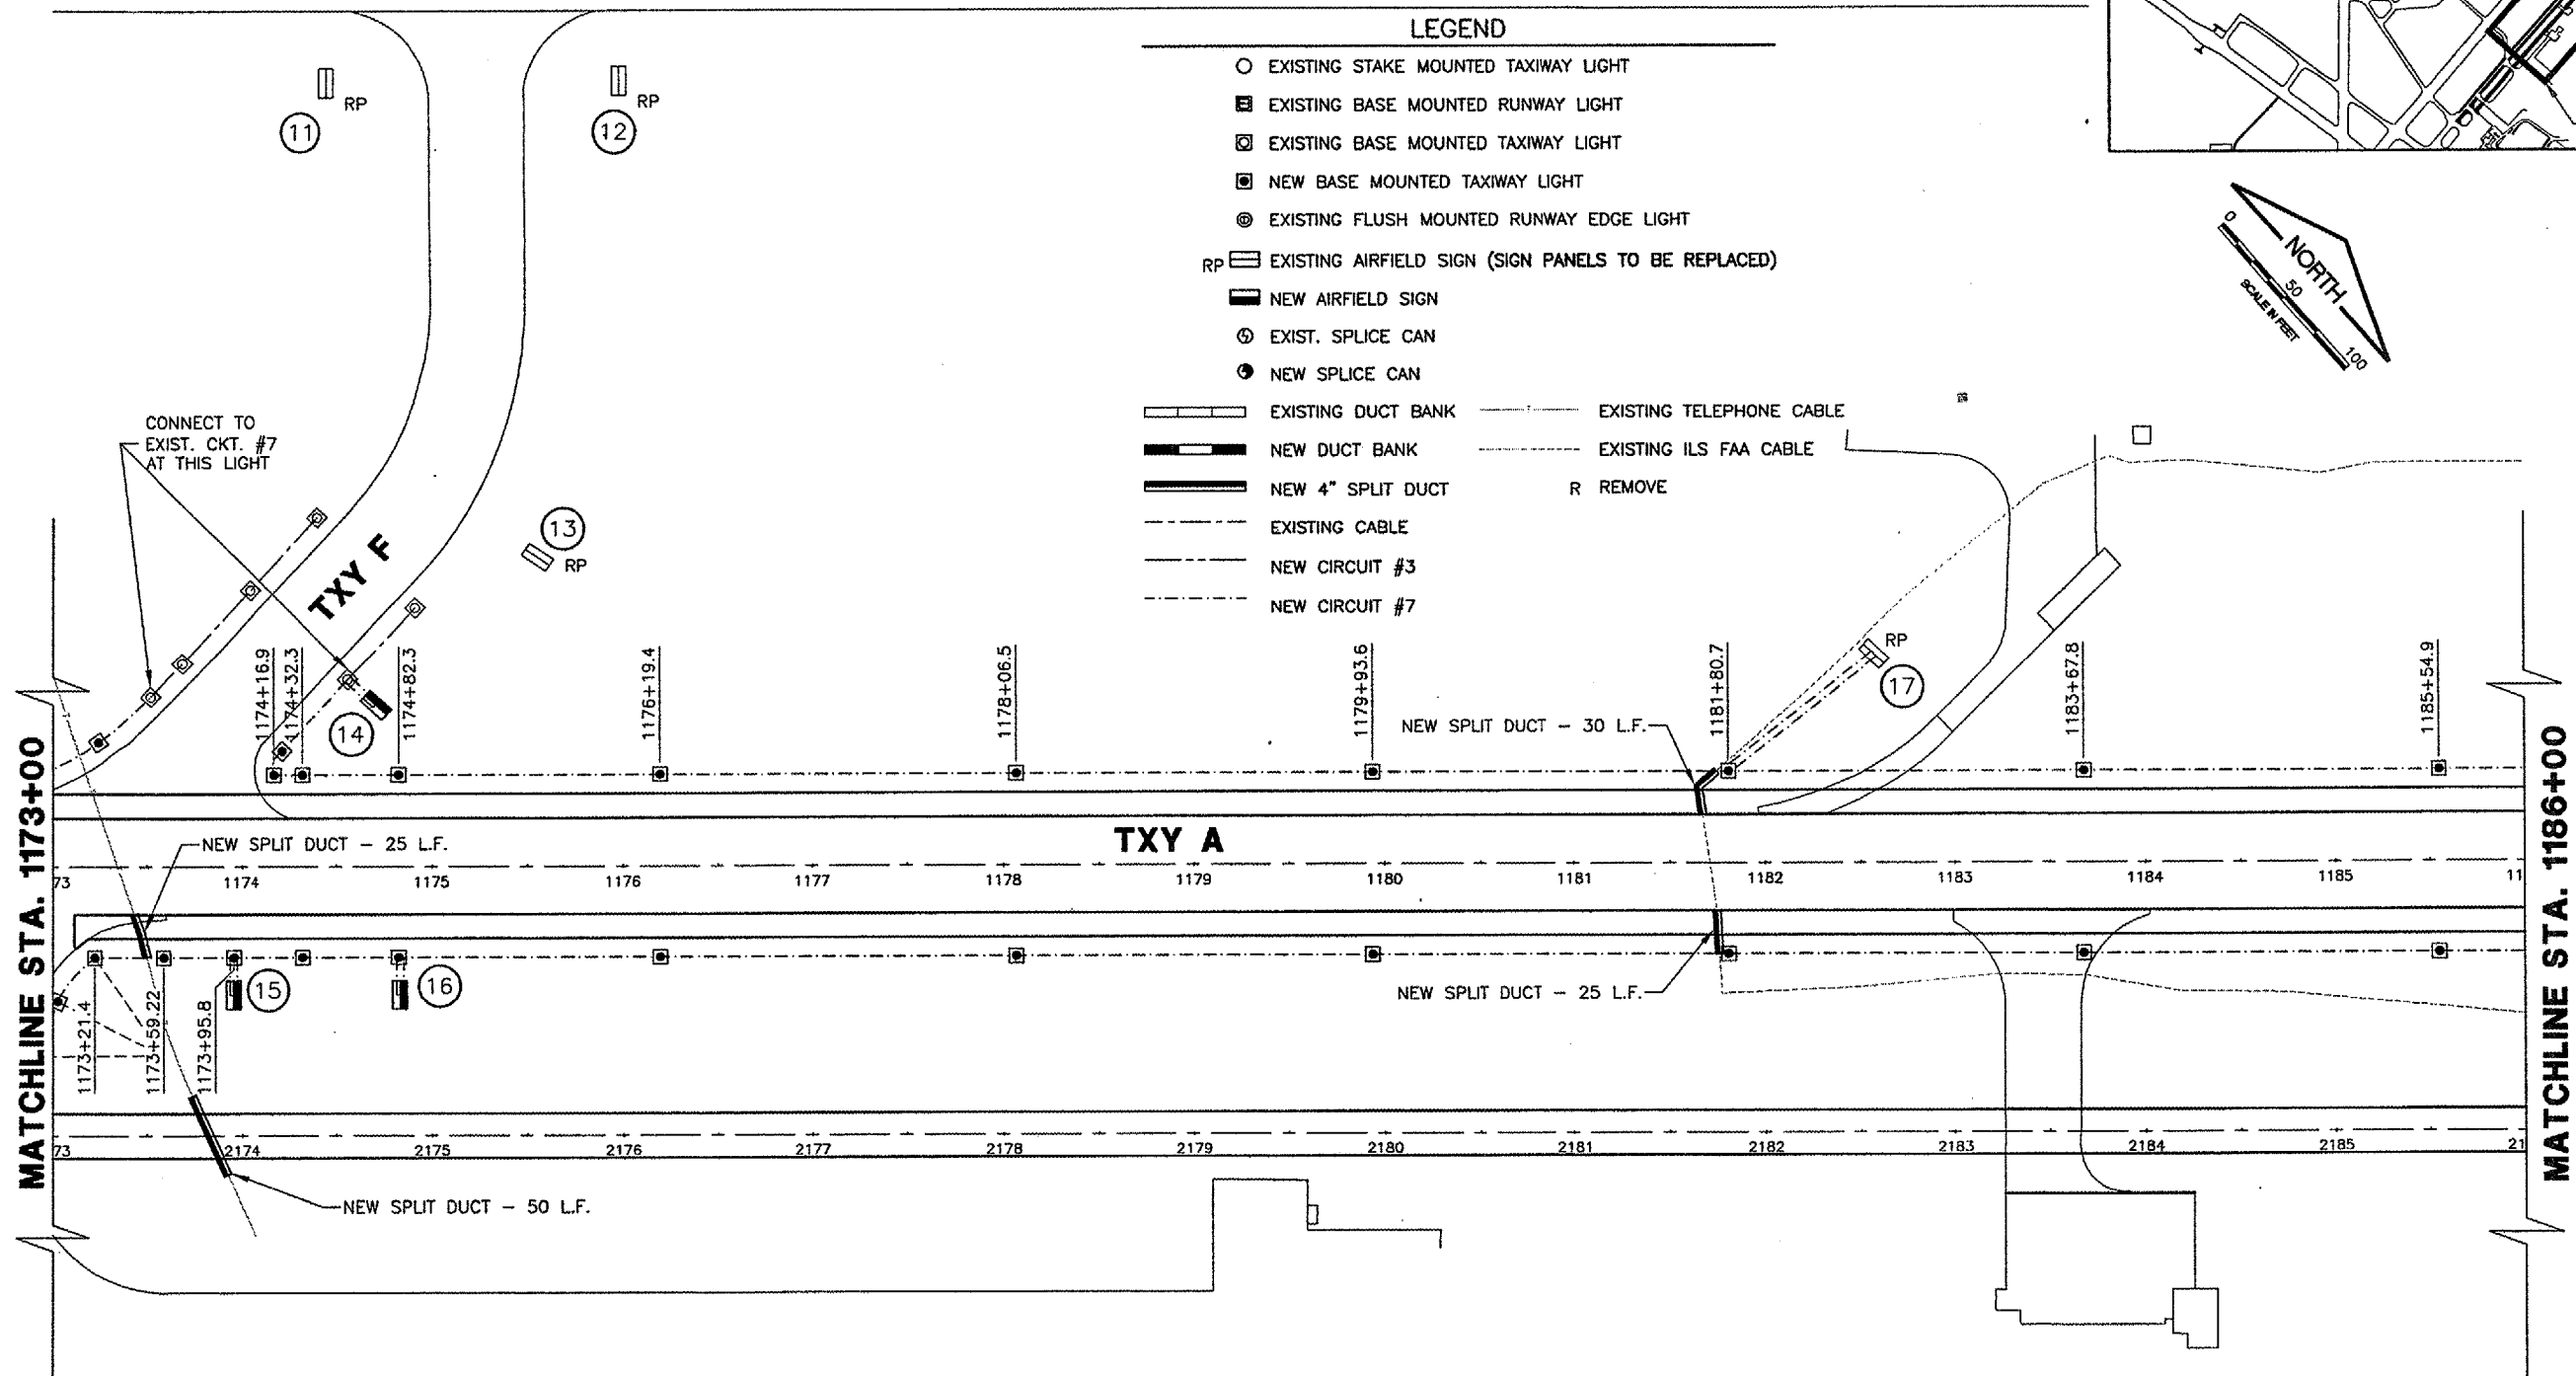

SIGN	STATION
11	NO CHANGE
12	NO CHANGE
13	NO CHANGE
14	1174+88.43
15	1173+95.61
16	1174+83.03
17	REPLACE EXISTING


SPRINGFIELD AIRPORT AUTHORITY
ABRAHAM LINCOLN CAPITAL AIRPORT
SPRINGFIELD, ILLINOIS

WIDEN TAXIWAY A - CONSTRUCT PERIMETER ROAD
ELECTRICAL & LIGHTING PLAN 2


CMT
 CRAWFORD, MURPHY & TILLY, INC.
 CONSULTING ENGINEERS
 License No. 084-000610

DESIGN BY:	MB/KLB
DRAWN BY:	DPA
CHECKED BY:	<i>RW</i>
APPROVED BY:	<i>RW</i>
DATE:	1/23/06
JOB No:	0503507
IL PROJ. NO.	SPI-3555
AIP PROJ. NO.	3-17-0096-44
SHEET	52 OF 83 SHEETS