



SEE IL RTE 53 SHEET WM-7

PROP. CL IL ROUTE 53

END RECONSTRUCTION STA. 17+04

WIDENING AND RESURFACING LIMIT STA. 18+81.57

WM-FH28

EXIST ROW

PROP ROW

PROP ROW

EXIST ROW

110+00

15+00

20+00

EXIST ROW

EXIST ROW


**FIRE HYDRANTS**

WM-FH28  
REMOVE AND RELOCATE EXISTING FIRE HYDRANT  
EXPOSE EXISTING TEE AND ROTATE TEE TO  
OPPOSITE SIDE OF WATER MAIN (WORK TO BE PAID  
FOR AS A FIRE HYDRANT AND AUXILIARY VALVE REMOVAL).  
RELOCATE EXISTING FIRE HYDRANT WITH 12 L.F.  
OF 6" LEADER PIPE (RJT) TO 10 FEET BEHIND  
PROPOSED BACK OF CURB.

END RECONSTRUCTION STA. 12+87.42

PROP. CL BRYN MAWR AVENUE

SEE IL RTE 53 SHEET WM-7

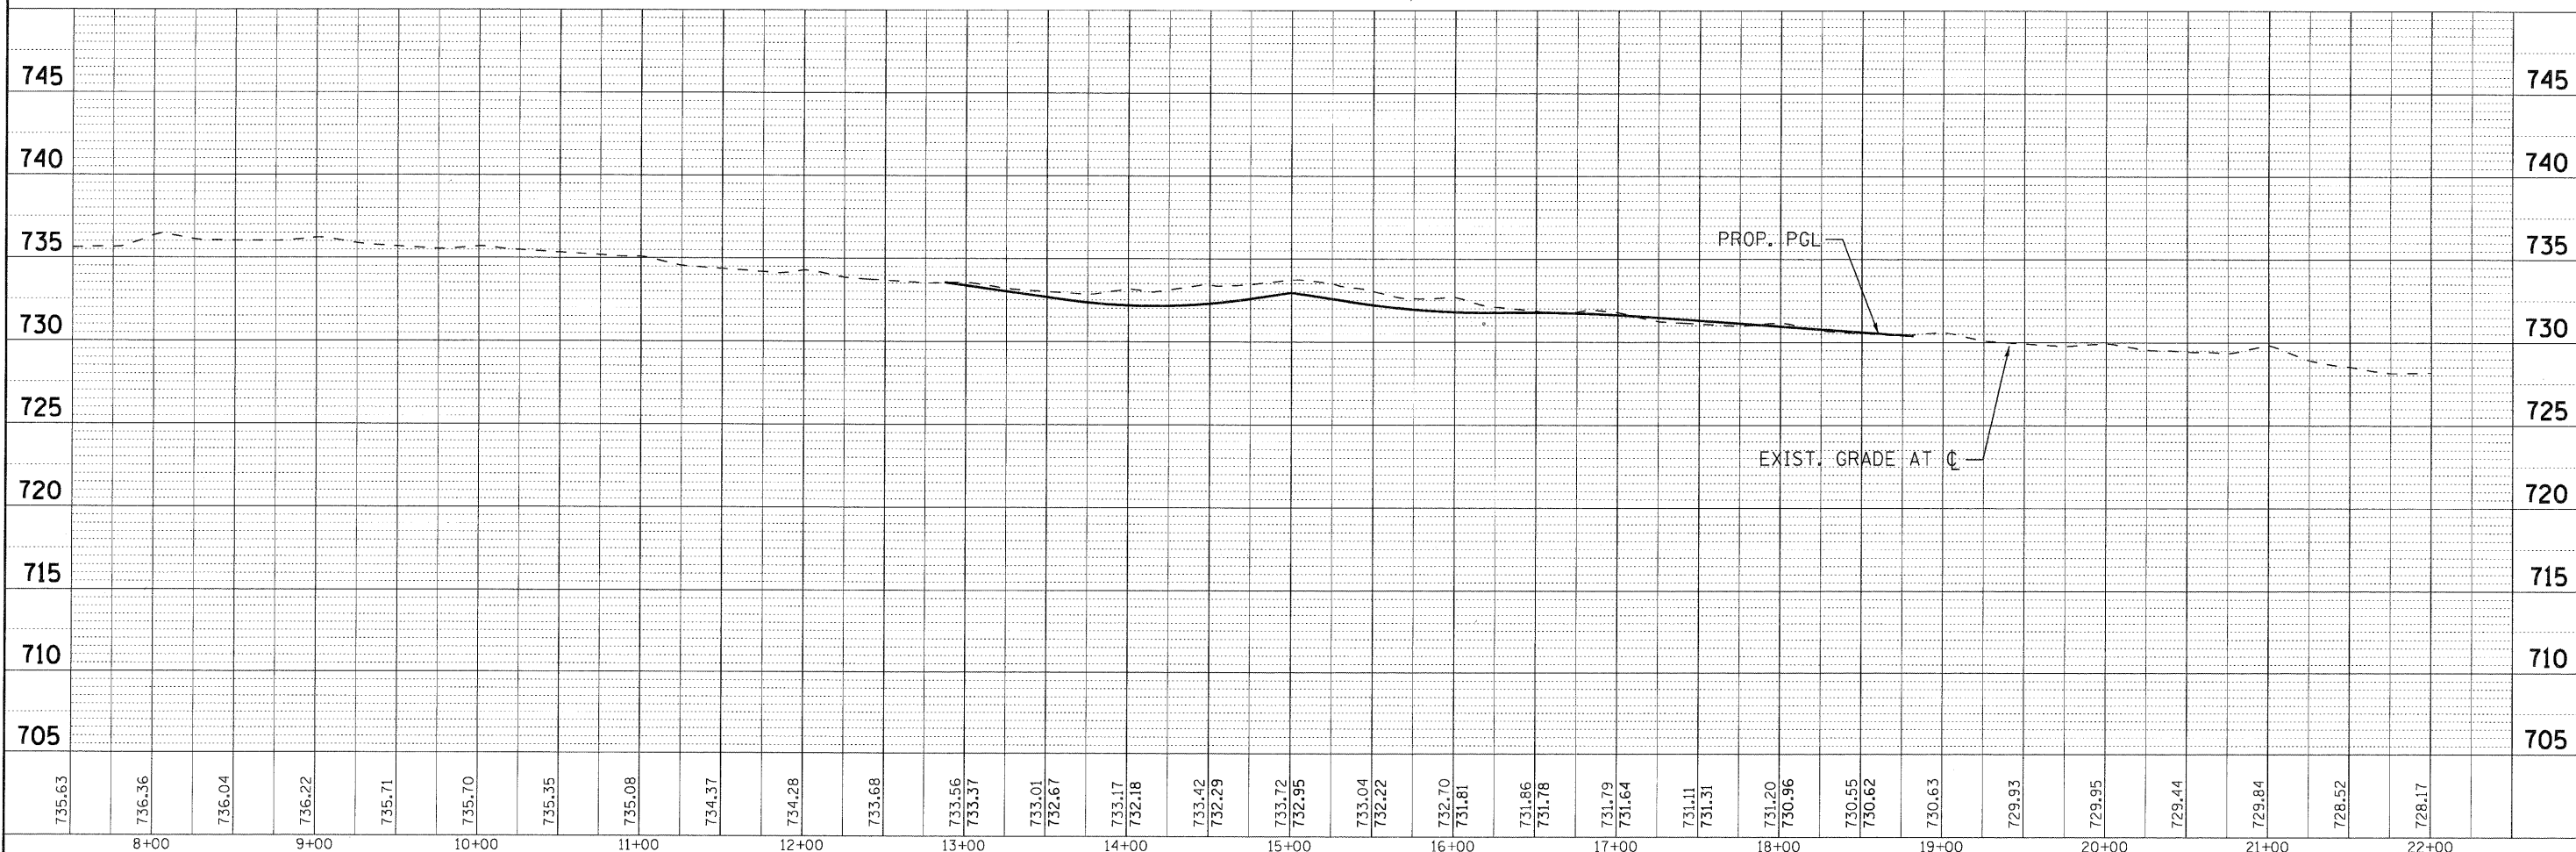

PLAN	REVISION	DATE
NO.	NO.	
NOTE BOOK	ALIGNMENT CHECKED	
	CADD FILE NAME	


PROFILE	DATE
NO.	
NOTE BOOK	GRADES CHECKED
	STRUCTURE NOTATIONS



USER NAME = (username)  
 PLOT CONFIG= PDF22X34.plt  
 PLOT SCALE = 1:50  
 PLOT DATE = 11/24/2010 9:21:22 AM

DESIGNED - SMV  
 DRAWN - LKB  
 CHECKED - SMV  
 DATE - 7-30-2010

 REVISED - 8-27-10 VILLAGE REVIEW  
 REVISED -  
 REVISED -  
 REVISED -



**BRYN MAWR AVENUE  
 WATER AND SEWER REPLACEMENT PLAN AND PROFILE**

SCALE: 1"=50' SHEET NO. WM-12 OF 17 STA. 11+00 TO STA. 19+45

F.A.U. RTE.	SECTION	COUNTY	TOTAL SHEETS	SHEET NO.
2578	532B		781	360
CONTRACT NO. 60477			ILLINOIS FED. AID PROJECT	