



DATE	BY
REVISIONS	NO.
PLANNING	NO.
DESIGN	NO.
CONSTRUCTION	NO.

DATE	BY
REVISIONS	NO.
PROFILE	NO.
GRADES	NO.
STRUCTURE	NO.
NOTATIONS	NO.

McDonough Associates Inc.
 Engineers / Architects
 130 East Randolph Street, Chicago, Illinois 60601

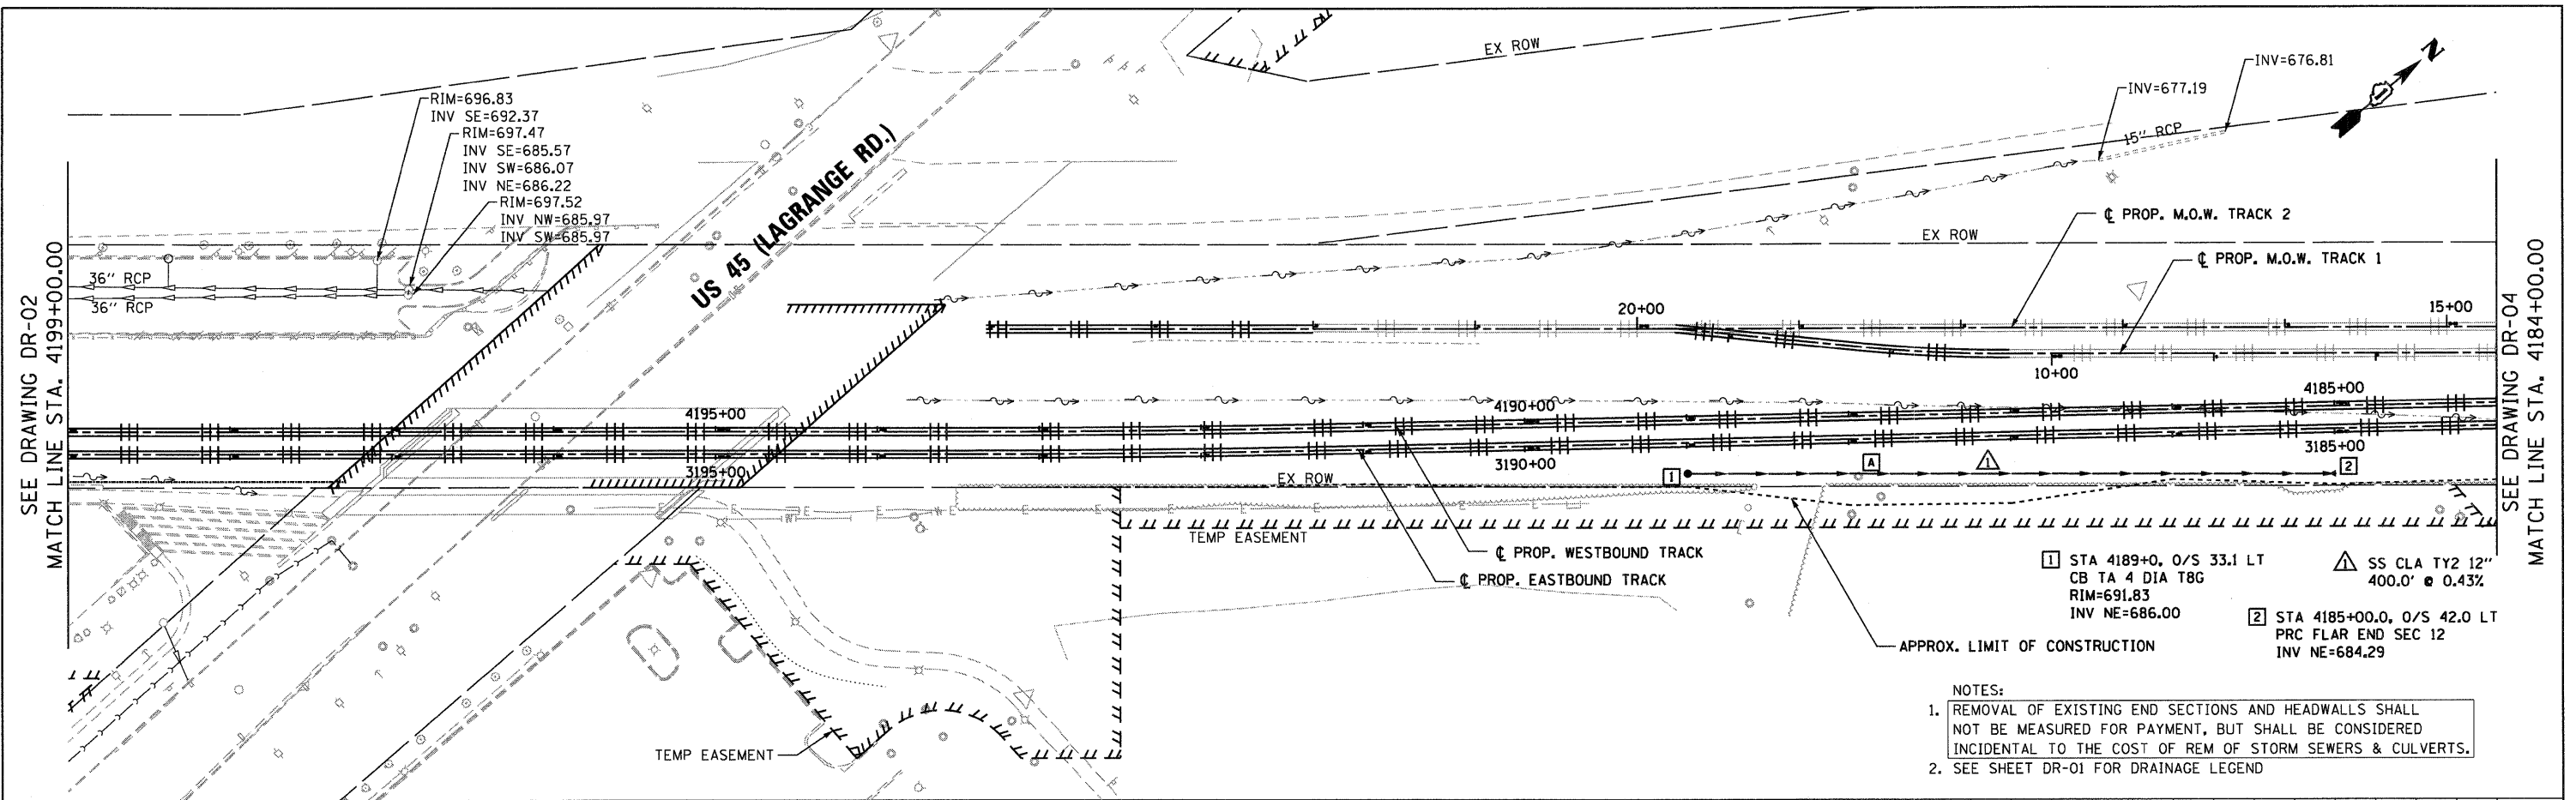

- NOTES:
- REMOVAL OF EXISTING END SECTIONS AND HEADWALLS SHALL NOT BE MEASURED FOR PAYMENT, BUT SHALL BE CONSIDERED INCIDENTAL TO THE COST OF REM OF STORM SEWERS & CULVERTS.
 - SEE SHEET DR-01 FOR DRAINAGE LEGEND

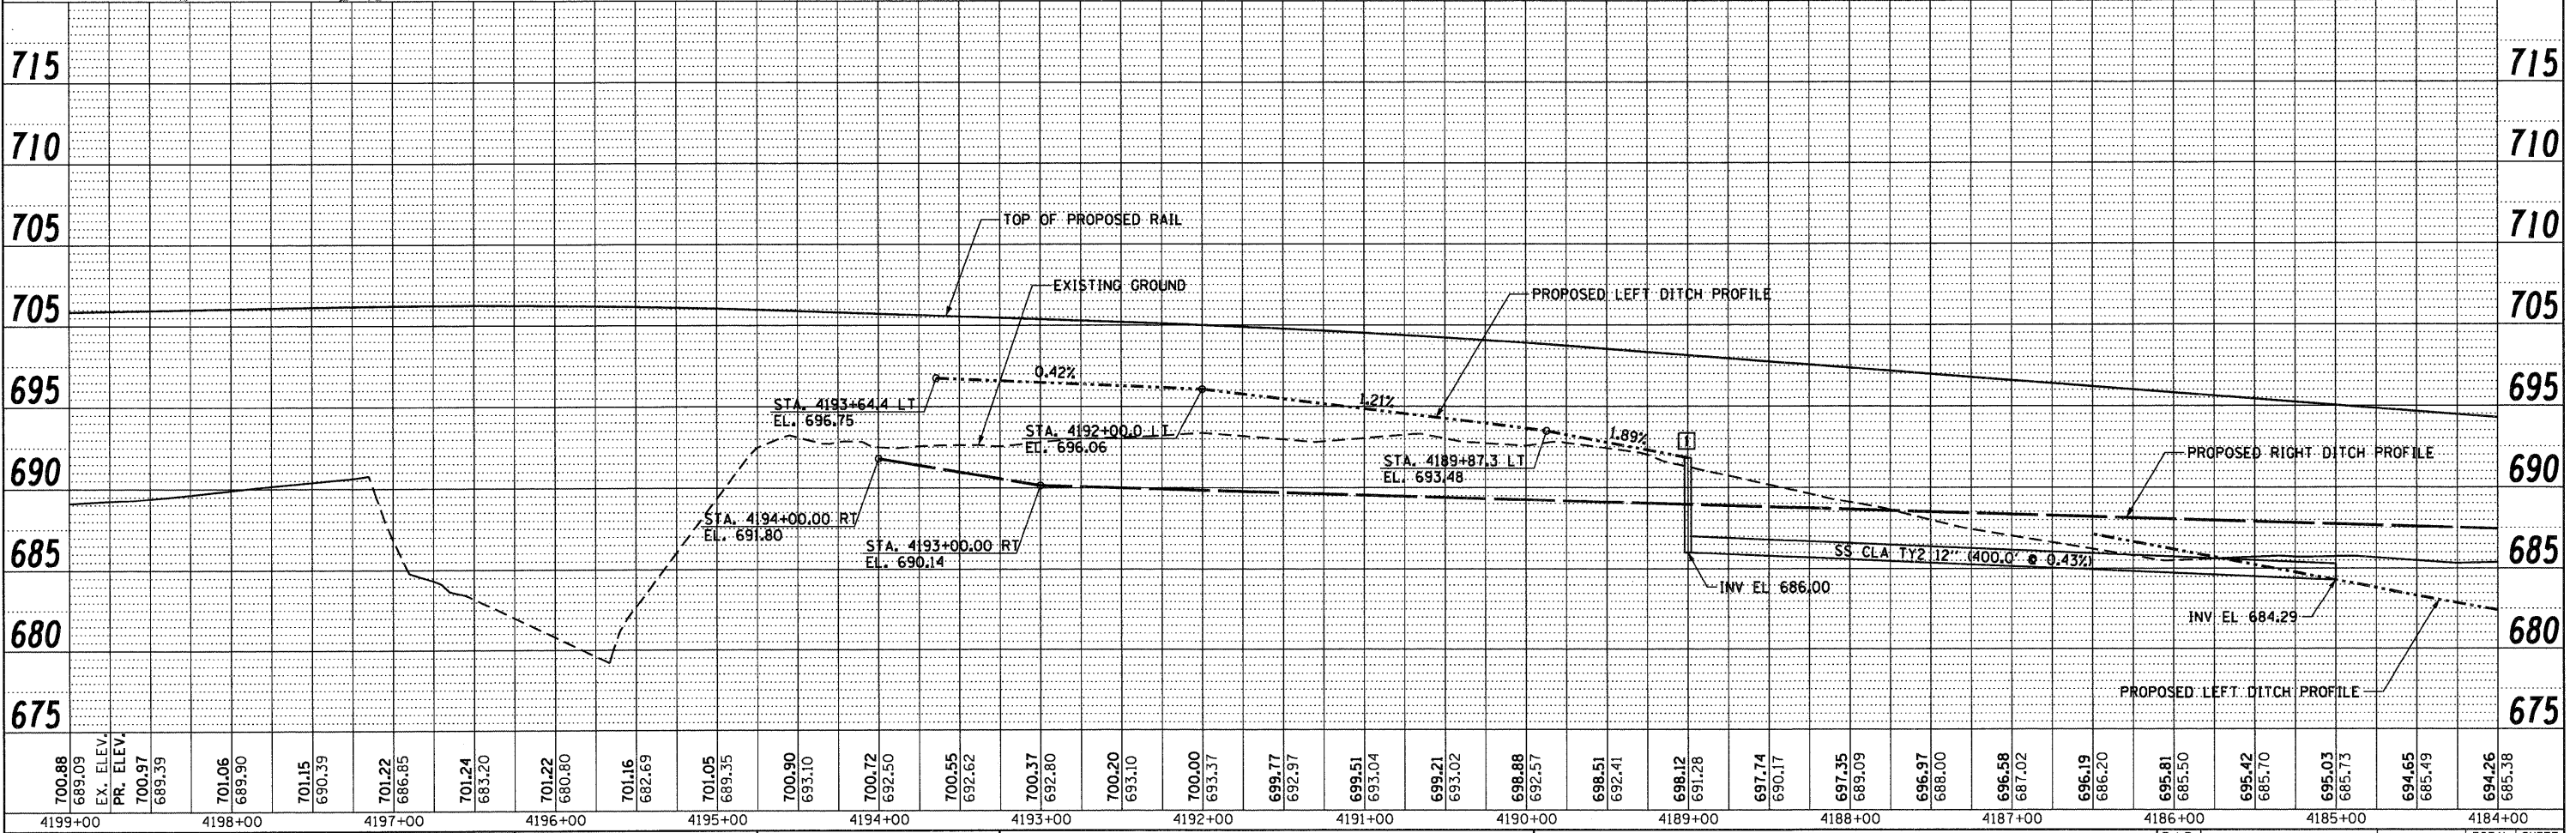

FILE NAME = D:\6209-SHT-DRAIN03.dgn	USER NAME = TKLuegel	DESIGNED - MJT	REVISED -	STATE OF ILLINOIS DEPARTMENT OF TRANSPORTATION	DRAINAGE AND UTILITIES PLAN AND PROFILE	F.A.P. RTE. 330	SECTION 2010-135-I	COUNTY COOK	TOTAL SHEETS 101	SHEET NO. 34	
PLOT SCALE = 1:50	DATE = 12/29/2010	DRAWN - MJT	REVISED -			DR-03		CONTRACT NO. 60N09		[ILLINOIS] FED. AID PROJECT	
		CHECKED - JWM	REVISED -			SCALE: 1"=50'H 1"=5'V SHEET NO. 3 OF 4 SHEETS STA. TO STA.					
		DATE = 12/17/10	REVISED -								