
 


MATCH LINE STT. 3208+00/4208+00

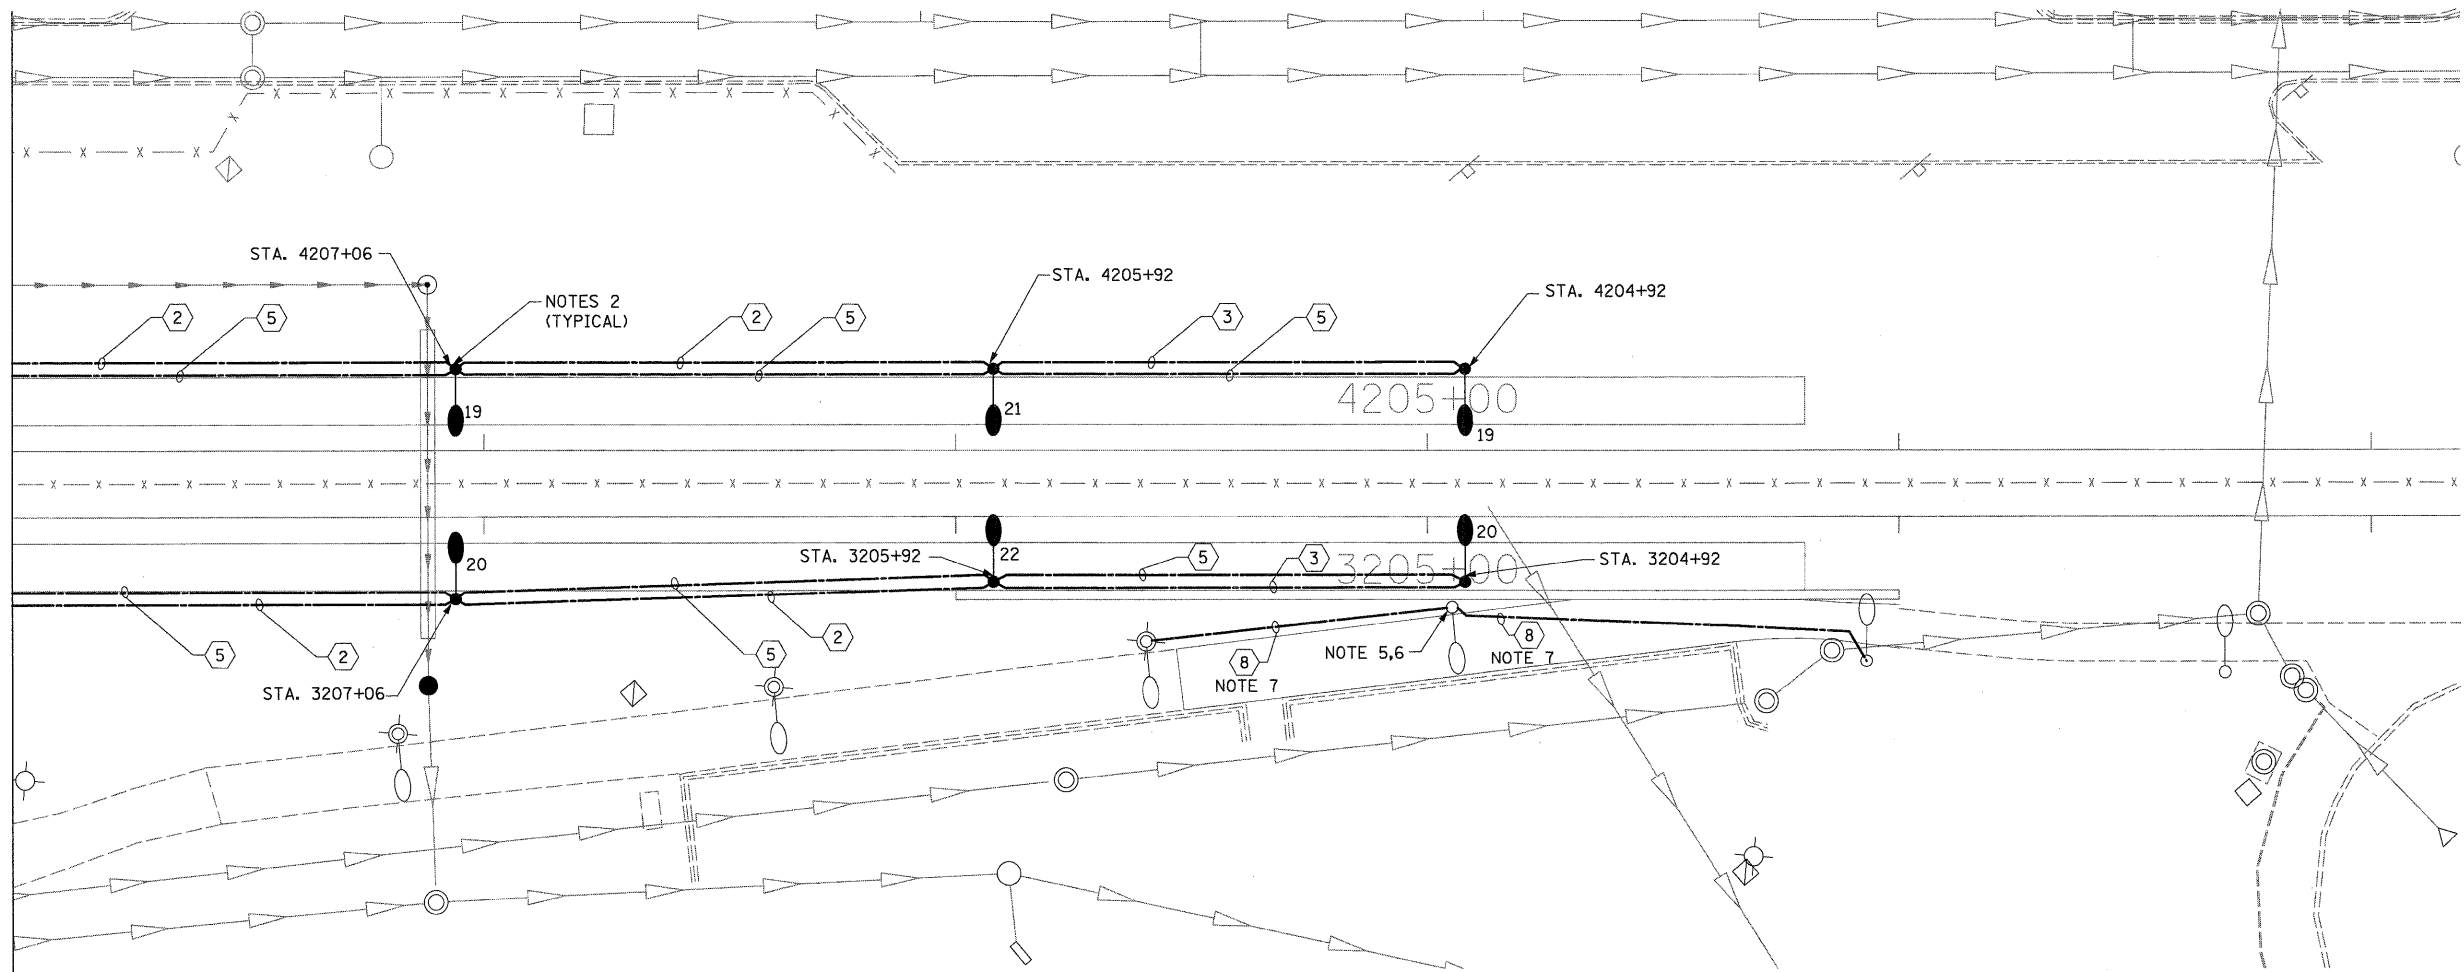

- NOTES:**
1. REFER TO SHEET MSE-1 FOR SYMBOLS, ABBREVIATIONS AND GENERAL NOTES.
 2. CONTRACTOR SHALL FURNISH NEW LIGHT POLE FOUNDATION, CONDUITS, WIRING, LIGHT POLES, LUMINAIRES AND RELATED COMPONENTS AS SHOWN. FOR DETAILS, SEE SHEET MSE-8. METRA FORCES SHALL INSTALL AND WIRE ALL WORK AS SHOWN.
 3. FOR PANEL SCHEDULE, SEE SHEET MSE-2.
 4. FOR CONDUIT AND WIRING SCHEDULE, SEE SHEET MSE-1.
 5. CONTRACTOR SHALL INSTALL LIGHT POLE FOUNDATION TANGENT TO RETAINING WALL, BETWEEN WALL AND PROPOSED PATH.
 6. CONTRACTOR SHALL RELOCATE EXISTING LIGHTING UNIT ON NEW FOUNDATION.
 7. CONTRACTOR SHALL INSTALL NEW CONDUIT AND WIRING FROM RELOCATED POLE TO EXISTING POLES. SPLICE TO EXISTING CIRCUIT IN EXISTING LIGHT POLE HANDHOLE. CHANGE OVER SHALL BE DONE DURING DAYLIGHT HOURS AFTER ALL OTHER WORK IS DONE. MAINTAIN EXISTING LIGHTING DURING HOURS OF DARKNESS. ALL MATERIAL AND LABOR FOR CONNECTING NEW WIRING TO EXISTING LIGHT POLE SHALL BE INCLUDED IN THE "CONDUIT IN TRENCH, 1/4" DIA. COILABLE NONMETALLIC CONDUIT" PAY ITEM. SEPARATE PAYMENT WILL NOT BE MADE.



FILE NAME =	USER NAME = JSpiekermann	DESIGNED MB	REVISED -	STATE OF ILLINOIS DEPARTMENT OF TRANSPORTATION	METRA STATION AND PLATFORMS PROPOSED ELECTRICAL PLAN	F.A. RTE. 330	SECTION 2010-135-I	COUNTY COOK	TOTAL SHEETS 101	SHEET NO. 63		
	PLOT SCALE = 1" = 20'	CHECKED MCP	REVISED -			SCALE: 1"=20'	SHEET NO. 2 OF 2 SHEETS	STA.	TO STA.	MSE-7 CONTRACT NO. 60N09		
	PLOT DATE = 08/13/10	DATE 12/27/10	REVISED -			ILLINOIS FED. AID PROJECT						