


EXISTING CONDITIONS AND REMOVAL

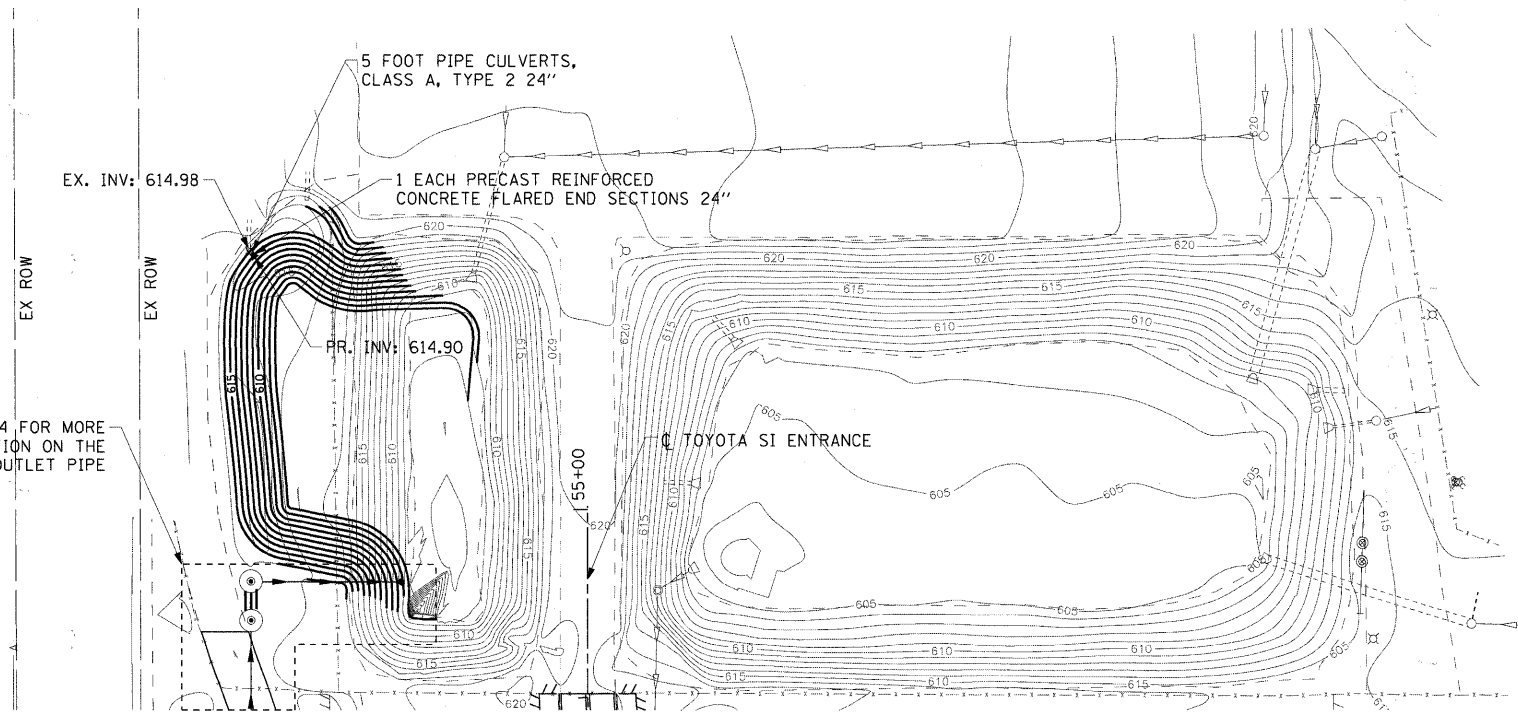

DRAINAGE AND UTILITY PLAN

SEE SHEETS 88-94 FOR MORE DETAILED INFORMATION ON THE PUMP STATION AND OUTLET PIPE

FILE NAME = P:\60155677\000_6401\001_Drawings\Sheets\Civil\60155677-abc-Drain-03.dgn



USER NAME = kukielkek	DESIGNED - KLK	REVISED -
PLOT SCALE = 50.000' / IN.	DRAWN - KLK	REVISED -
PLOT DATE = 12/22/2010	CHECKED - EY	REVISED -
DATE - DECEMBER 15, 2010	REVISED -	

STATE OF ILLINOIS
DEPARTMENT OF TRANSPORTATION

DRAINAGE AND UTILITY PLAN

SCALE: 1"=50' SHEET NO. 3 OF 3 SHEETS STA 25+00.00 TO STA 30+75.00

F.A.U. RTE.	SECTION	COUNTY	TOTAL SHEETS	SHEET NO.
1537	06-00050-00-GS	COOK	209	49
FED. ROAD DIST. NO. 1 ILLINOIS FED. AID PROJECT CRE-9003(709)			CONTRACT NO. 63556	