


SECTION 24, TOWNSHIP 38, RANGE 12
SECTION 25, TOWNSHIP 38, RANGE 12

PLAN	SURVEYED	DATE
NOTE BOOK	PLOTTED	
NO.	CHECKED	
	INT. OF WAY CHECKED	
	ROAD FILE NAME	

PROFILE	SURVEYED	DATE
NOTE BOOK	PLOTTED	
	CHECKED	
	SUM. NOTED	

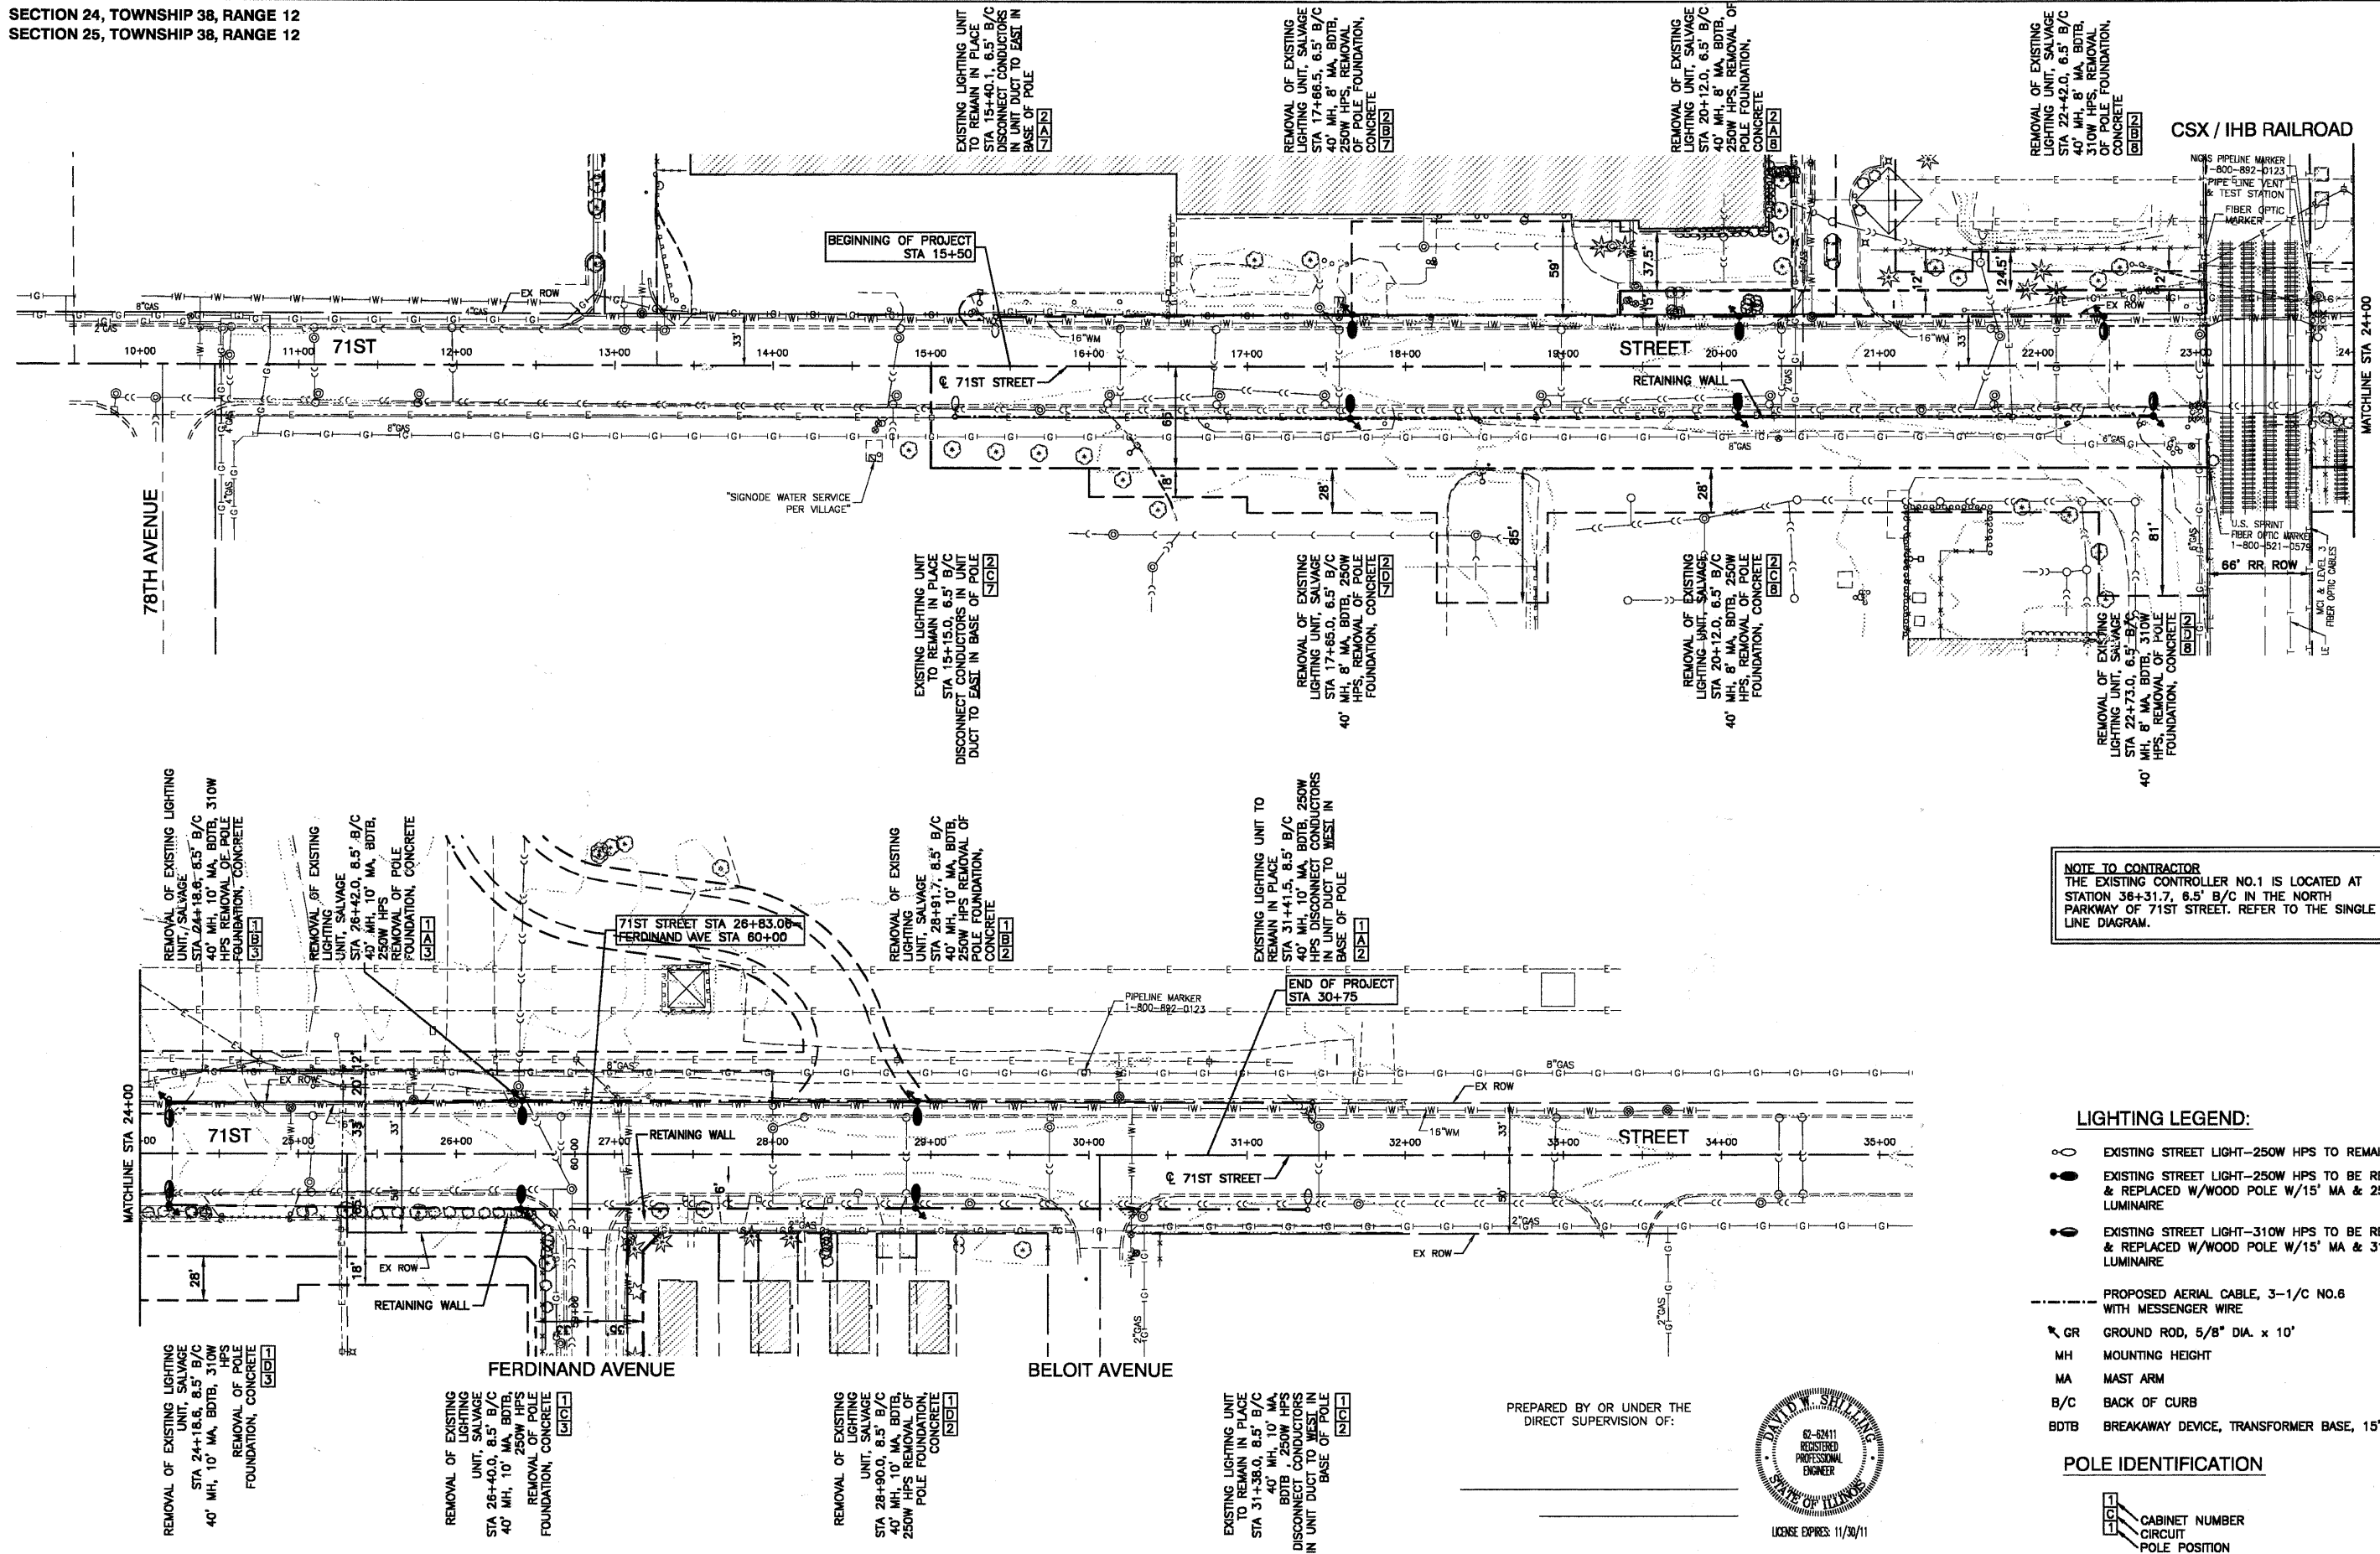

NOTE TO CONTRACTOR
THE EXISTING CONTROLLER NO.1 IS LOCATED AT STATION 36+31.7, 6.5' B/C IN THE NORTH PARKWAY OF 71ST STREET. REFER TO THE SINGLE LINE DIAGRAM.

- LIGHTING LEGEND:**
- ○ EXISTING STREET LIGHT—250W HPS TO REMAIN IN PLACE
 - EXISTING STREET LIGHT—250W HPS TO BE REMOVED & REPLACED W/WOOD POLE W/15' MA & 250 WATT HPS LUMINAIRE
 - EXISTING STREET LIGHT—310W HPS TO BE REMOVED & REPLACED W/WOOD POLE W/15' MA & 310 WATT HPS LUMINAIRE
 - PROPOSED AERIAL CABLE, 3-1/C NO.6 WITH MESSENGER WIRE
 - GR GROUND ROD, 5/8" DIA. x 10'
 - MH MOUNTING HEIGHT
 - MA MAST ARM
 - B/C BACK OF CURB
 - BDTB BREAKAWAY DEVICE, TRANSFORMER BASE, 15" BOLT CIRCLE


- POLE IDENTIFICATION**
- CABINET NUMBER
 - CIRCUIT
 - POLE POSITION

FILE NAME = 09898-LIGHT-01 - P01

USER NAME =	DESIGNED — PAP	REVISED —
	CHECKED — DWS	REVISED —
PLOT SCALE =	DRAWN — PS	REVISED —
PLOT DATE = 12/23/10	CHECKED — AG	REVISED —

STATE OF ILLINOIS
DEPARTMENT OF TRANSPORTATION

PREPARED BY OR UNDER THE DIRECT SUPERVISION OF:

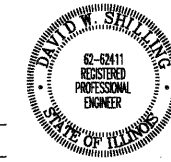

71ST STREET EXISTING POLE REMOVAL/ TEMPORARY WOOD POLE LOCATION STREET LIGHTING	
SCALE: 1"=50'	SHEET NO. 79 OF 209 SHEETS
STA. 15+50	TO STA. 30+75

F.A.U. RTE.	SECTION	COUNTY	TOTAL SHEETS	SHEET NO.
1537	06-00050-00-GS	COOK	209	79
CONTRACT NO. 63556				
FED. ROAD DIST. NO. 1 ILLINOIS FED. AID PROJECT CRE-9003(709)				