


TEMPORARY WIRING NOTES:

1. SECURE AERIAL CABLE ATTACHMENTS TO POLE WITH POLE BANDS AT A HEIGHT THAT WILL PROVIDE THE REQUIRED 18 FOOT NATIONAL ELECTRICAL CODE CONDUCTOR CLEARANCE OVER THE ROADWAY. REFER TO DETAIL 2, SHEET LT-09.
2. INSERT CIRCUIT CONDUCTORS THROUGH POLE CAP. SPLICE CONDUCTORS TO THE LIGHTING CIRCUITS AT THE POLE BASE. REFER TO DETAIL 3, SHEET LT-09. REPLACE POLE CAP AFTER TEMPORARY CONDUCTORS ARE REMOVED.
3. CIRCUIT IDENTIFICATION IS ASSUMED AND IS PROVIDED FOR CLARIFICATION OF CIRCUIT ROUTING ONLY.

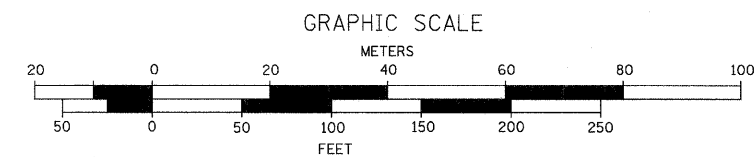

LT-03

FILE NAME = LT-03.dgn
PLOT DATE = 1/26/2009



SPAAN Tech, Inc.

311 S. Wacker Drive, Suite 2400
Chicago, Illinois 60606
phone: 312.277.8800
fax: 312.277.8808
web: www.SpaanTech.com

DESIGNED - I.A.B.	REVISED -
DRAWN - M.K.J.	REVISED -
CHECKED - A.D.O.	REVISED -
DATE - JANUARY, 2009	REVISED -

**STATE OF ILLINOIS
DEPARTMENT OF TRANSPORTATION**

**TEMPORARY LIGHTING PLAN
LEMONT ROAD**

SCALE: 1" = 50' SHEET NO. OF SHEETS STA. TO STA.

F.A.U. RTE.	SECTION	COUNTY	TOTAL SHEETS	SHEET NO.
2612	3104 B-1-I-2	COOK	80	27
FED. ROAD DIST. NO. 1 [ILLINOIS] FED. AID PROJECT			CONTRACT NO. 60D76	