



**TEMPORARY WIRING NOTES:**

1. SECURE AERIAL CABLE ATTACHMENTS TO POLE WITH POLE BANDS AT A HEIGHT THAT WILL PROVIDE THE REQUIRED 18 FOOT NATIONAL ELECTRICAL CODE CONDUCTOR CLEARANCE OVER THE ROADWAY. REFER TO DETAIL 2, SHEET LT-09.
2. INSERT CIRCUIT CONDUCTORS THROUGH POLE CAP. SPLICE CONDUCTORS TO THE LIGHTING CIRCUITS AT THE POLE BASE. REFER TO DETAIL 3, SHEET LT-09. REPLACE POLE CAP AFTER TEMPORARY CONDUCTORS ARE REMOVED.
3. CIRCUIT IDENTIFICATION IS ASSUMED AND IS PROVIDED FOR CLARIFICATION OF CIRCUIT ROUTING ONLY.

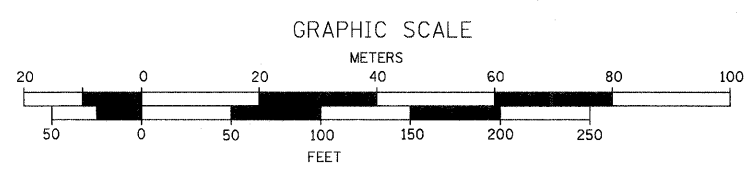

LT-05

FILE NAME = LT-05.dgn PLOT DATE = 1/26/2009	 <b>SPAAN Tech, Inc.</b> <small>311 S. Wacker Drive, Suite 2400 Chicago, Illinois 60606 phone: 312.277.8800 fax: 312.277.8808 web: www.spaanTech.com</small>	DESIGNED - I.A.B. DRAWN - M.K.J. CHECKED - A.D.O. DATE - JANUARY, 2009	REVISED - REVISED - REVISED - REVISED -	<b>STATE OF ILLINOIS DEPARTMENT OF TRANSPORTATION</b>	<b>TEMPORARY LIGHTING PLAN LEMONT ROAD</b>	SCALE: 1" = 50' SHEET NO. OF SHEETS STA. TO STA.	<table border="1" style="width: 100%; border-collapse: collapse;"> <tr> <th>F.A.U. RTE.</th> <th>SECTION</th> <th>COUNTY</th> <th>TOTAL SHEETS</th> <th>SHEET NO.</th> </tr> <tr> <td>2612</td> <td>3104 B-1-I-2</td> <td>COOK</td> <td>80</td> <td>29</td> </tr> </table>	F.A.U. RTE.	SECTION	COUNTY	TOTAL SHEETS	SHEET NO.	2612	3104 B-1-I-2	COOK	80	29
F.A.U. RTE.	SECTION	COUNTY	TOTAL SHEETS	SHEET NO.													
2612	3104 B-1-I-2	COOK	80	29													
						FED. ROAD DIST. NO. 1   ILLINOIS FED. AID PROJECT <b>CONTRACT NO. 60D76</b>											