


FILE NAME = s:\p\13\13\061256-r159-water-41-design-north-section\sign\plan\sheet\1.rte\_59\_b3w\_western-north-663203-071661-lighting-2.dgn

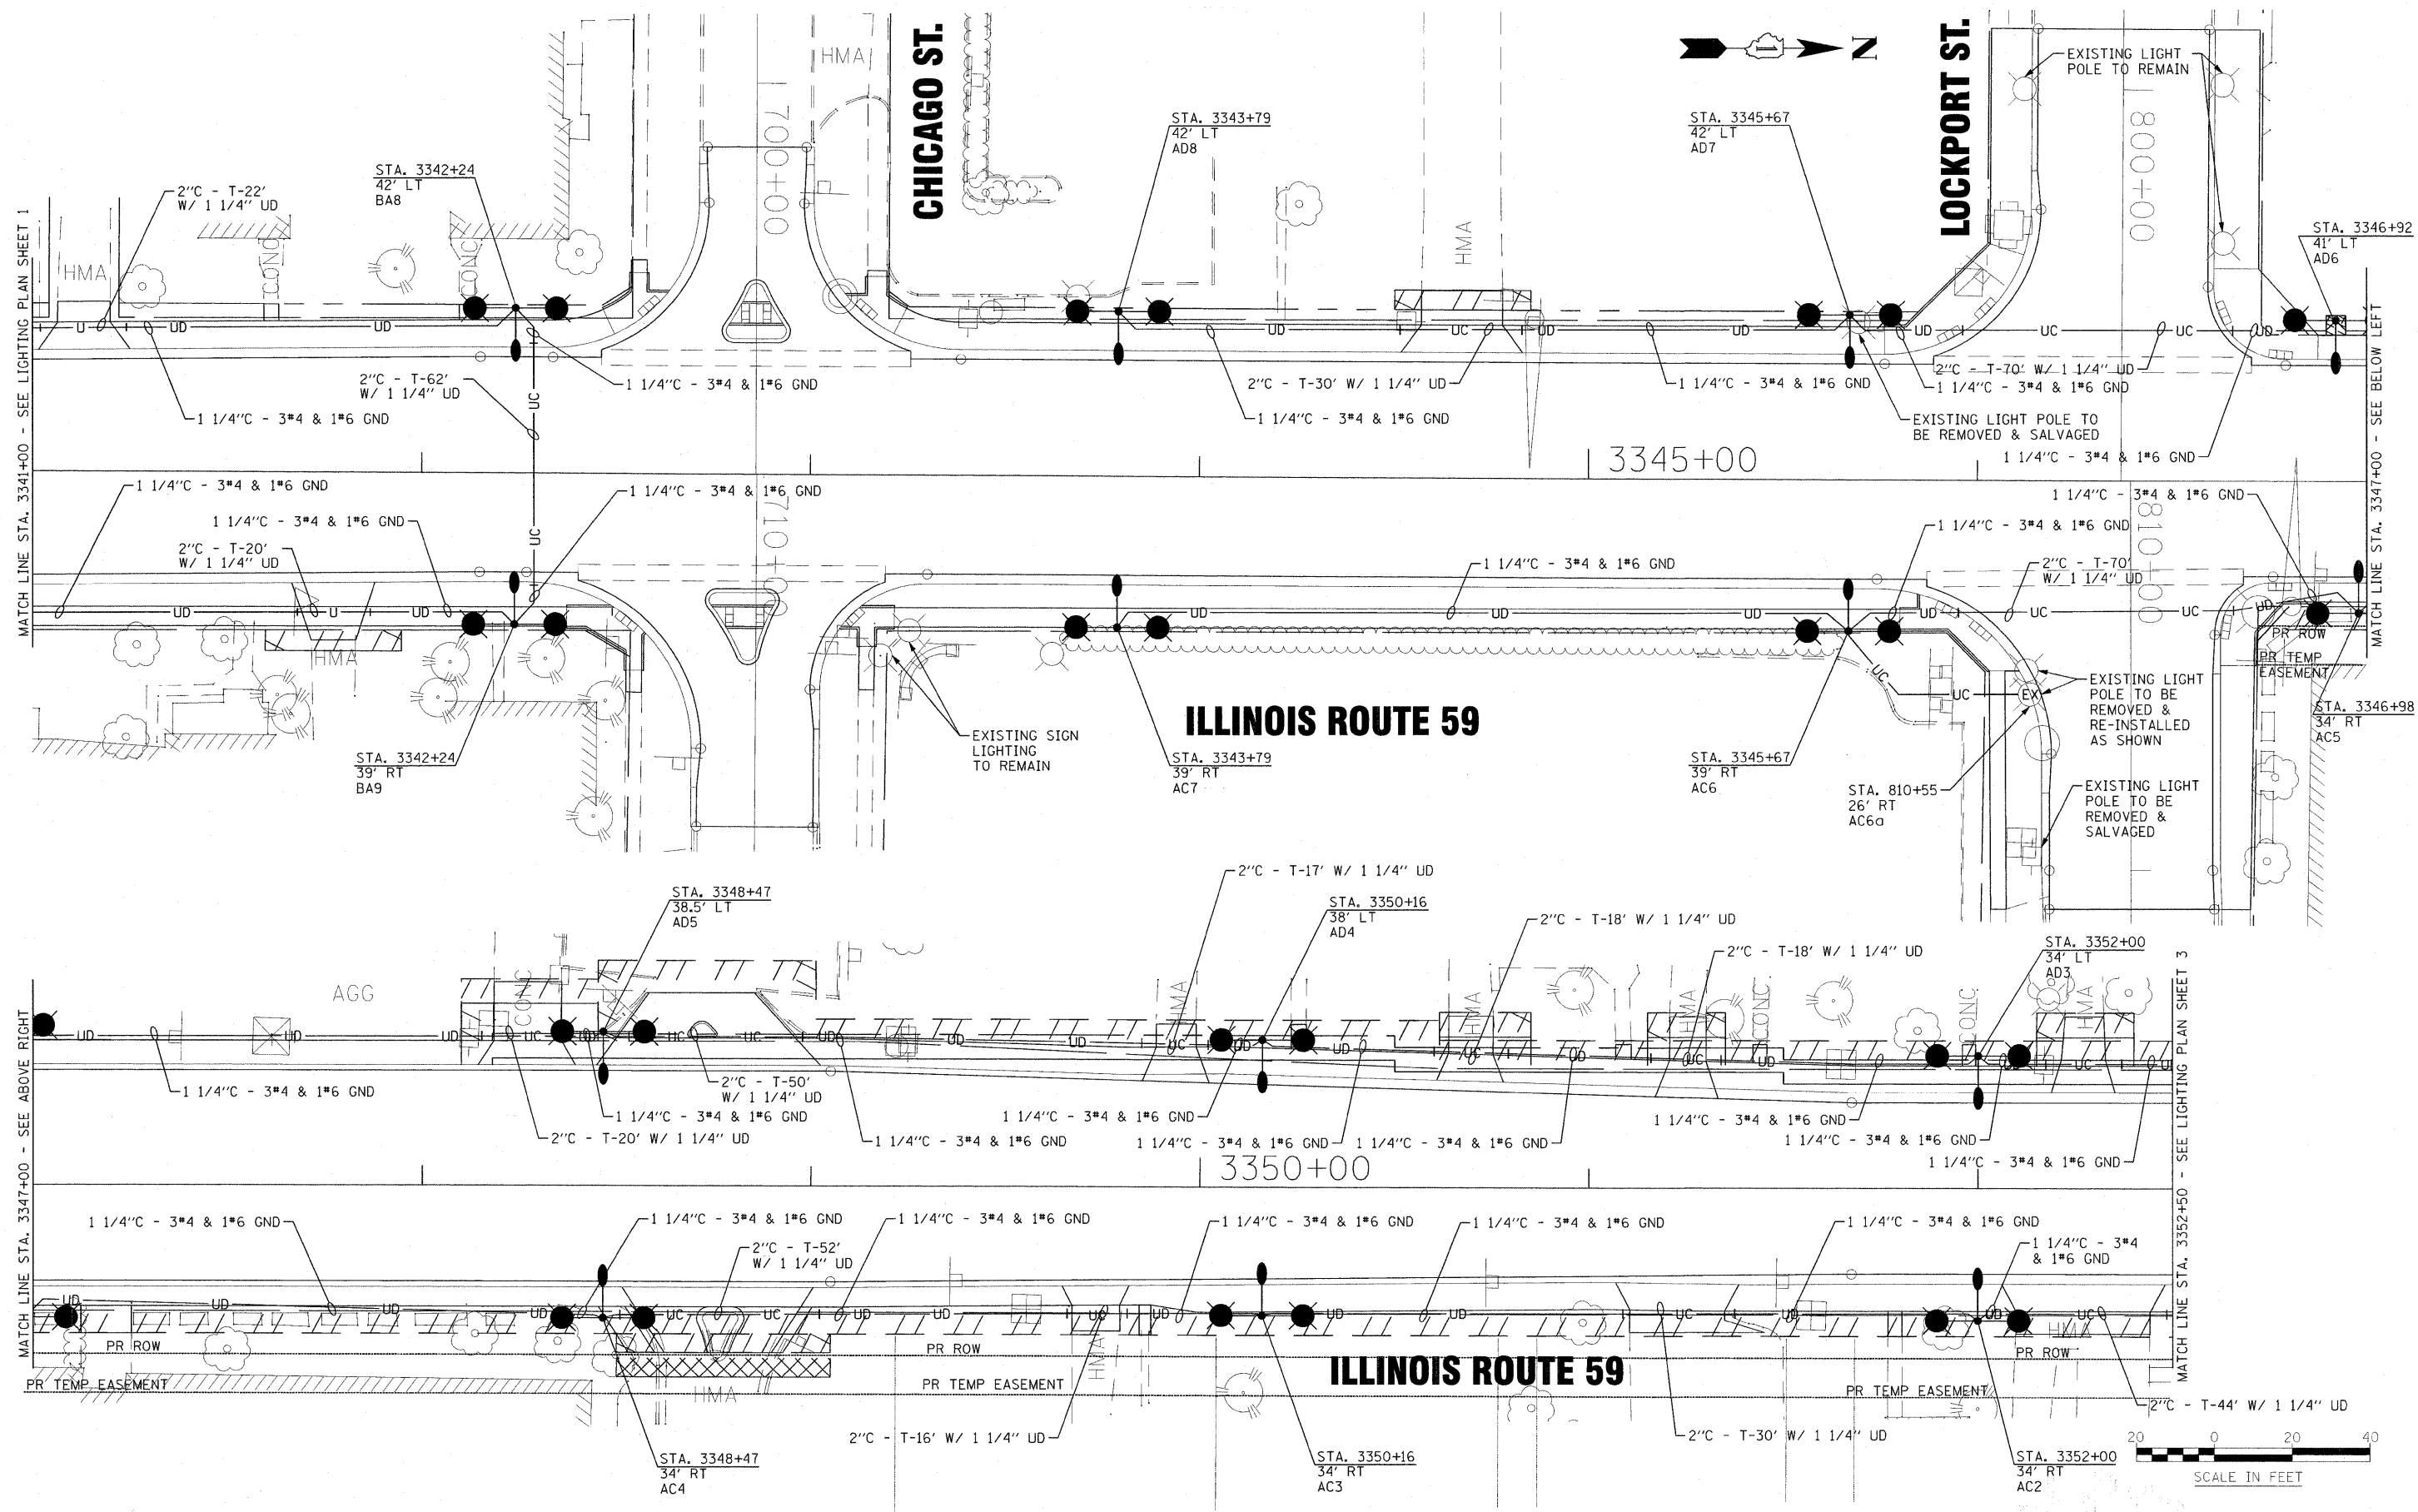

USER NAME = 263mcc	DESIGNED - SMV	REVISED - 10-06-08
PLOT SCALE = 20.0000' / IN.	DRAWN - KAR	REVISED -
PLOT DATE = 1/5/2009	CHECKED - SMV	REVISED -
	DATE - 06-13-08	REVISED -

**STATE OF ILLINOIS  
DEPARTMENT OF TRANSPORTATION**

**ILLINOIS ROUTE 59  
LIGHTING PLAN - SHEET 2**

SCALE: 1" = 20' SHEET NO. 2 OF 9 SHEETS STA. 3341+00 TO STA. 3352+50

F.A. RTE. 338	SECTION 113 N-2	COUNTY WILL	TOTAL SHEETS NO. 260	SHEET NO. 168
FED. ROAD DIST. NO. ILLINOIS		CONTRACT NO. 60E73		