


FILE NAME = J:\Projects\061256-09-water\41-design\p-r\sh-section\planfield.dwg 11-11-09 9:58:58 AM watermain-nor-hv-6632803-071681-lighting-3.dgn

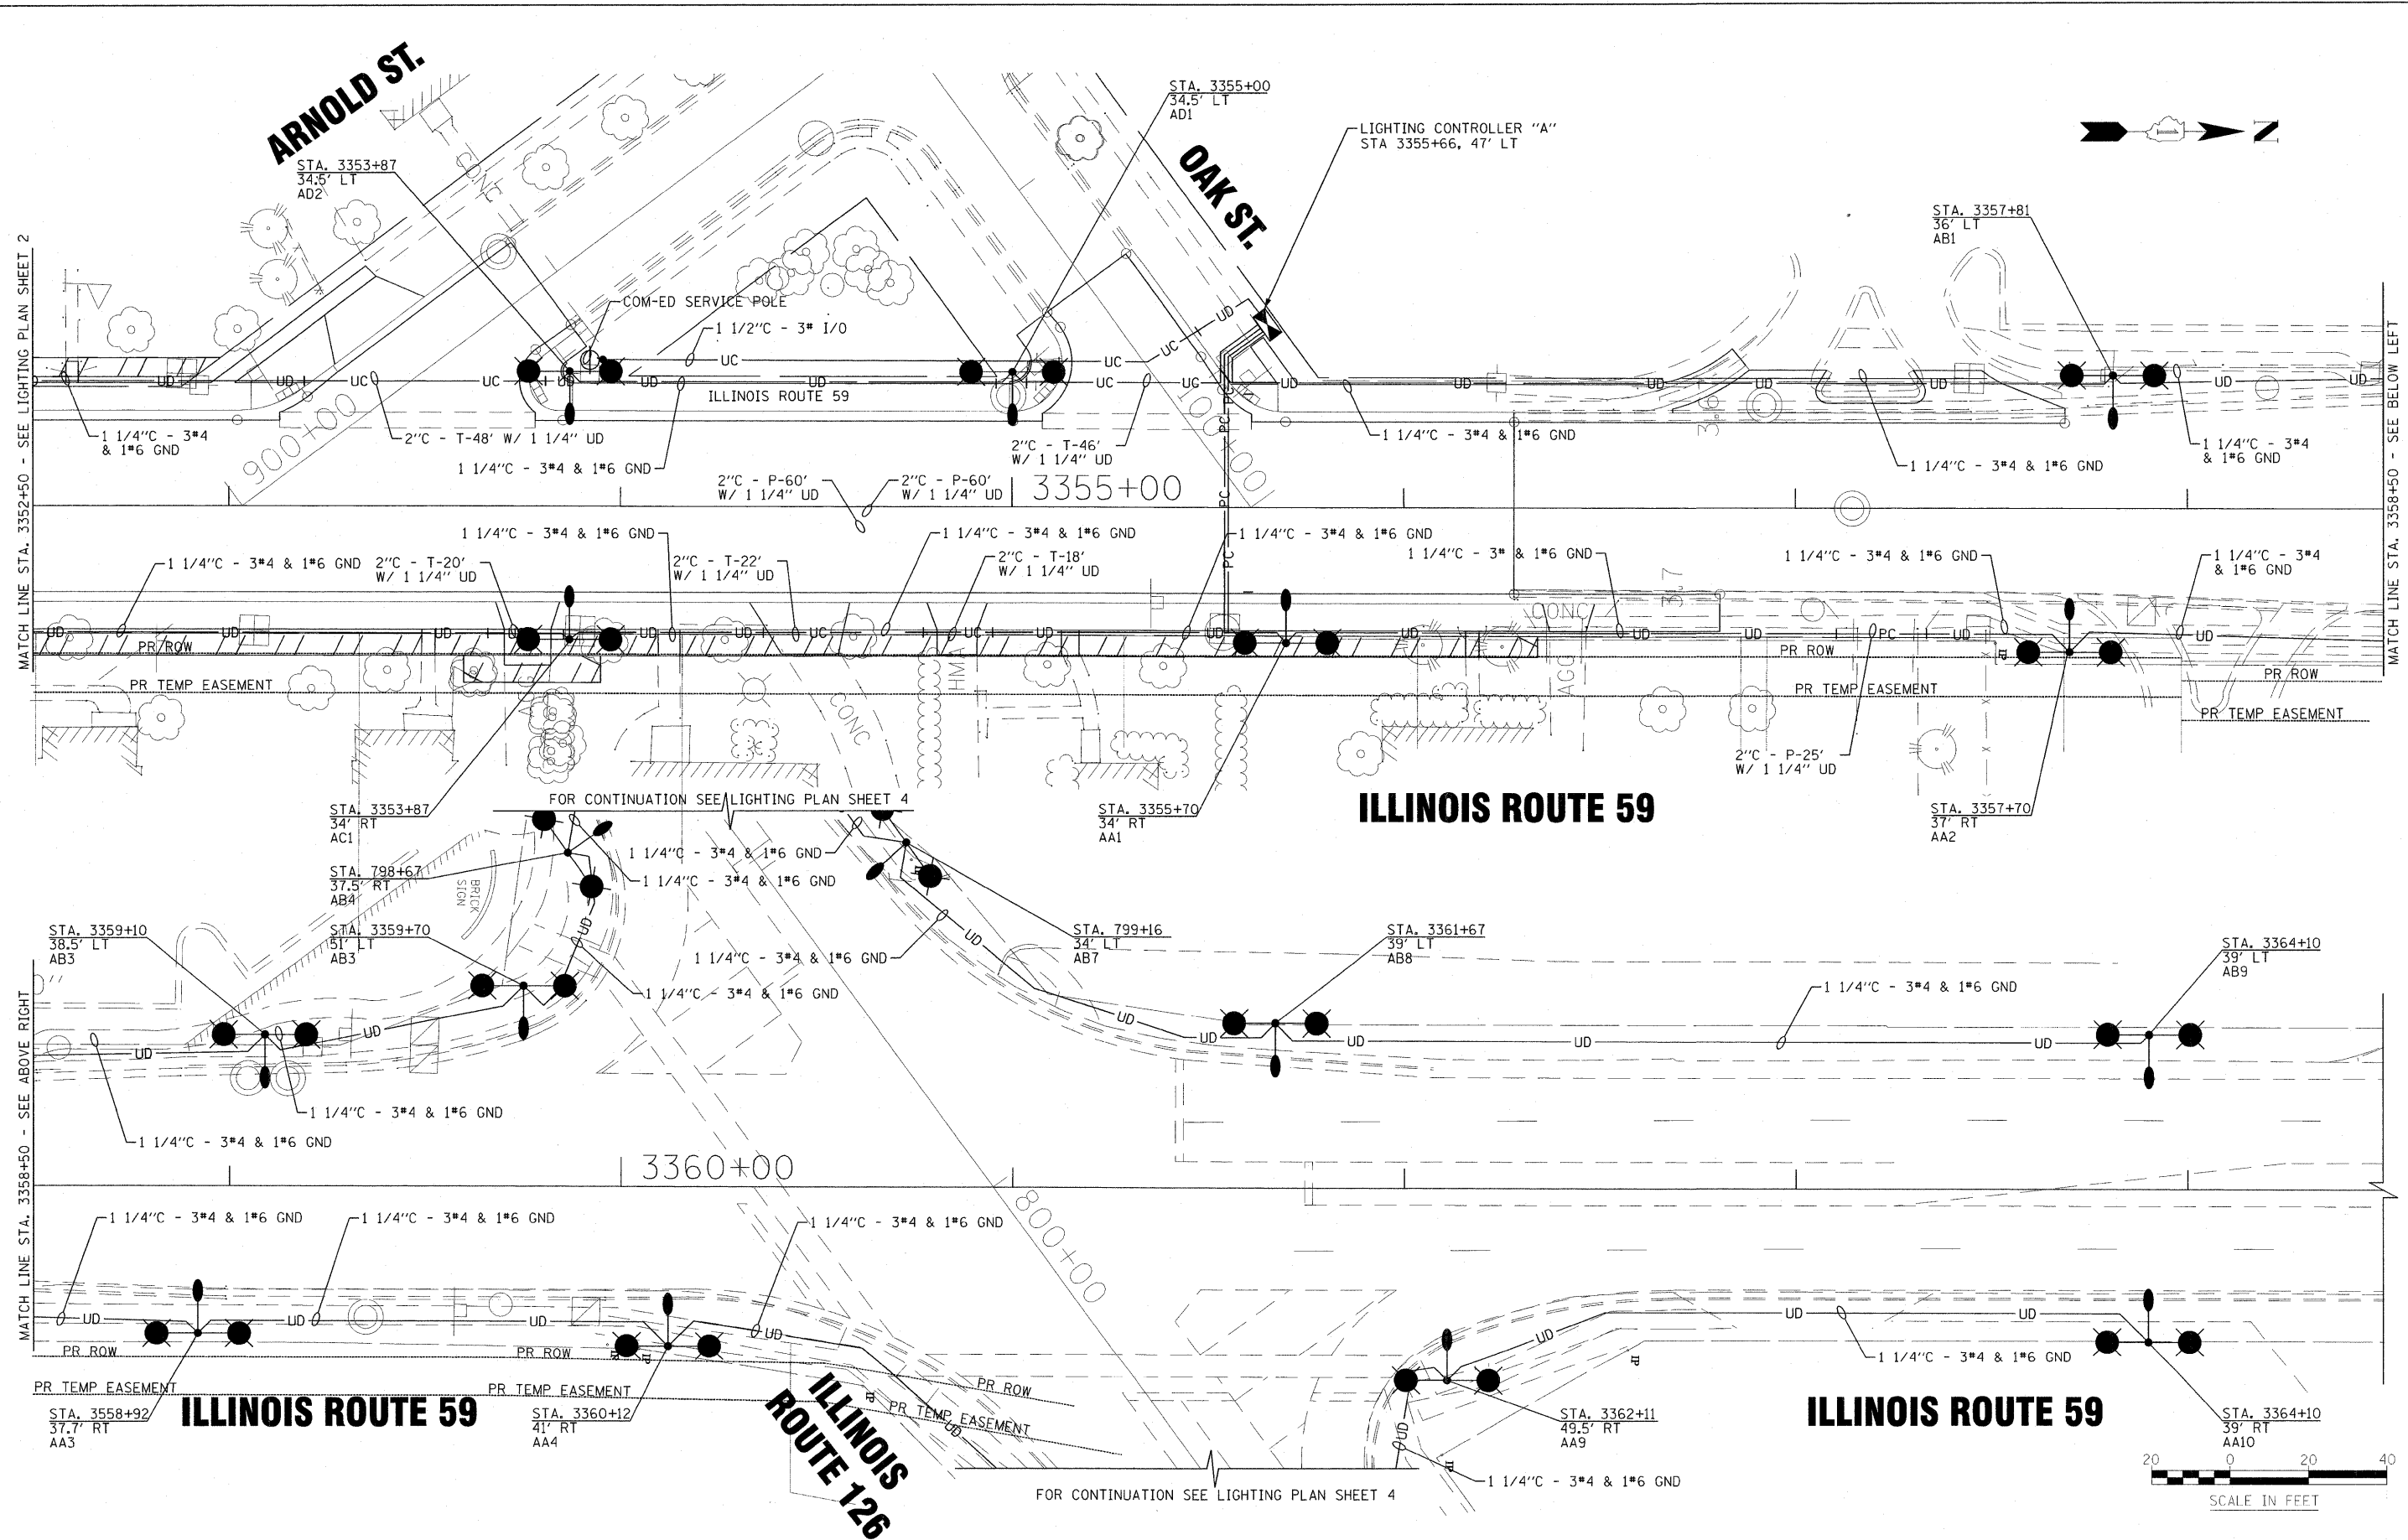

USER NAME = 263mac	DESIGNED - SMV	REVISED - 10-06-08
PLOT SCALE = 20.0000' / IN.	DRAWN - KAR	REVISED -
PLOT DATE = 1/5/2009	CHECKED - SMV	REVISED -
	DATE - 06-13-08	REVISED -

STATE OF ILLINOIS
DEPARTMENT OF TRANSPORTATION

ILLINOIS ROUTE 59
LIGHTING PLAN - SHEET 3

SCALE: 1" = 20' SHEET NO. 3 OF 9 SHEETS STA. 3352+50 TO STA. 3364+00

F.A. RTE.	SECTION	COUNTY	TOTAL SHEETS NO.
338	113 N-2	WILL	260 / 69
FED. ROAD DIST. NO. ILLINOIS			CONTRACT NO. 60E73
FAP 338 (IL RTE. 59)			