


3/5/2009

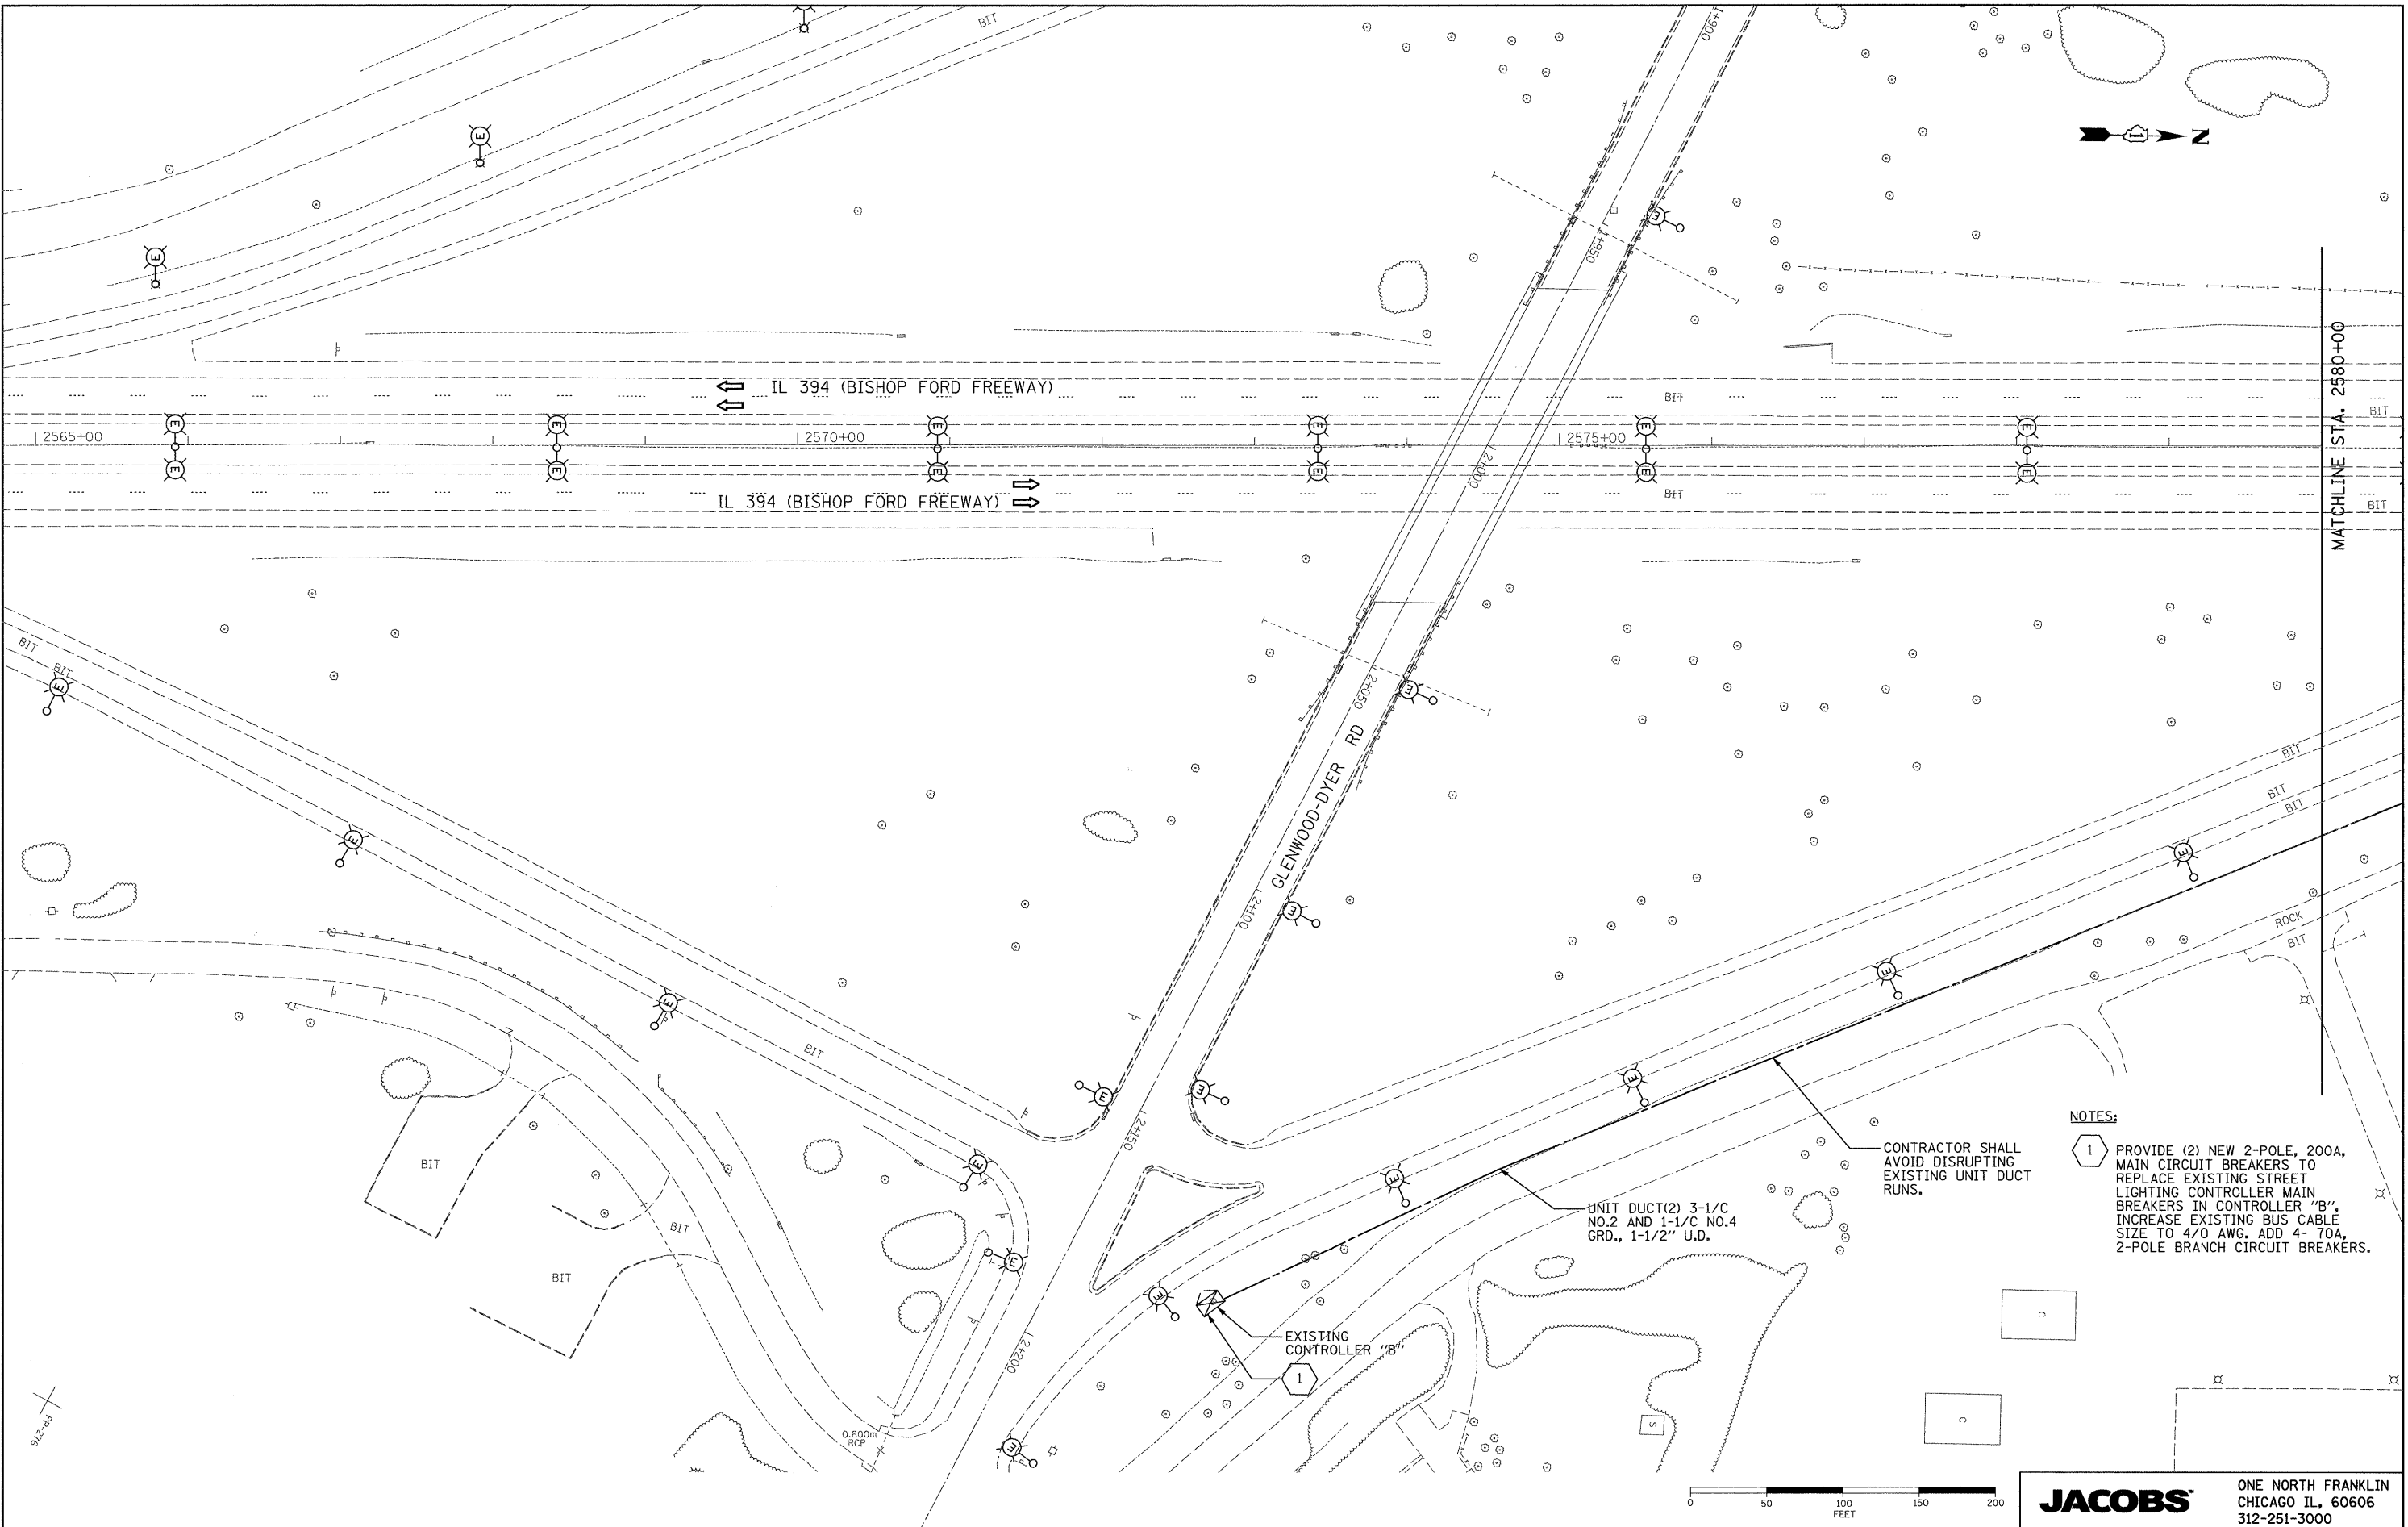

 
NOTES:

1 PROVIDE (2) NEW 2-POLE, 200A, MAIN CIRCUIT BREAKERS TO REPLACE EXISTING STREET LIGHTING CONTROLLER MAIN BREAKERS IN CONTROLLER "B", INCREASE EXISTING BUS CABLE SIZE TO 4/0 AWG. ADD 4- 70A, 2-POLE BRANCH CIRCUIT BREAKERS.

CONTRACTOR SHALL AVOID DISRUPTING EXISTING UNIT DUCT RUNS.

UNIT DUCT(2) 3-1/C NO.2 AND 1-1/C NO.4 GRD., 1-1/2" U.D.

EXISTING CONTROLLER "B"



FILE NAME =
 P:_2009\C9X93600\CADD\Sheets\Lighting\Proposed_Sheet_02.dgn

USER NAME = default
 DESIGNED - HS
 DRAWN - MJO/HS
 CHECKED - CDS
 PLOT DATE = 3/5/2009

REVISIONS:
 REVISION NO. | DATE | BY | DESCRIPTION

**STATE OF ILLINOIS
 DEPARTMENT OF TRANSPORTATION**

PROPOSED LIGHTING PLAN

SCALE: 1"=50' SHEET NO. OF SHEETS STA. TO STA. 2580+00

JACOBS		ONE NORTH FRANKLIN CHICAGO IL, 60606 312-251-3000		
F.A.P. RTE.	SECTION	COUNTY	TOTAL SHEETS	SHEET NO.
332	2008-081 L	COOK	18	4
CONTRACT NO. 60FB3				
FED. ROAD DIST. NO.		ILLINOIS FED. AID PROJECT		

P:_2009\C9X93600\CADD\Sheets\Lighting\Proposed_Sheet_02.dgn