


3/5/2009

P:\2009\C9X93600\CADD\Sheets\Lighting\Proposed_Sheet_B4.dgn

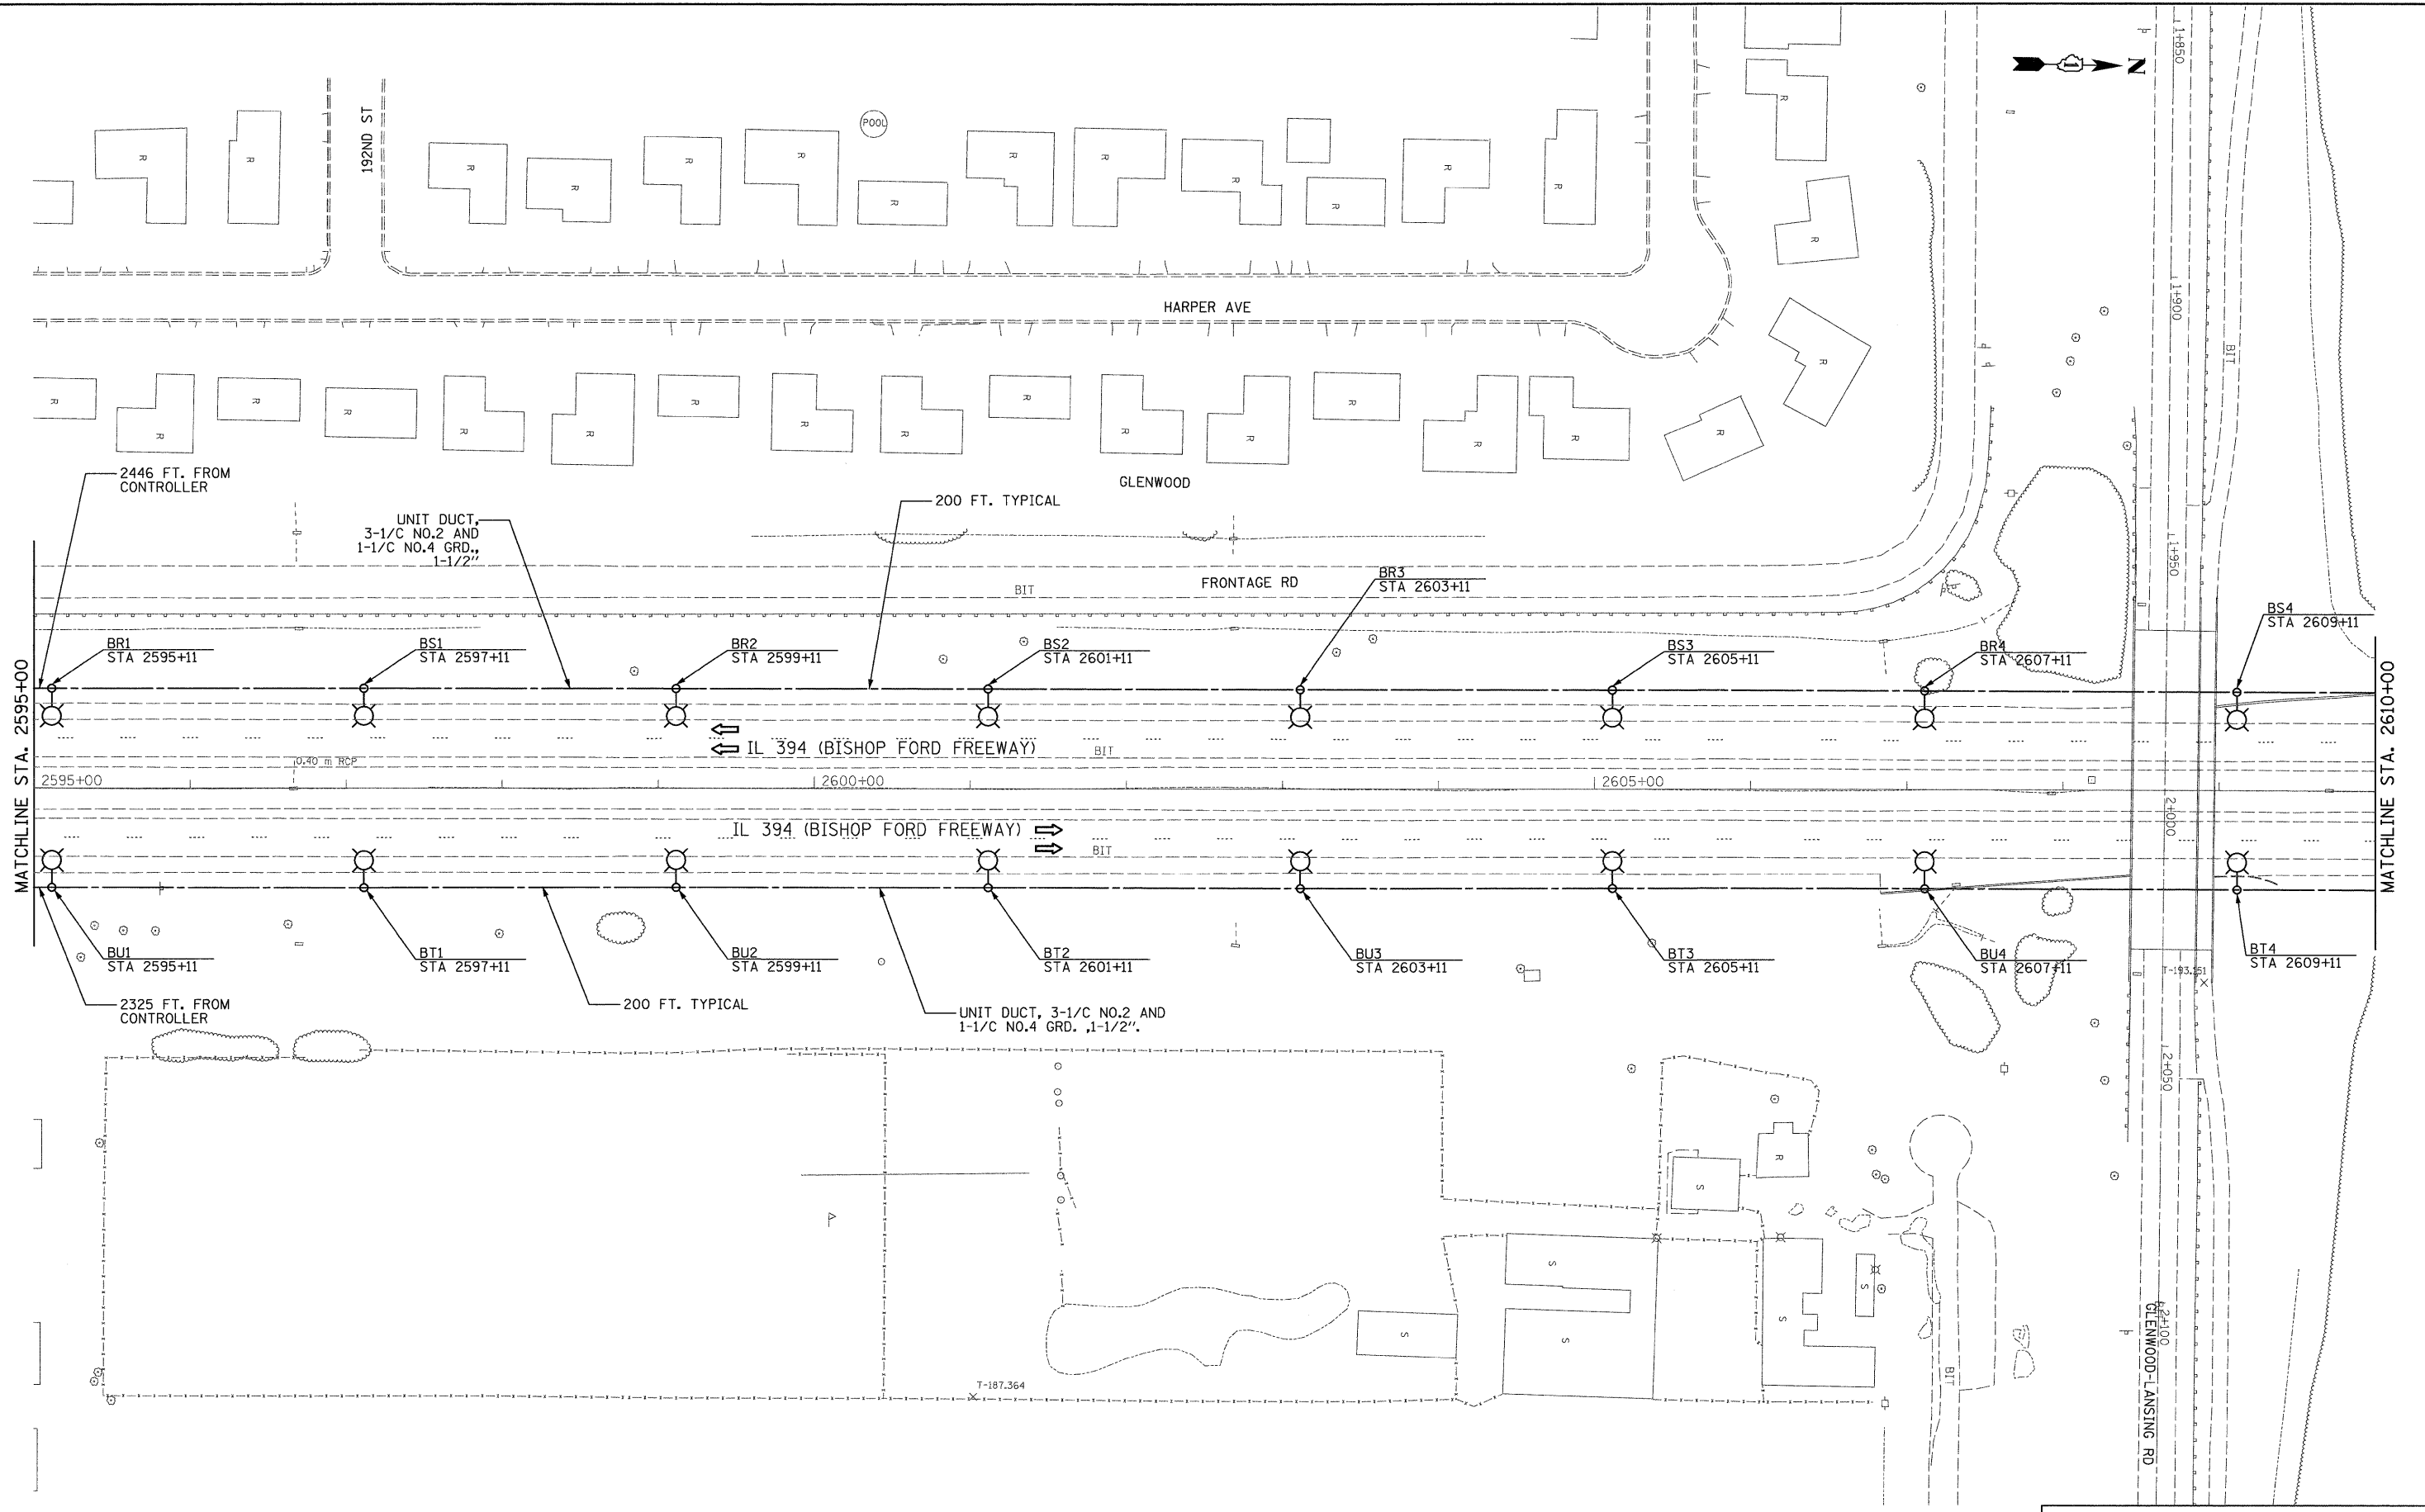

FILE NAME =	USER NAME = default	DESIGNED - HS	REVISED -
P:\2009\C9X93600\CADD\Sheets\Lighting\Proposed_Sheet_B4.dgn	Proposed_Sheet_B4.dgn	DRAWN - MJO/HS	REVISED -
PLOT SCALE = #SCALE#	CHECKED - CDS	REVISED -	REVISED -
PLOT DATE = 3/5/2009	DATE - 3/5/2009	REVISED -	REVISED -

**STATE OF ILLINOIS
DEPARTMENT OF TRANSPORTATION**

PROPOSED LIGHTING PLAN

SCALE: 1"=50' SHEET NO. OF SHEETS STA. 2595+00 TO STA. 2610+00

JACOBS		ONE NORTH FRANKLIN CHICAGO IL, 60606 312-251-3000		
F.A.P. RTE. 332	SECTION 2008-081 L	COUNTY COOK	TOTAL SHEETS 18	SHEET NO. 6
FED. ROAD DIST. NO.		ILLINOIS FED. AID PROJECT		
CONTRACT NO. 60F83				