


3/5/2009

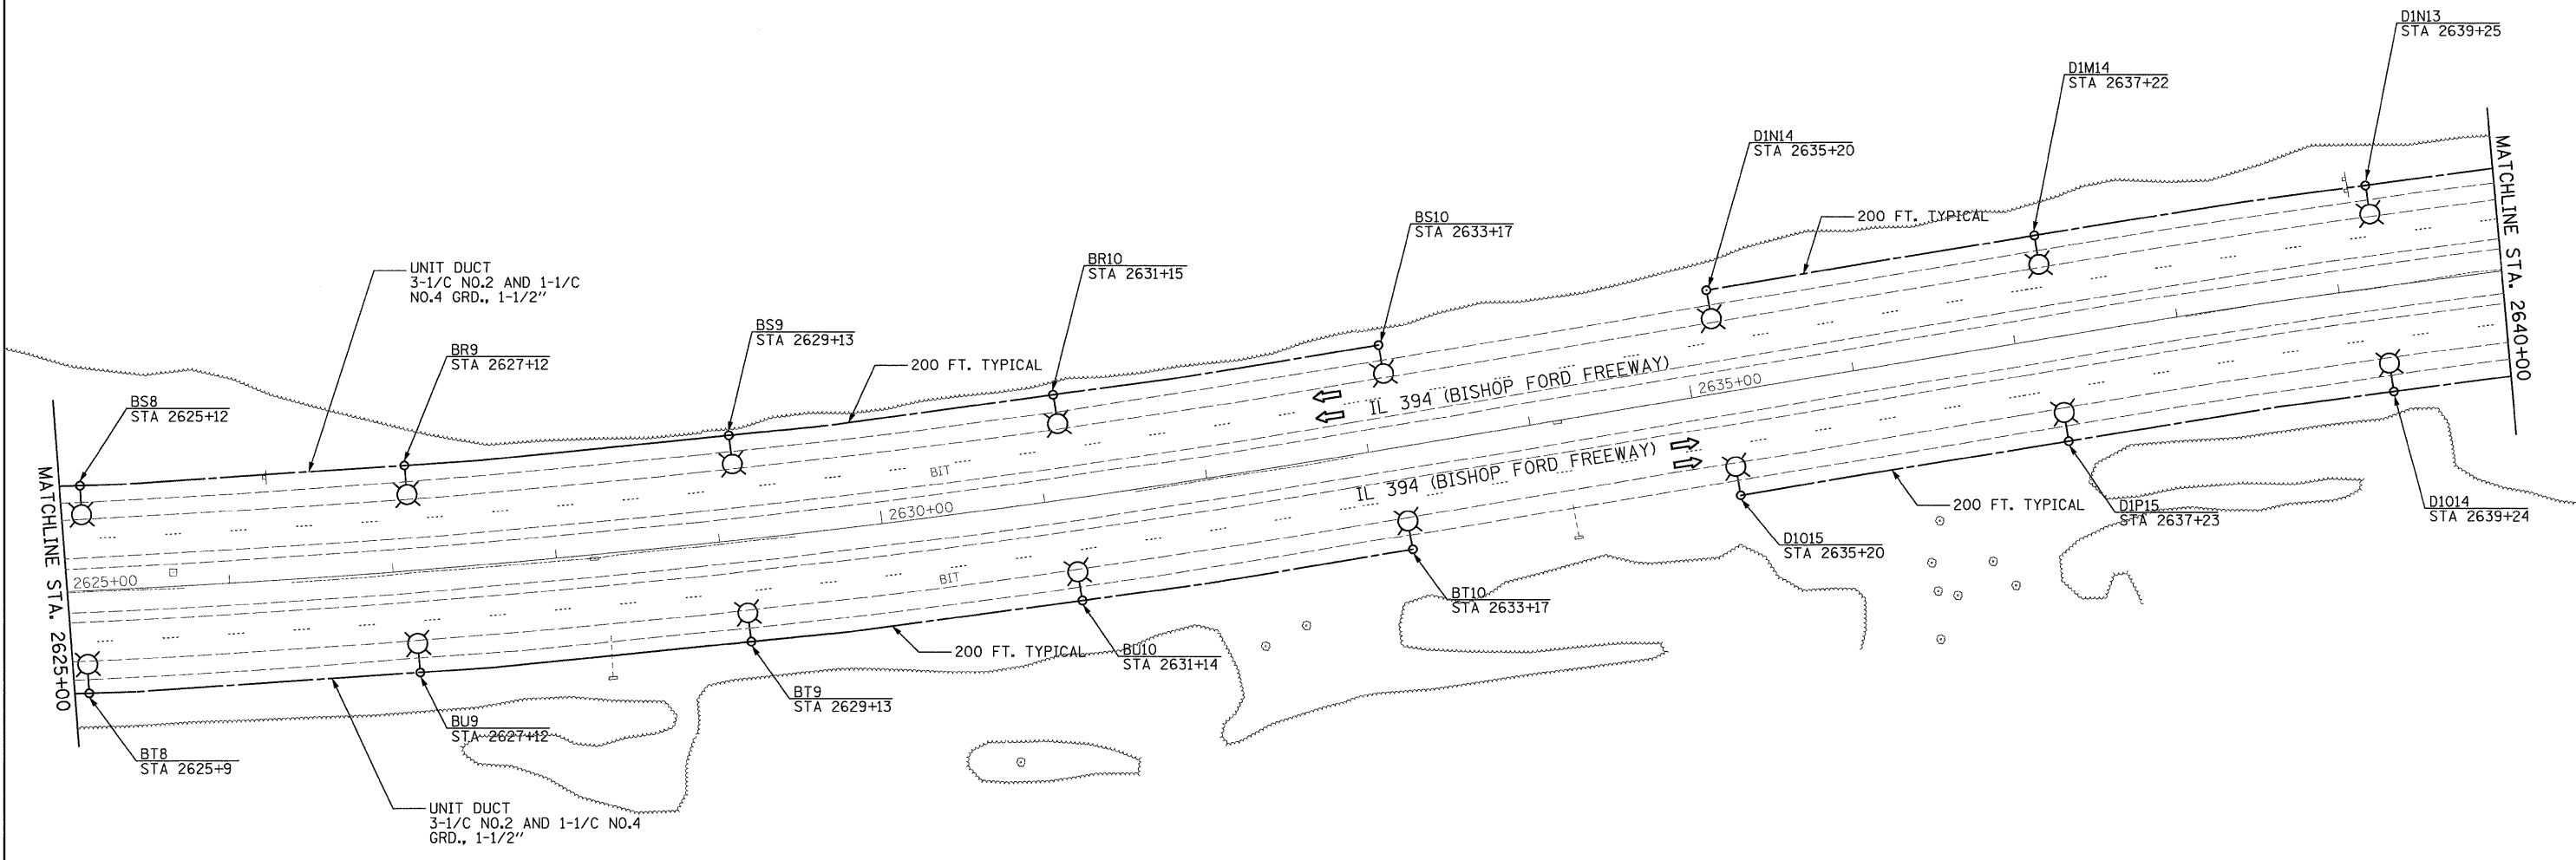

FILE NAME =	USER NAME = default	DESIGNED - HS	REVISED -
P:_2009\C9X93600\CADD\Sheets\Lighting\Proposed_Sheet 06.dgn	Proposed_Sheet 06.dgn	DRAWN - MJO/HS	REVISED -
	PLOT SCALE = #SCALE#	CHECKED - CDS	REVISED -
	PLOT DATE = 3/5/2009	DATE - 3/5/2009	REVISED -

**STATE OF ILLINOIS
DEPARTMENT OF TRANSPORTATION**

PROPOSED LIGHTING PLAN

SCALE: 1"=50' SHEET NO. OF SHEETS STA. 2625+00 TO STA. 2640+00

JACOBS		ONE NORTH FRANKLIN CHICAGO IL, 60606 312-251-3000		
F.A.P. RTE.	SECTION	COUNTY	TOTAL SHEETS	SHEET NO.
332	2008-081 L	COOK	18	8
CONTRACT NO. 60F83				
FED. ROAD DIST. NO.		ILLINOIS FED. AID PROJECT		

P:_2009\C9X93600\CADD\Sheets\Lighting\Proposed_Sheet 06.dgn