 



3/5/2009

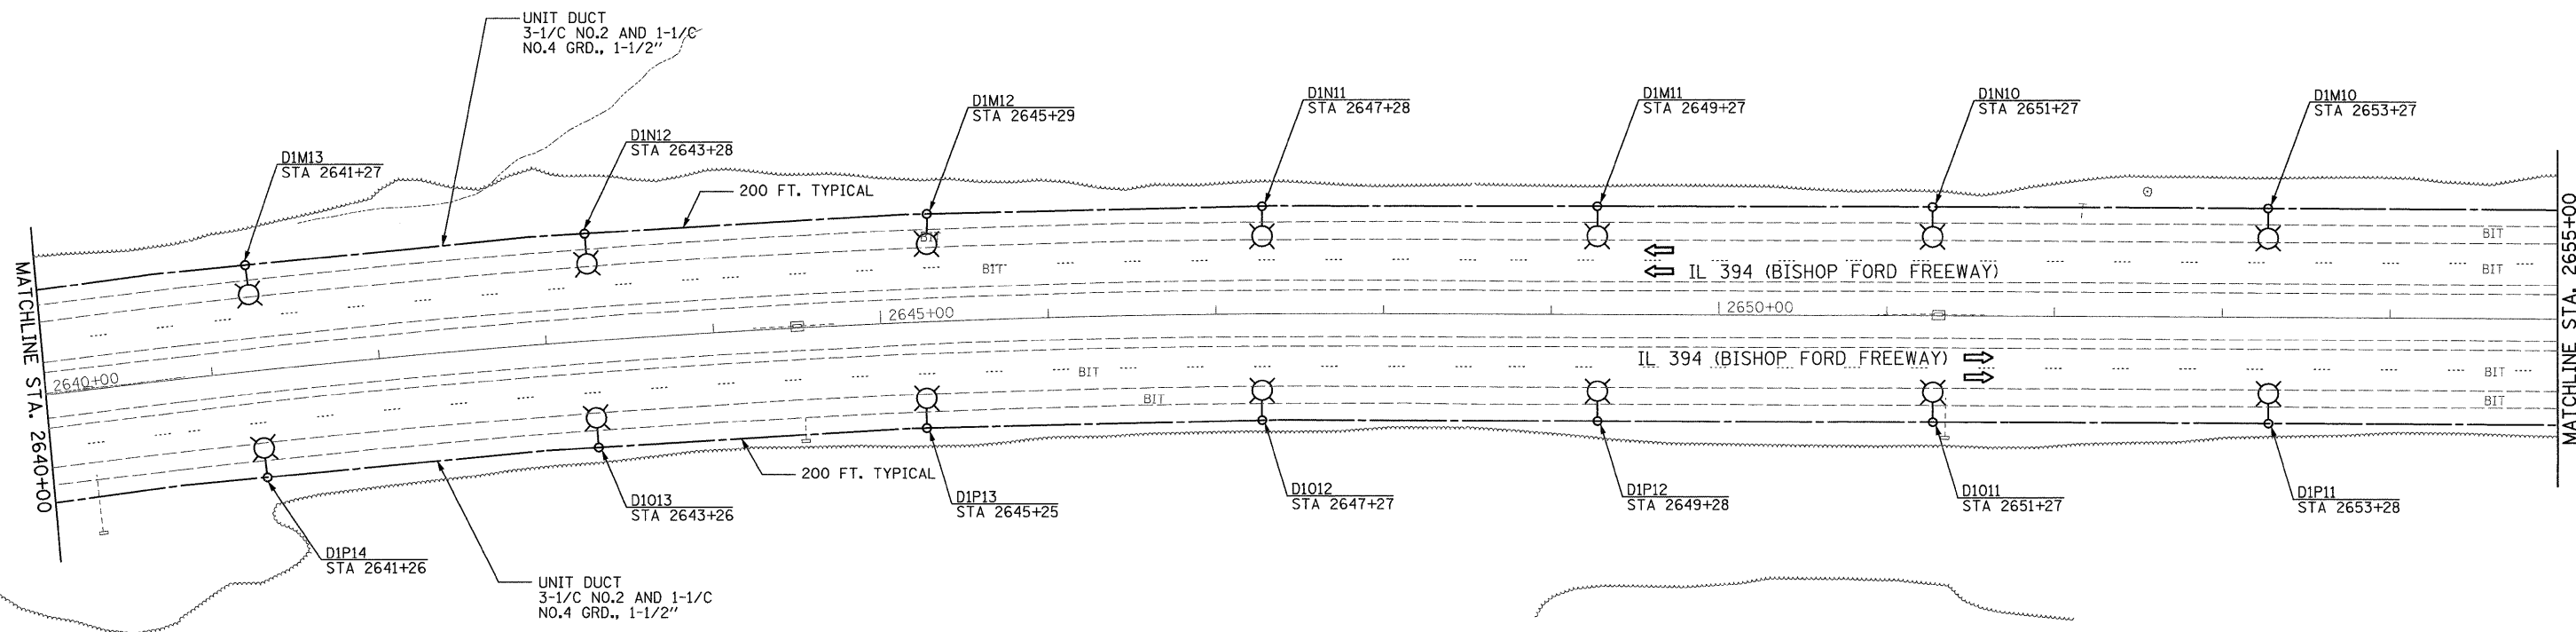

FILE NAME =
 Pt:\2009\C9X93600\CADD\Sheets\Lighting\Proposed_Sheet_07.dgn

USER NAME = default
 Proposed_Sheet_07.dgn
 PLOT SCALE = #SCALE#
 PLOT DATE = 3/5/2009

DESIGNED - HS
 DRAWN - MJO/HS
 CHECKED - CDS
 DATE - 3/5/2009

REVISED -
 REVISED -
 REVISED -
 REVISED -

**STATE OF ILLINOIS
 DEPARTMENT OF TRANSPORTATION**

PROPOSED LIGHTING PLAN

SCALE: 1"=50' SHEET NO. OF SHEETS STA. 2640+00 TO STA. 2655+00

JACOBS		ONE NORTH FRANKLIN CHICAGO IL, 60606 312-251-3000		
F.A.P. RTE. 332	SECTION 2008-081 L	COUNTY COOK	TOTAL SHEETS 18	SHEET NO. 9
FED. ROAD DIST. NO.		ILLINOIS FED. AID PROJECT		
CONTRACT NO. 60F83				

Pt:\2009\C9X93600\CADD\Sheets\Lighting\Proposed_Sheet_07.dgn