


3/5/2009

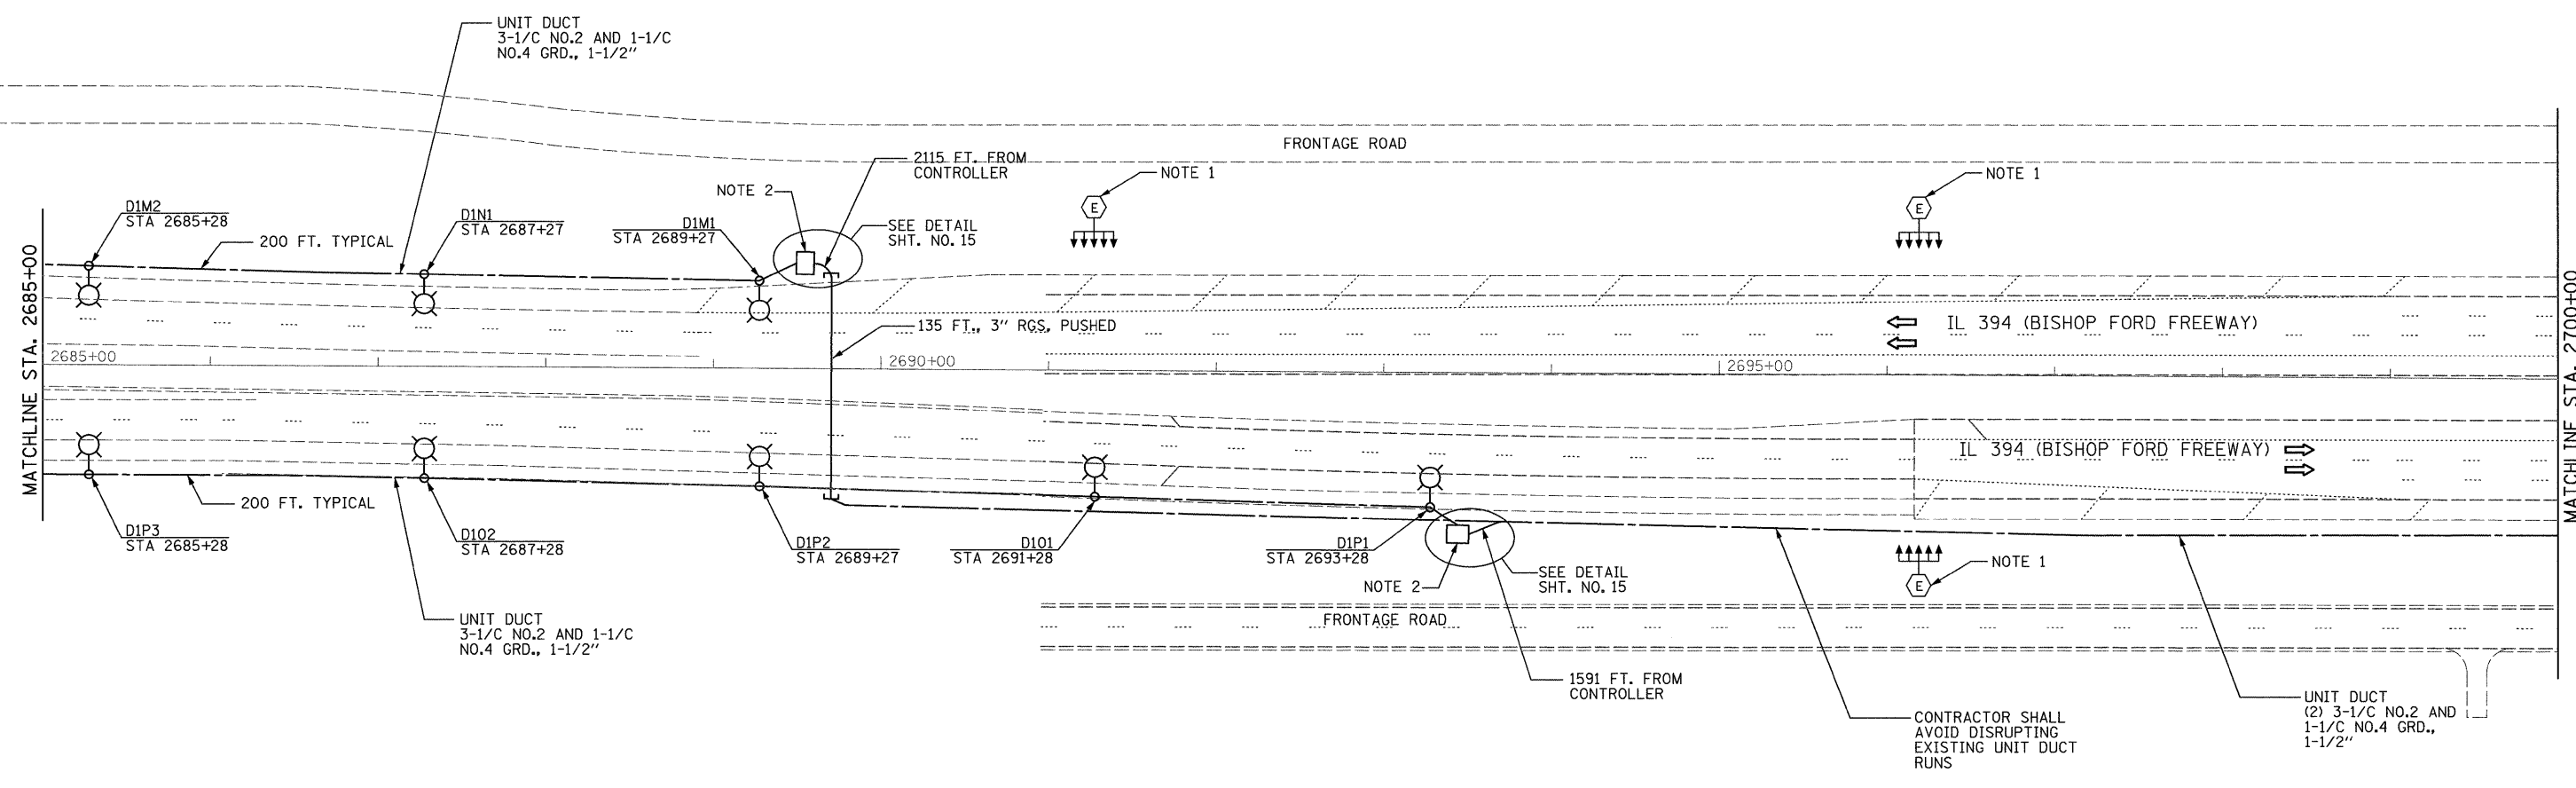

- NOTES:**
- EXISTING HIGH MAST LIGHTING ON LIGHTING CONTROLLER "D1", (5) 400W FIXTURES PER TOWER IS SHOWN FOR INFORMATION ONLY- NOT PART OF THIS CONTRACT.
  - (2) 7.5 KVA BUCK BOOST TRANSFORMERS, SINGLE PHASE, 216 IN - 258 OUT, IN NEMA-3R PEDESTAL MOUNT ENCLOSURE (TYPICAL 2 PLACES). SEE ELECTRICAL DETAILS SHEET FOR MOUNTING DETAIL. TRANSFORMERS SHALL BE LOCATED 30 FT. SETBACK FROM THE EDGE OF TRAVELED PAVEMENT.



**JACOBS** ONE NORTH FRANKLIN  
CHICAGO IL, 60606  
312-251-3000

F.A.P. RTE.	SECTION	COUNTY	TOTAL SHEETS	SHEET NO.
332	2008-081 L	COOK	18	12
CONTRACT NO. 60F83				

FED. ROAD DIST. NO. ILLINOIS FED. AID PROJECT

**STATE OF ILLINOIS  
DEPARTMENT OF TRANSPORTATION**

**PROPOSED LIGHTING PLAN**

FILE NAME =	USER NAME = default	DESIGNED - HS	REVISED -
P:\_2009\C9X93600\CADD\Sheets\Lighting\Proposed_Sheet_10.dgn	Proposed_Sheet_10.dgn	DRAWN - MJO/HS	REVISED -
PLOT SCALE = #SCALE#		CHECKED - CDS	REVISED -
PLOT DATE = 3/5/2009		DATE - 3/5/2009	REVISED -

SCALE: 1"=50' SHEET NO. OF SHEETS STA. 2685+00 TO STA. 2700+00

P:\\_2009\C9X93600\CADD\Sheets\Lighting\Proposed\_Sheet\_10.dgn