



F.A. RTE.	SECTION	COUNTY	TOTAL SHEETS	SHEET NO.
332	2008-081.L	COOK	18	18
STA.		TO STA.		
FED. ROAD DIST. NO.	ILLINOIS	FED. AID PROJECT		

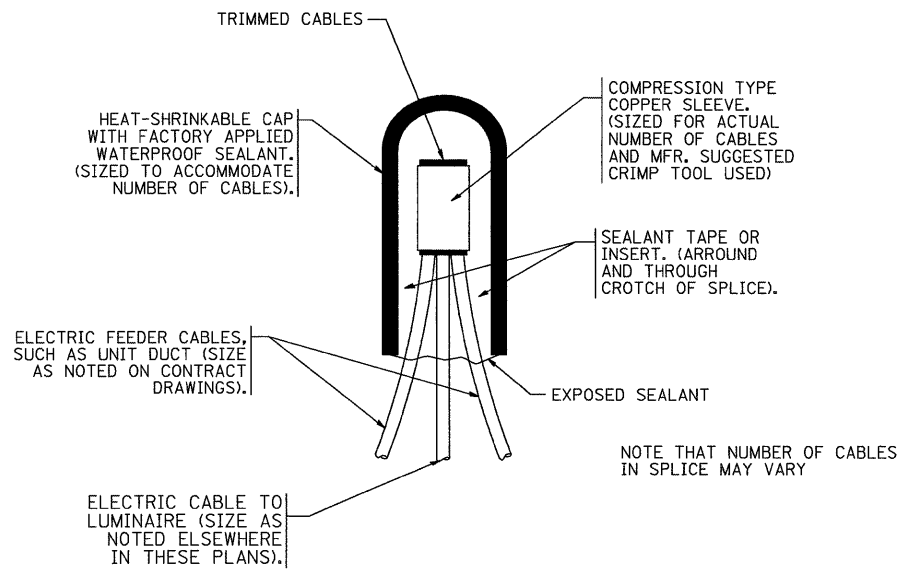

TYPICAL SPLICE DETAIL

N.T.S.

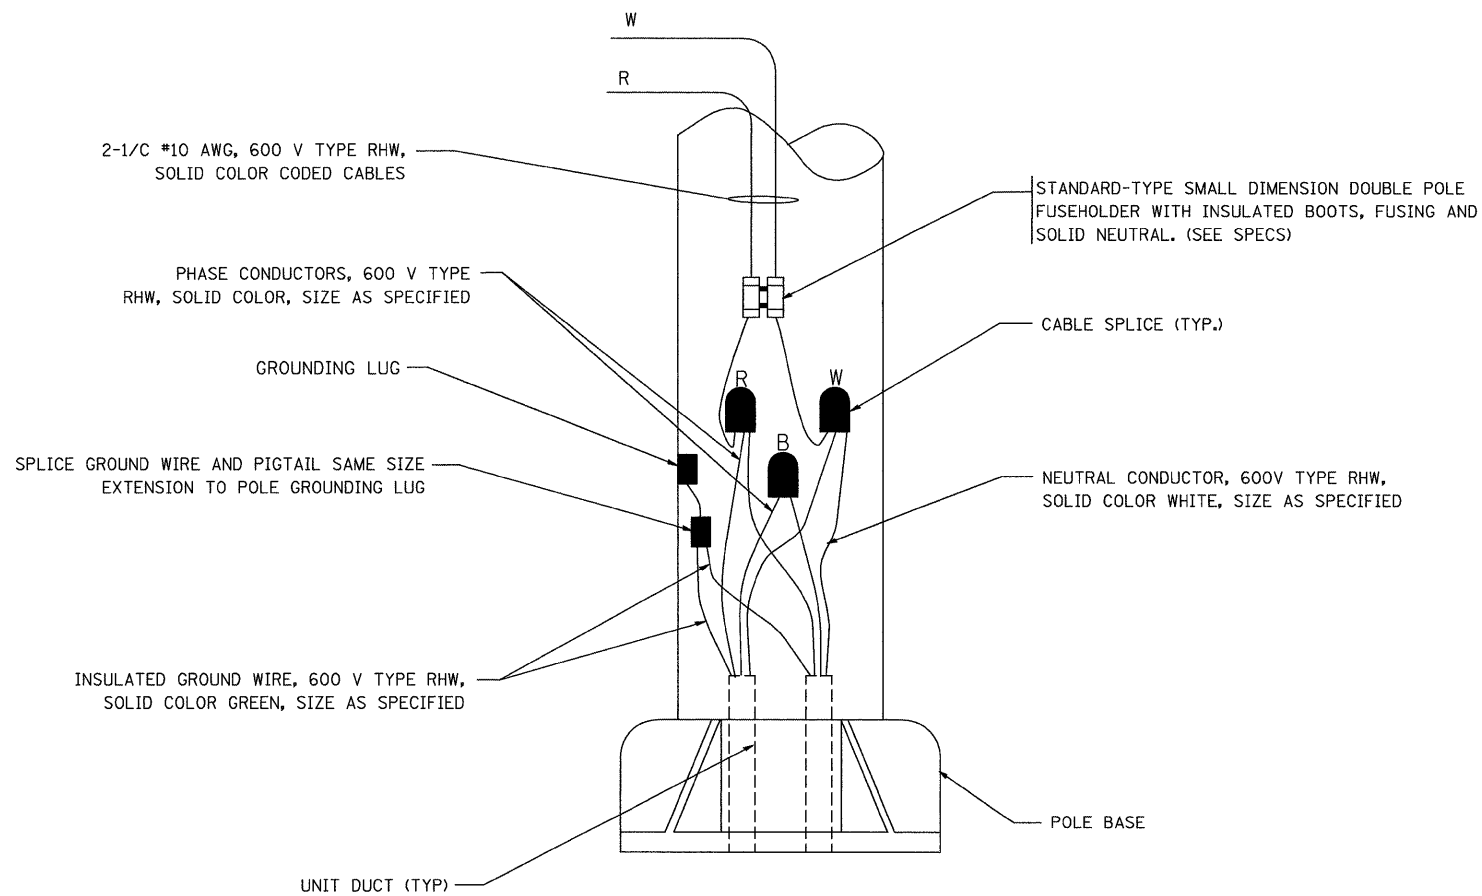

POLE WIRING DETAIL

N.T.S.

REVISIONS	
NAME	DATE
	08/08/03

ILLINOIS DEPARTMENT OF TRANSPORTATION

MISC. ELECTRICAL DETAILS  
SHEET A

SCALE: VERT. NONE  
HORIZ.

DRAWN BY

CHECKED BY

FILE NAME =	USER NAME = default	DESIGNED -	REVISED -
P:\2009\C9X93600\CADD\Sheets\Lighting\Proposed_Sheet_16_BE702.dgn		DRAWN -	REVISED -
PLOT SCALE = #SCALE#		CHECKED -	REVISED -
PLOT DATE = 3/5/2009		DATE -	REVISED -

STATE OF ILLINOIS  
DEPARTMENT OF TRANSPORTATION

MISC. ELECTRICAL DETAILS  
SHEET A  
BE-702

SCALE: N.T.S. SHEET NO. OF SHEETS STA. - TO STA. -

F.A.P. RTE.	SECTION	COUNTY	TOTAL SHEETS	SHEET NO.
332	2008-081 L	COOK	18	18
FED. ROAD DIST. NO.		ILLINOIS FED. AID PROJECT		
CONTRACT NO. 60F83				

3/5/2009

P:\2009\C9X93600\CADD\Sheets\Lighting\Proposed\_Sheet\_16\_BE702.dgn