
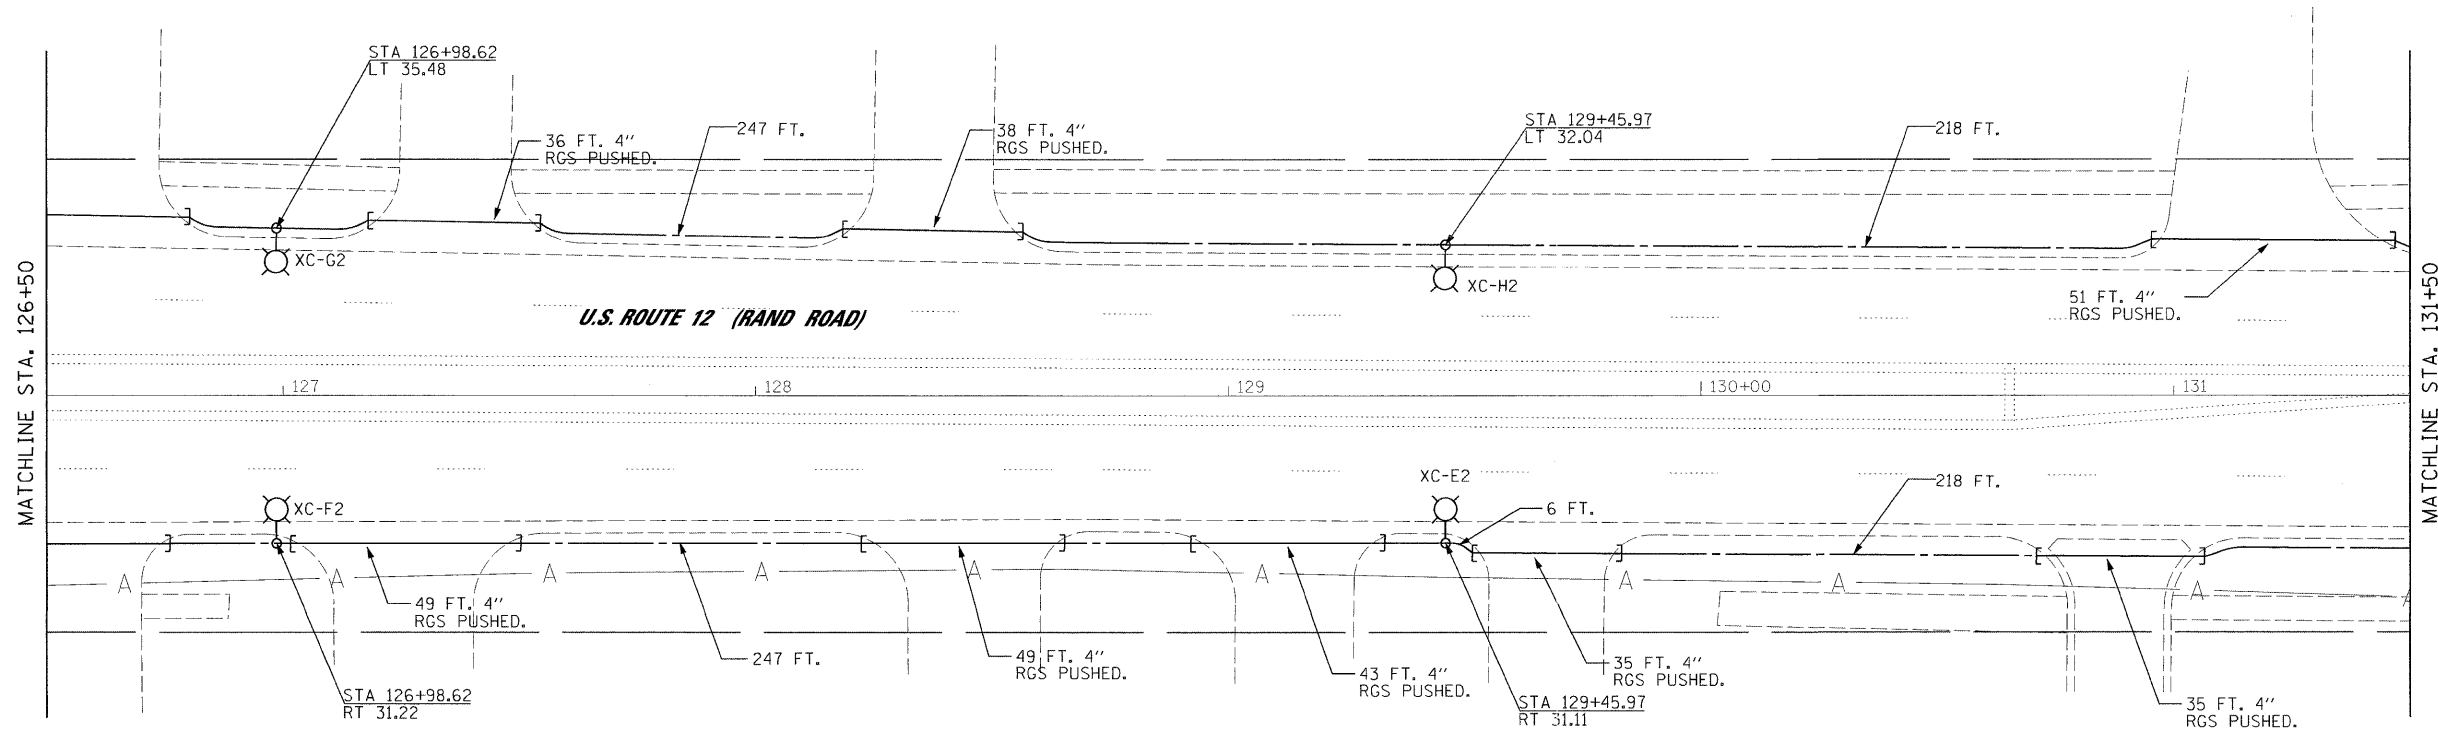


3/4/2009

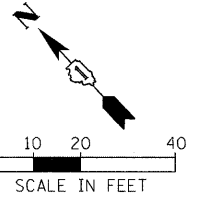

p:\2008\953700\Cadd\Sheets\Lighting Plan\07_Rand 6.dgn

FILE NAME =
Lighting Plan_07_Rand 6.dgn

USER NAME = #USER#
PLOT SCALE = #SCALE#
PLOT DATE = 3/4/2009

DESIGNED - HS
DRAWN - MJO
CHECKED - CDS
DATE - 1/22/2009

REVISED -
REVISED -
REVISED -
REVISED -

**STATE OF ILLINOIS
DEPARTMENT OF TRANSPORTATION**

PROPOSED LIGHTING PLAN

SCALE: 1"=20' SHEET NO. OF SHEETS STA. 126+50 TO STA. 131+50

JACOBS		ONE NORTH FRANKLIN CHICAGO IL, 60606 312-251-3000		
F.A.P. RTE. 334	SECTION 2008-08-31	COUNTY COOK	TOTAL SHEETS 81	SHEET NO. 51
FED. ROAD DIST. NO.		ILLINOIS FED. AID PROJECT		
CONTRACT NO. 60F87				