
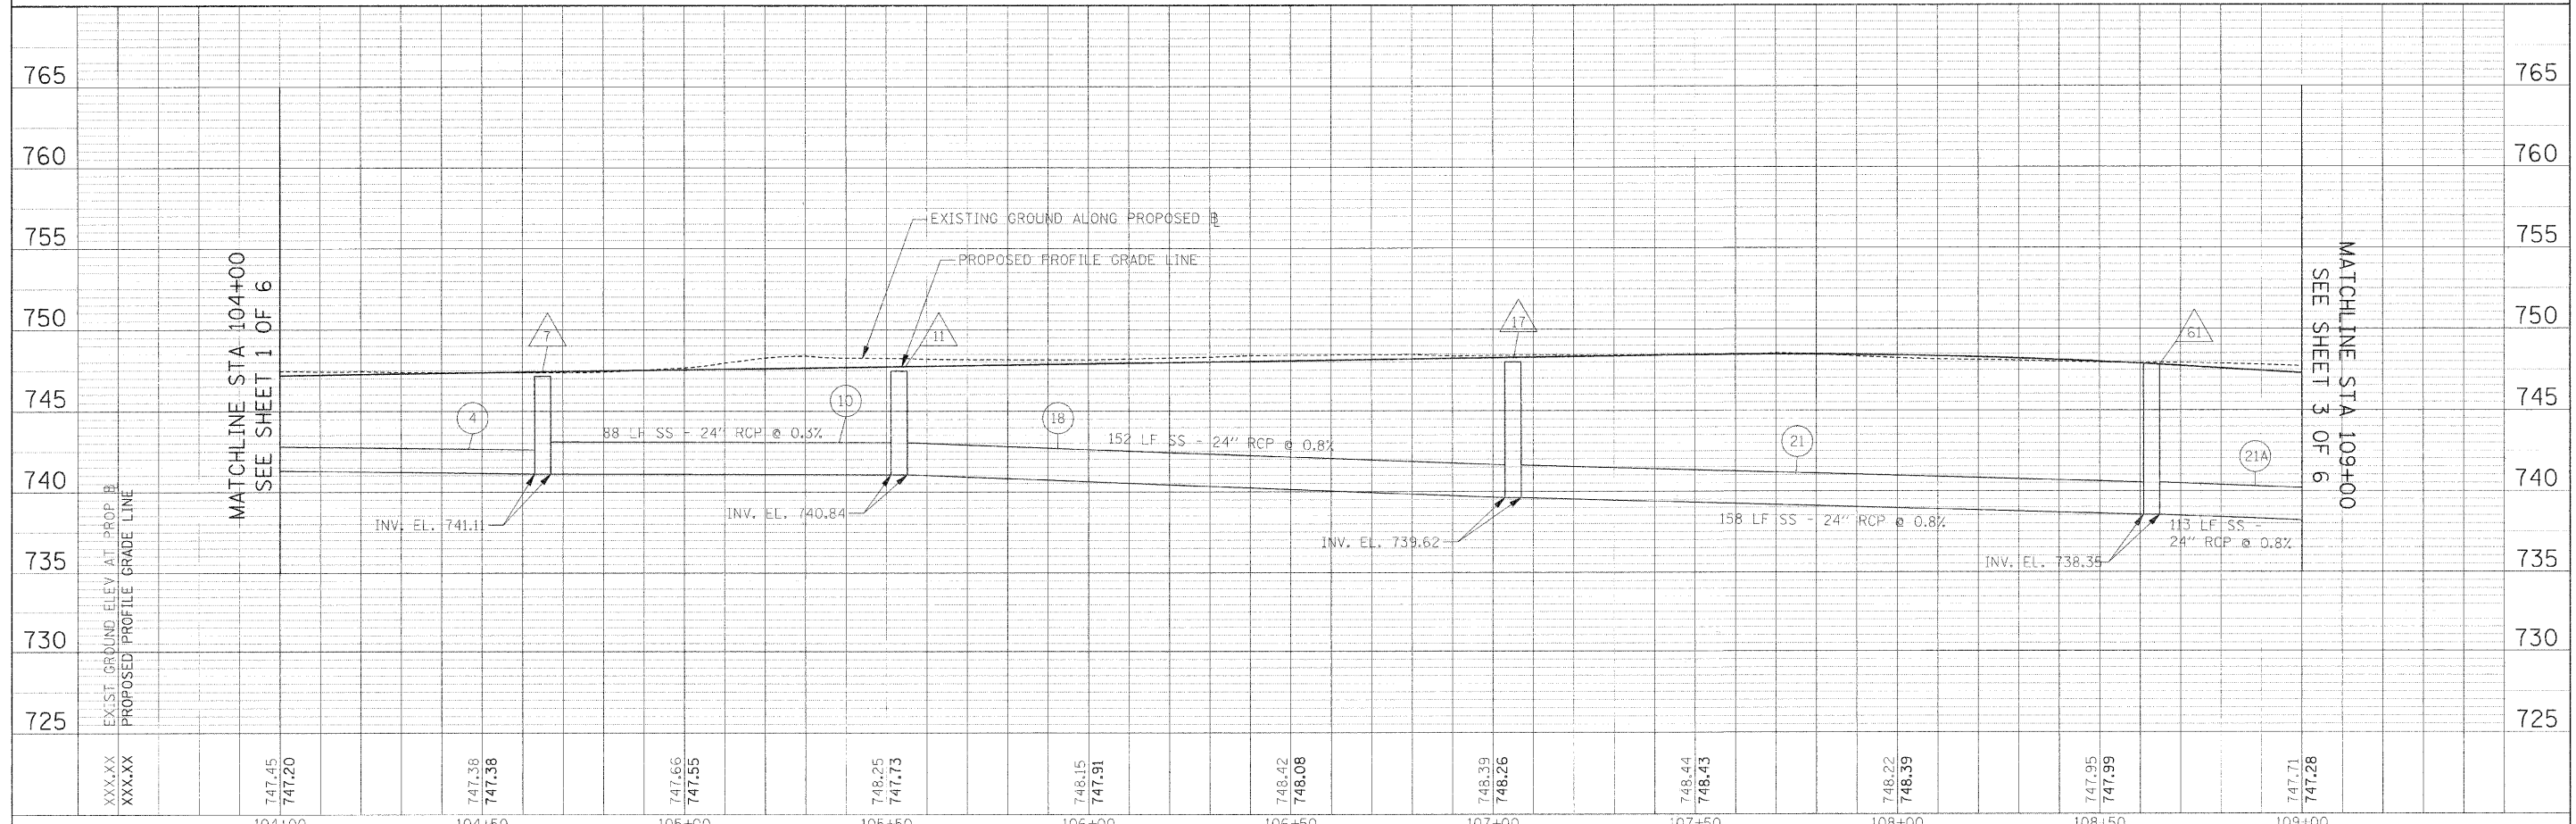


PLAN	SURVEYED	DATE
	PLOTTED	
	CHECKED	
	BY	
	NO. OF WAY CHECKED	
	FILE NAME	
	NO.	

PROFILE	SURVEYED	DATE
	PLOTTED	
	CHECKED	
	BY	
	NO. OF WAY CHECKED	
	FILE NAME	
	NO.	

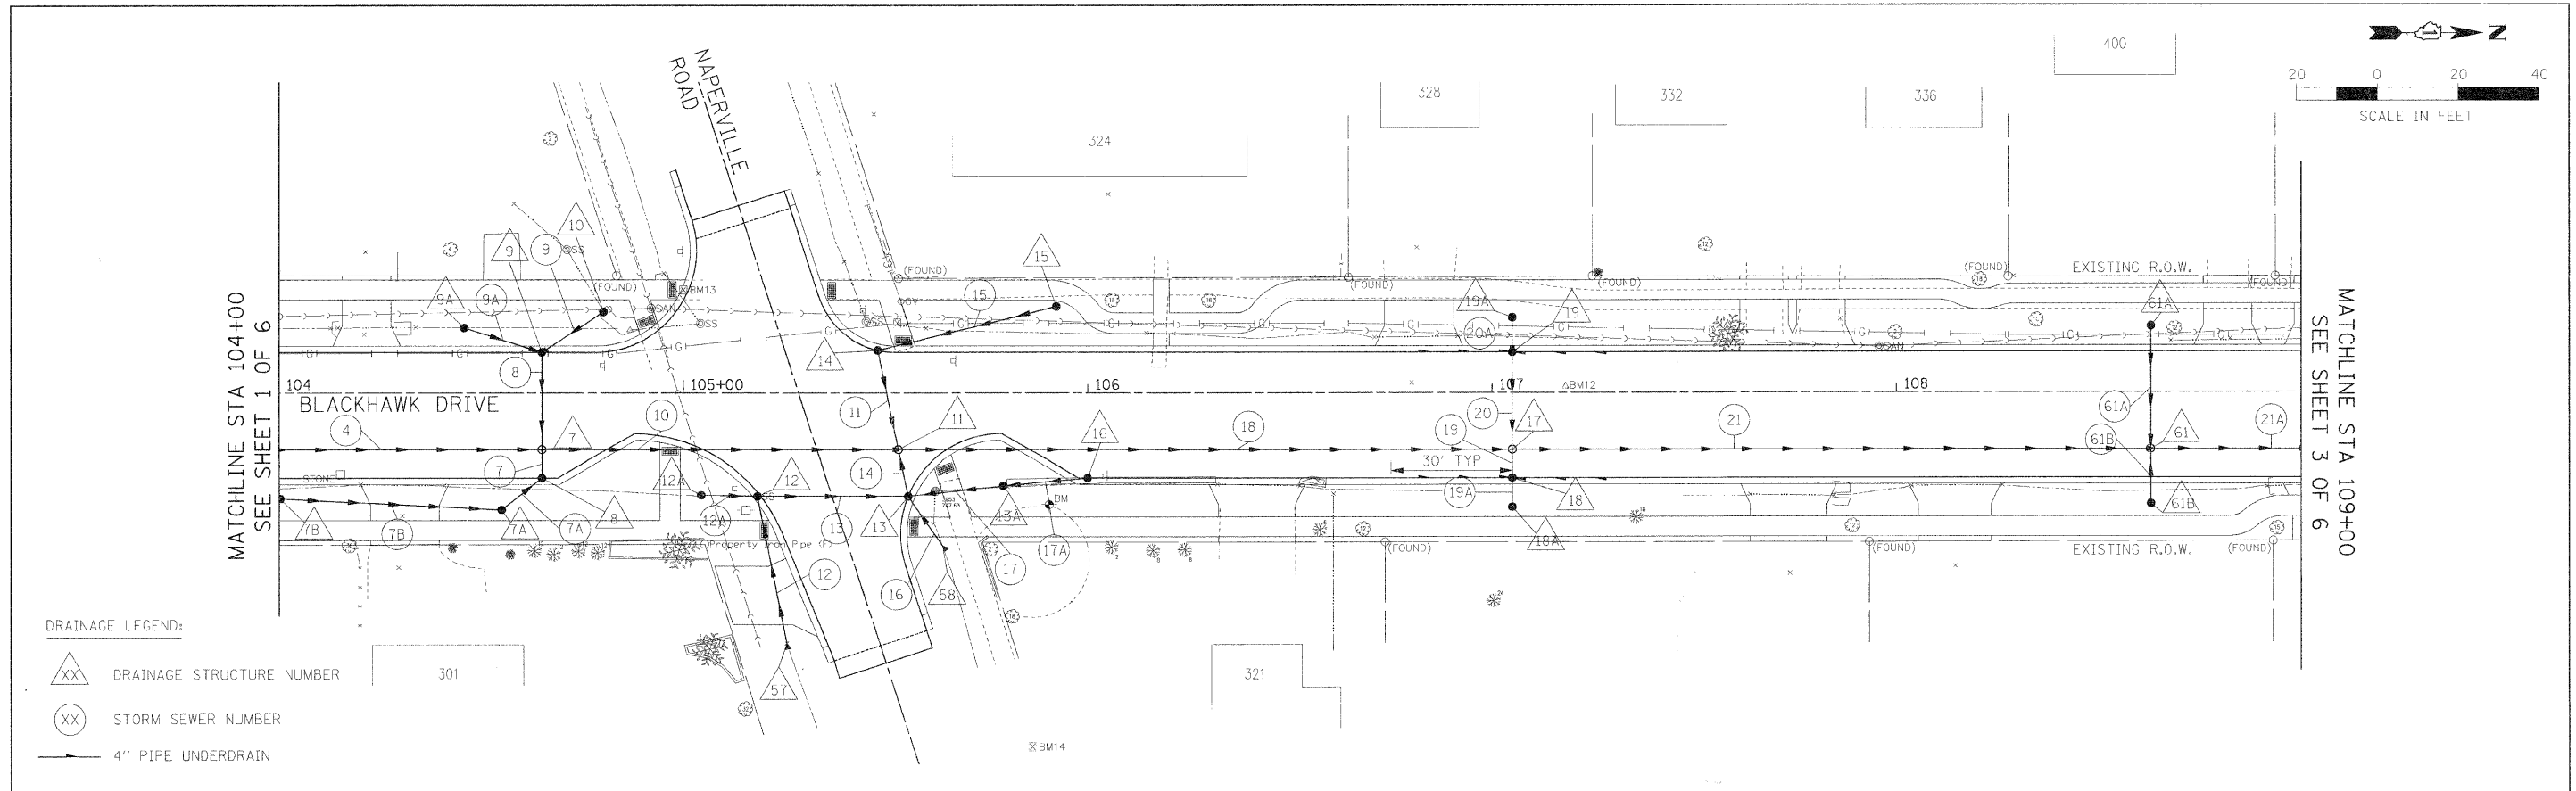

FILE NAME =	USER NAME = #USER#	DESIGNED - AJB	REVISED -	<b>STATE OF ILLINOIS DEPARTMENT OF TRANSPORTATION</b>	<b>DRAINAGE PLAN AND PROFILE</b>	F.A.U. RTL.	SECTION	COUNTY	TOTAL SHEETS	SHEET NO.	
#FILE#	PLLOT SCALE = #SCALE#	DRAWN - TMC	REVISED -			3003	00-00084-00-PV	DUPAGE	112	40	
	PLLOT DATE = #DATE#	CHECKED - DEB	REVISED -			BLACKHAWK DR RECONSTRUCTION	CONTRACT NO. 63121	FED. ROAD DIST. NO. 1   ILLINOIS FED. AID PROJECT			
		DATE - 01/02/09	REVISED -			SCALE: 1:20   SHEET NO. 2 OF 6 SHEETS   STA. 104+00.00 TO STA. 109+00.00					