
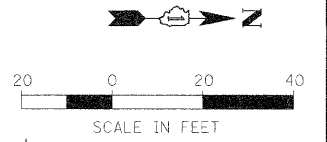


PLAN	SURVEYED	DATE
NO. _____	BY _____	_____
NOTE BOOK NO. _____	PROJECT NO. _____	
DATE CHECKED _____	BY _____	
FILE NAME _____		


PROFILE	SURVEYED	DATE
NO. _____	BY _____	_____
NOTE BOOK NO. _____	PROJECT NO. _____	
DATE CHECKED _____	BY _____	
FILE NAME _____		

MATCHLINE STA 119+00
SEE SHEET 4 OF 6

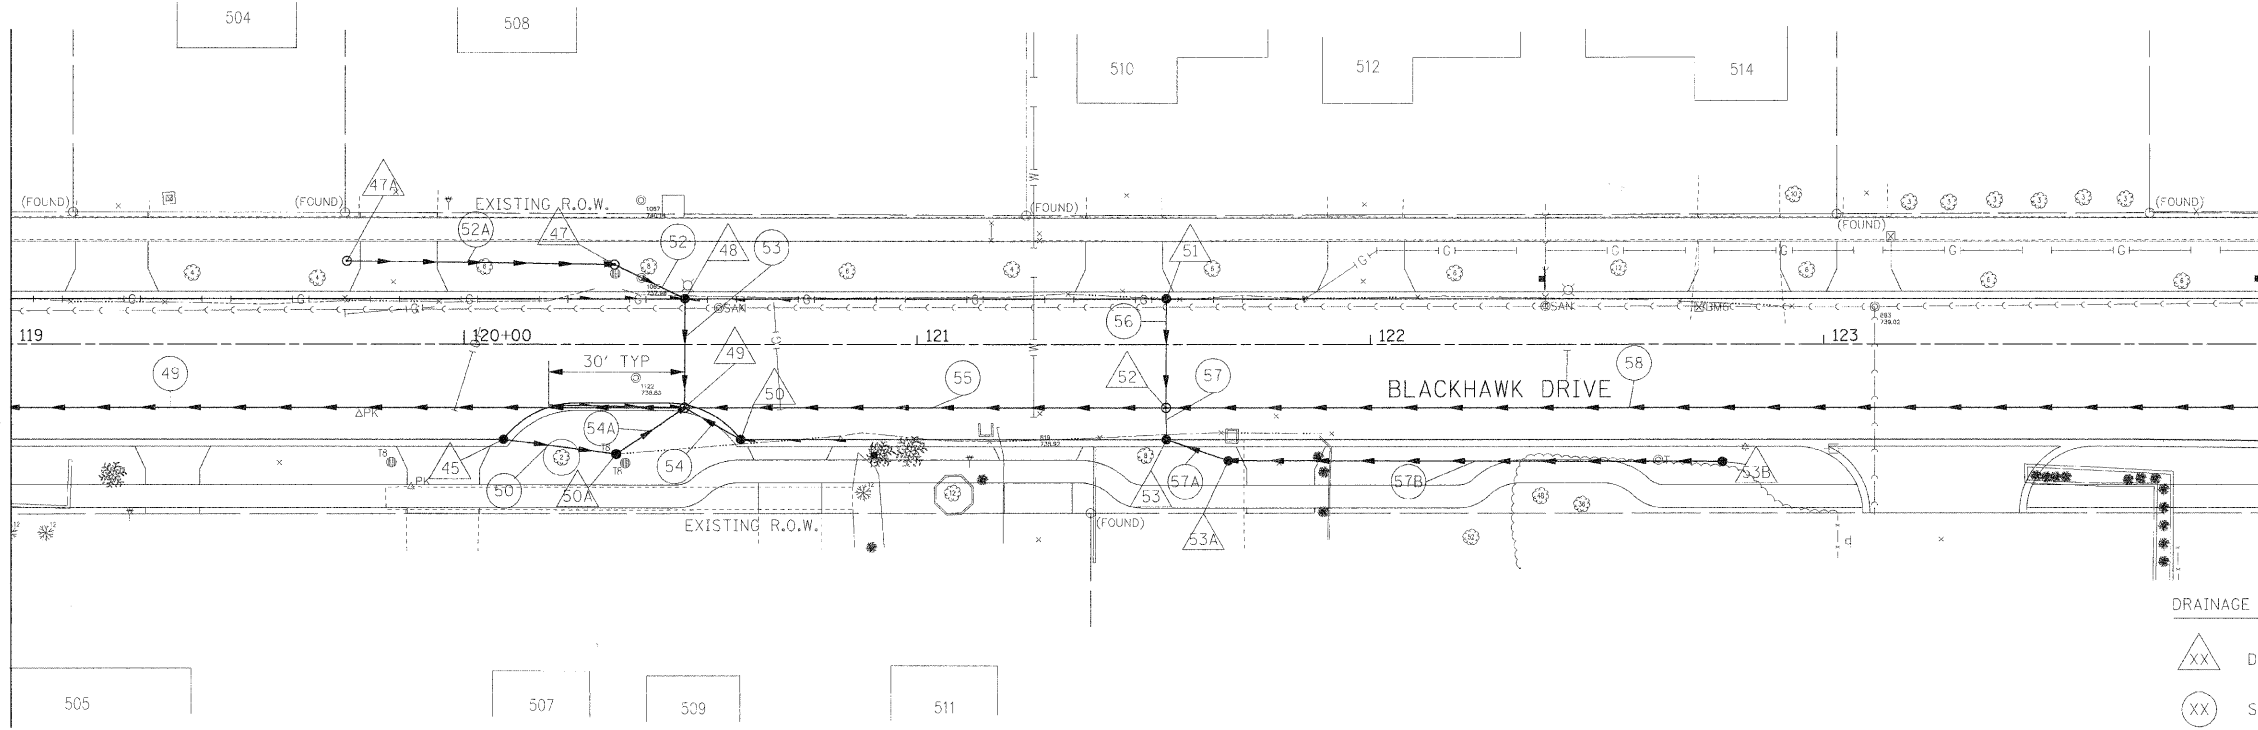

MATCHLINE STA 124+00
SEE SHEET 6 OF 6

- DRAINAGE LEGEND:
- △ XX DRAINAGE STRUCTURE NUMBER
 - XX STORM SEWER NUMBER
 - 4" PIPE UNDERDRAIN

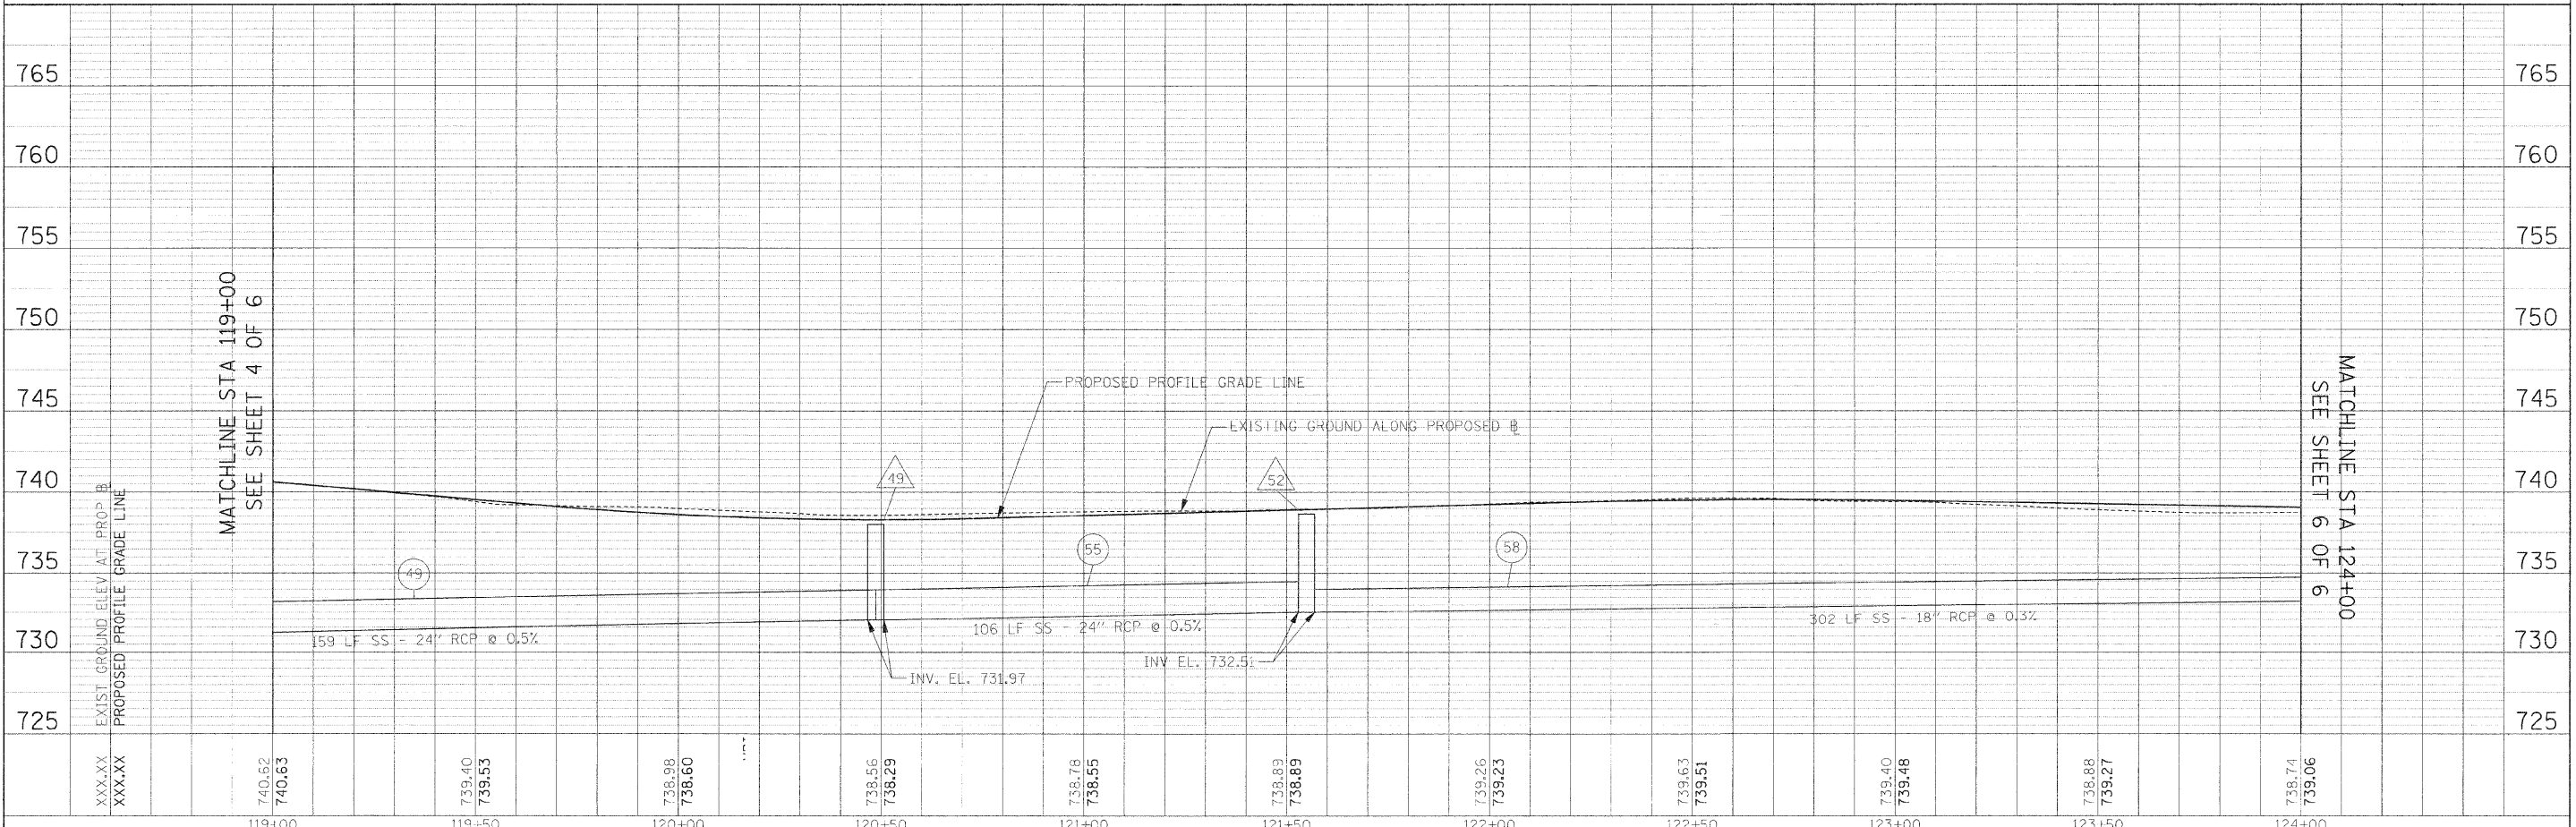

MATCHLINE STA 119+00
SEE SHEET 4 OF 6

MATCHLINE STA 124+00
SEE SHEET 6 OF 6

FILE NAME =	USER NAME = #USER#	DESIGNED - AJB	REVISED -	F.A.U. R.T.E. 3003	SECTION 00-00084-00-PV	COUNTY DUPAGE	TOTAL SHEETS 112	SHEET NO. 43
#FILE#	PLOT SCALE = #SCALE#	DRAWN - TMC	REVISED -	BLACKHAWK DR RECONSTRUCTION				CONTRACT NO. 63121
	PLOT DATE = #DATE#	CHECKED - DEB	REVISED -	FED. ROAD DIST. NO. 1 ILLINOIS FED. AID PROJECT				
		DATE - 01/02/09	REVISED -	SCALE: 1:20 SHEET NO. 5 OF 6 SHEETS STA. 119+00.00 TO STA. 124+00.00				

STATE OF ILLINOIS
DEPARTMENT OF TRANSPORTATION

DRAINAGE PLAN AND PROFILE