


INDIANWOOD BLVD

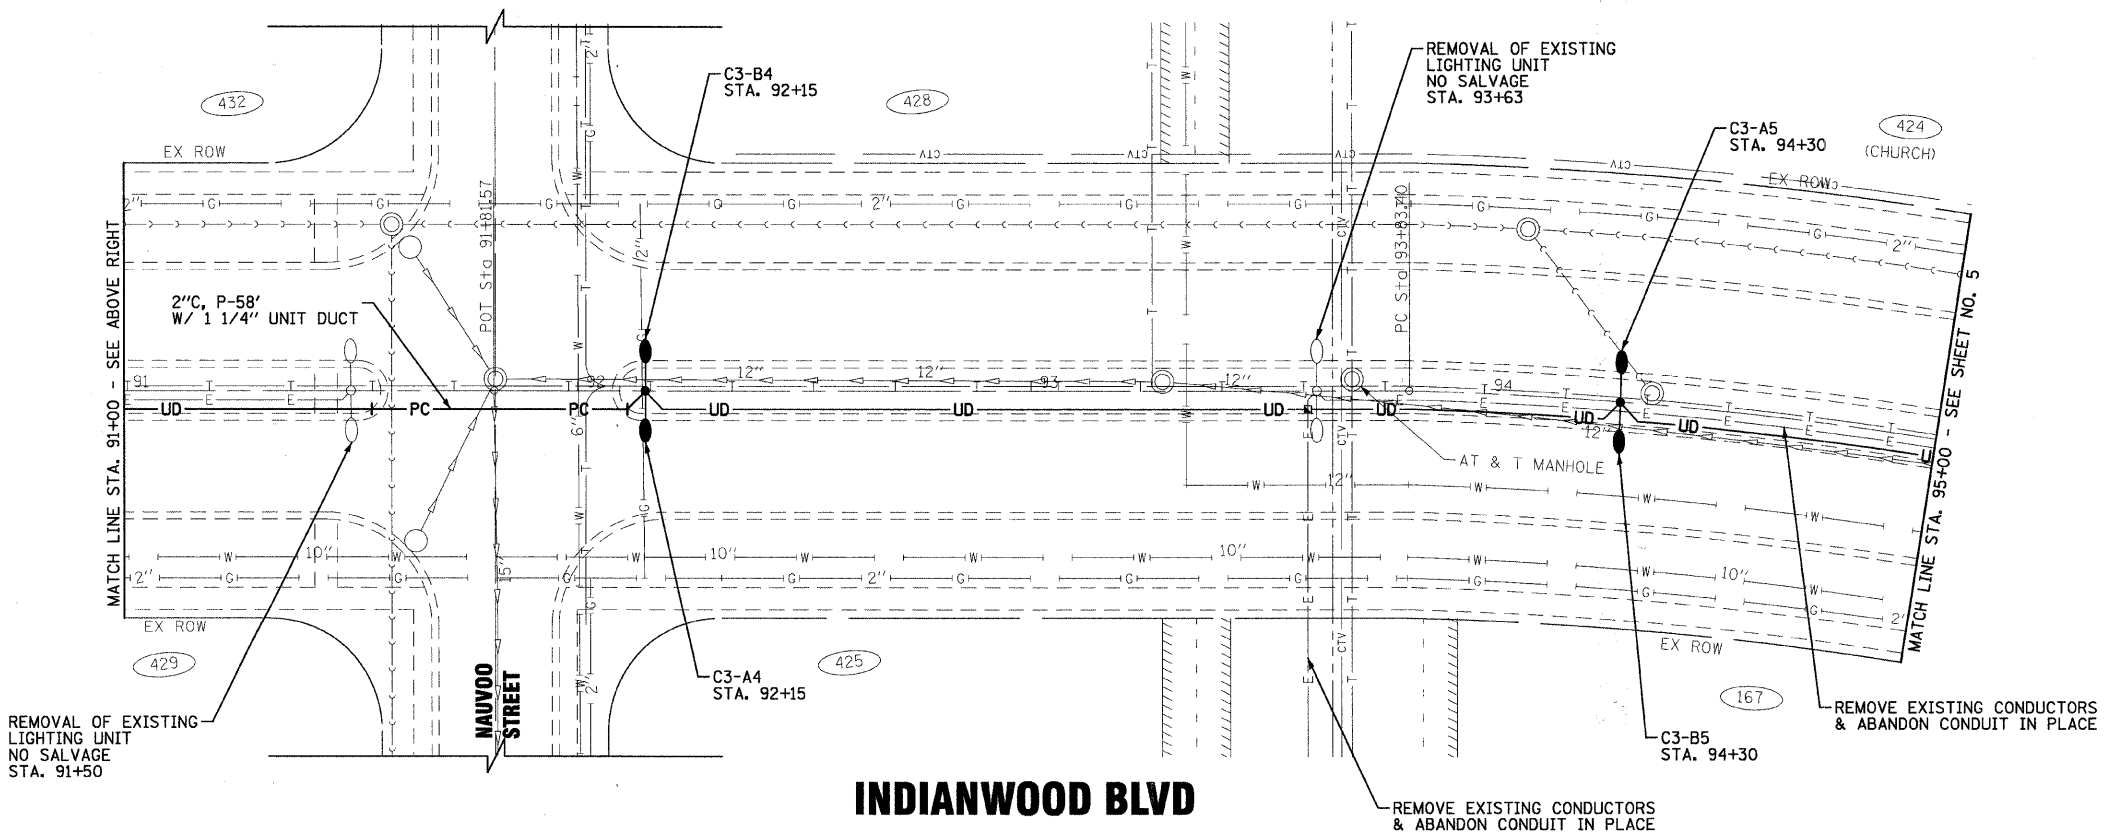

INDIANWOOD BLVD

COPYRIGHT © 2009 BY BAKER & MCGONNAN, INC.
 STATE OF ILLINOIS - PROFESSIONAL DESIGN FIRM
 LICENSE NO. - 061389-EXPRES. 4/20/2009
 12/29/2009 10:58:59 AM
 I:\p\k\T\061389-0\logns from mckemachbase\11061389-lighting-2.shx



DESIGNED - JTB	REVISED -
DRAWN - KAR	REVISED -
CHECKED - TMS	REVISED -
DATE - 12-08-08	FILE NAME - 061389-lighting-2.shx

**VILLAGE OF PARK FOREST, ILLINOIS
INDIANWOOD BOULEVARD
MONEE RD. TO BLACKHAWK DR.**

STREET LIGHTING PLAN

SCALE: 1" = 20'

STA. 86+00 TO STA. 95+00

F.A. RTE.	SECTION	COUNTY	TOTAL SHEETS	SHEET NO.
	09-00091-01-LT	COOK	7	4
CONTRACT NO. 63129				
FED. ROAD DIST. NO. [ILLINOIS] FED. AID PROJECT TCSP-061L (006)				